



PLAN VIEW
Scale: 1" = 1'

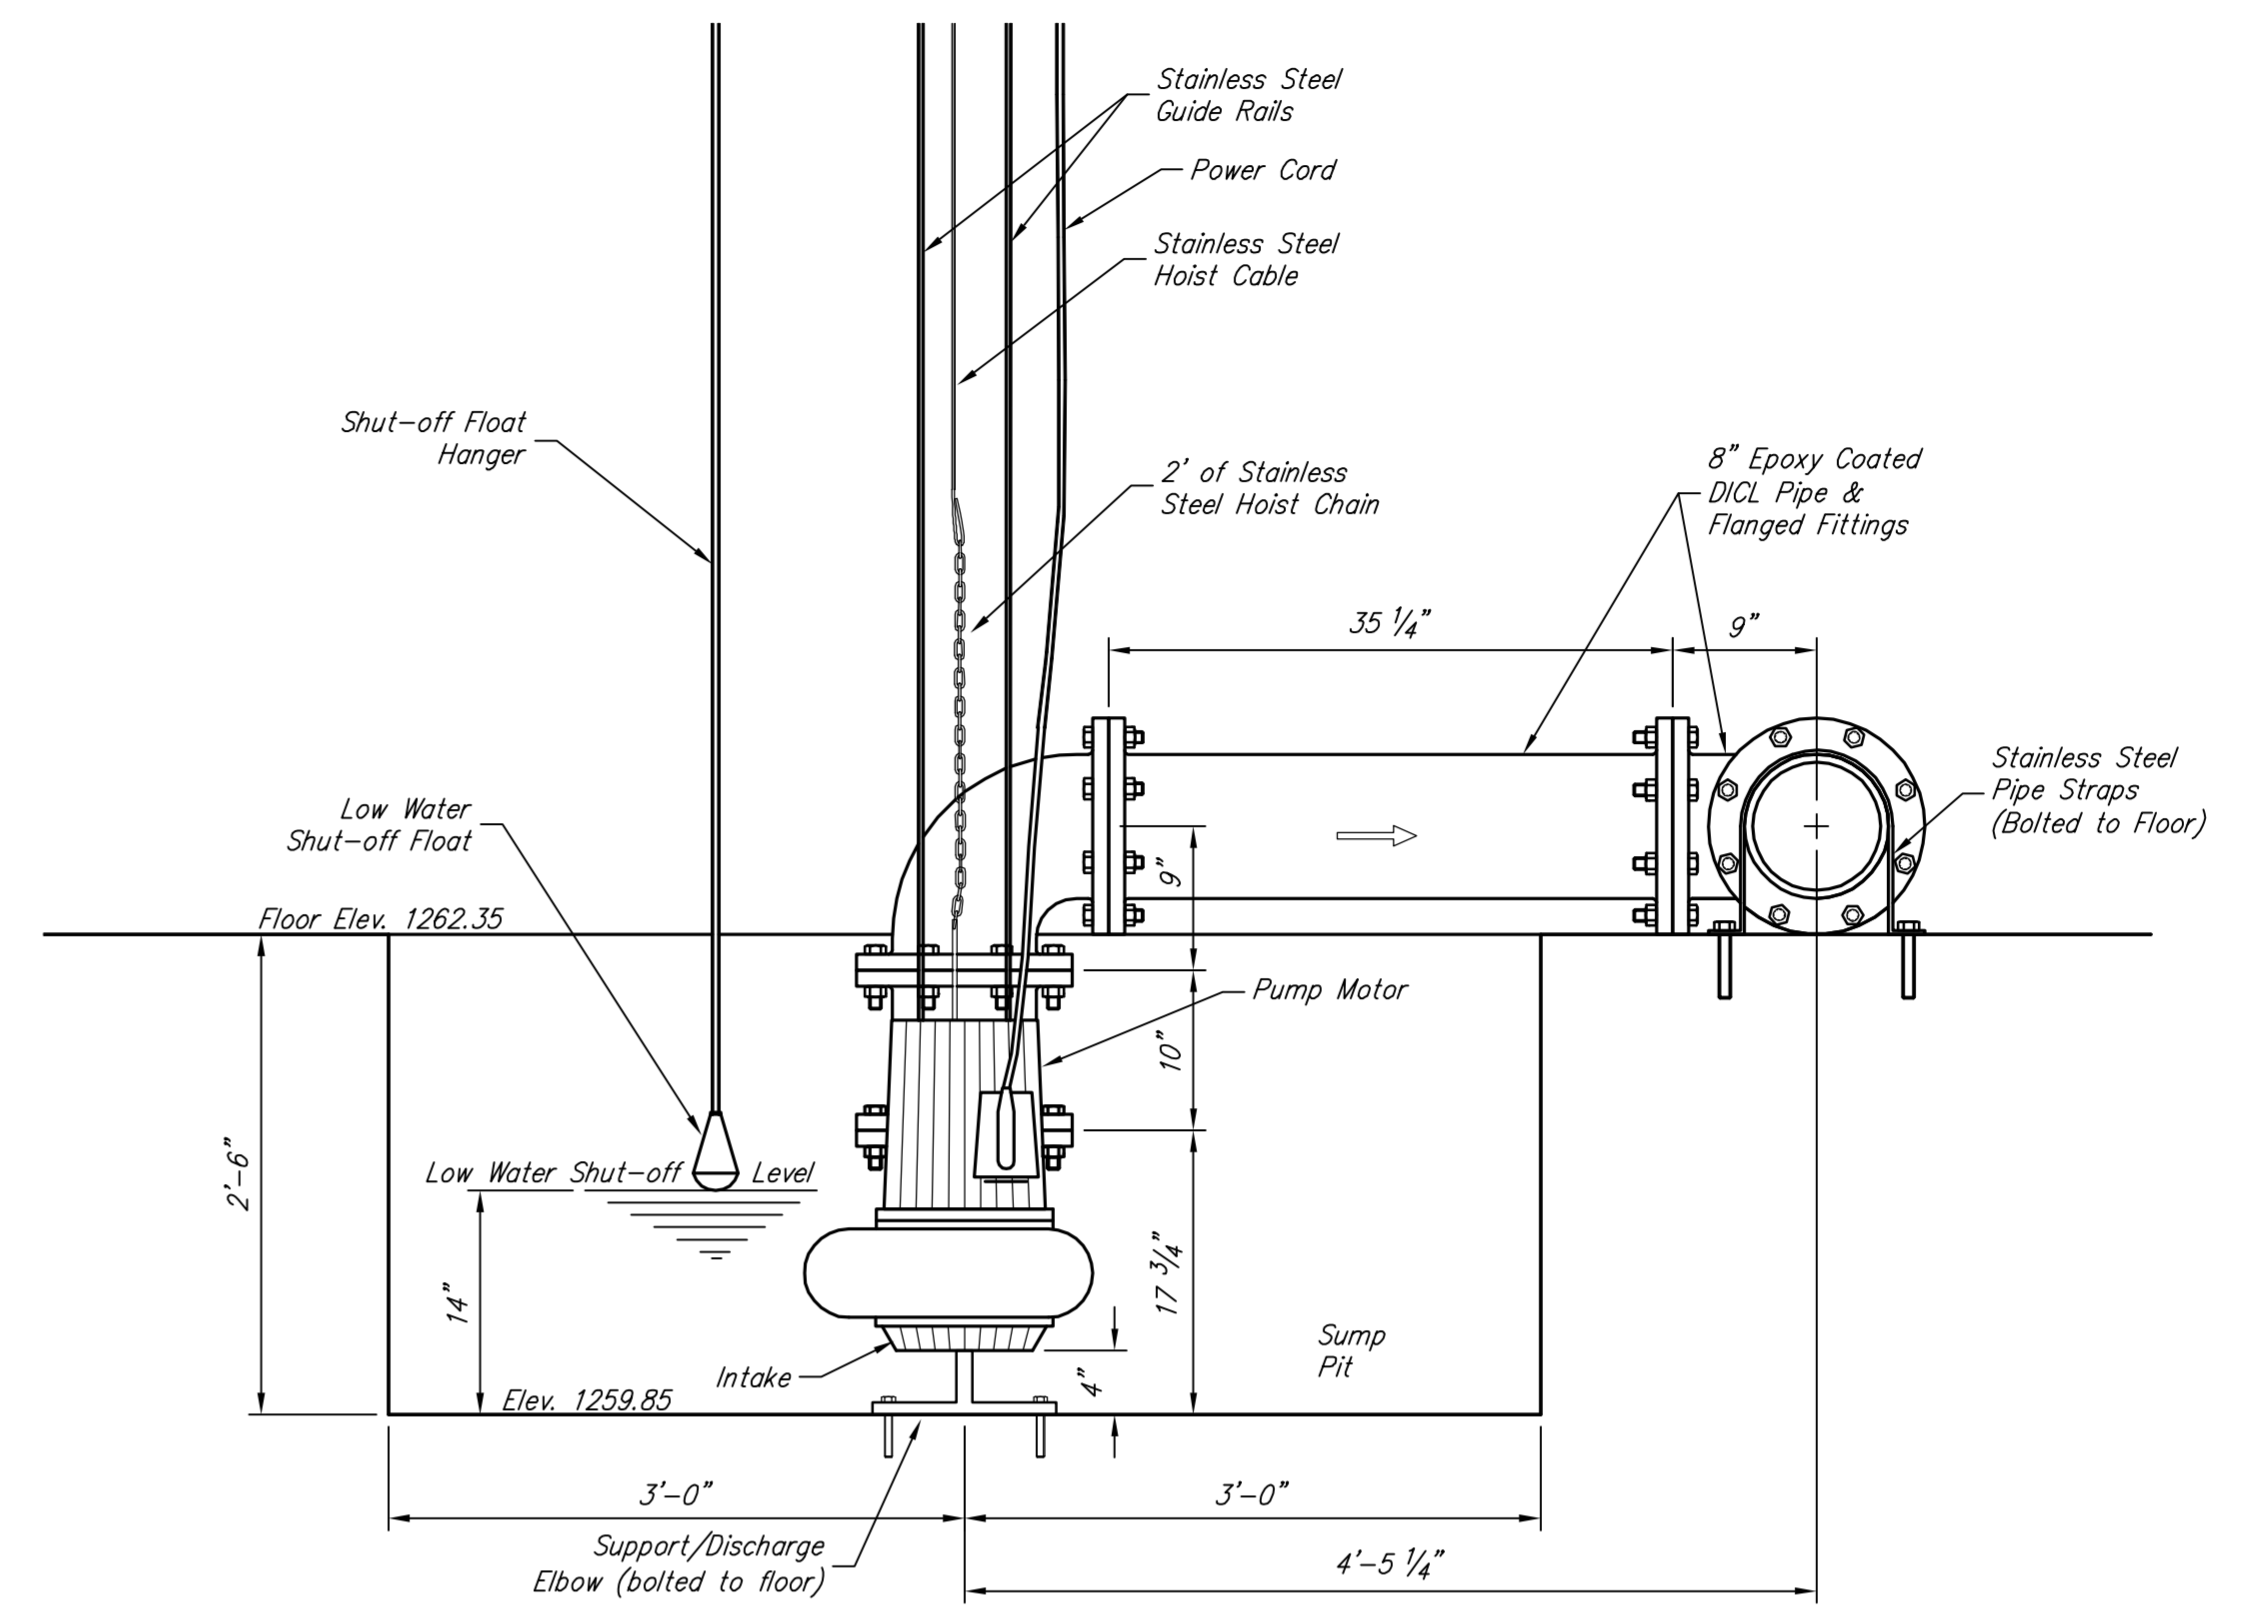

FRONT VIEW
Scale: 1" = 1'

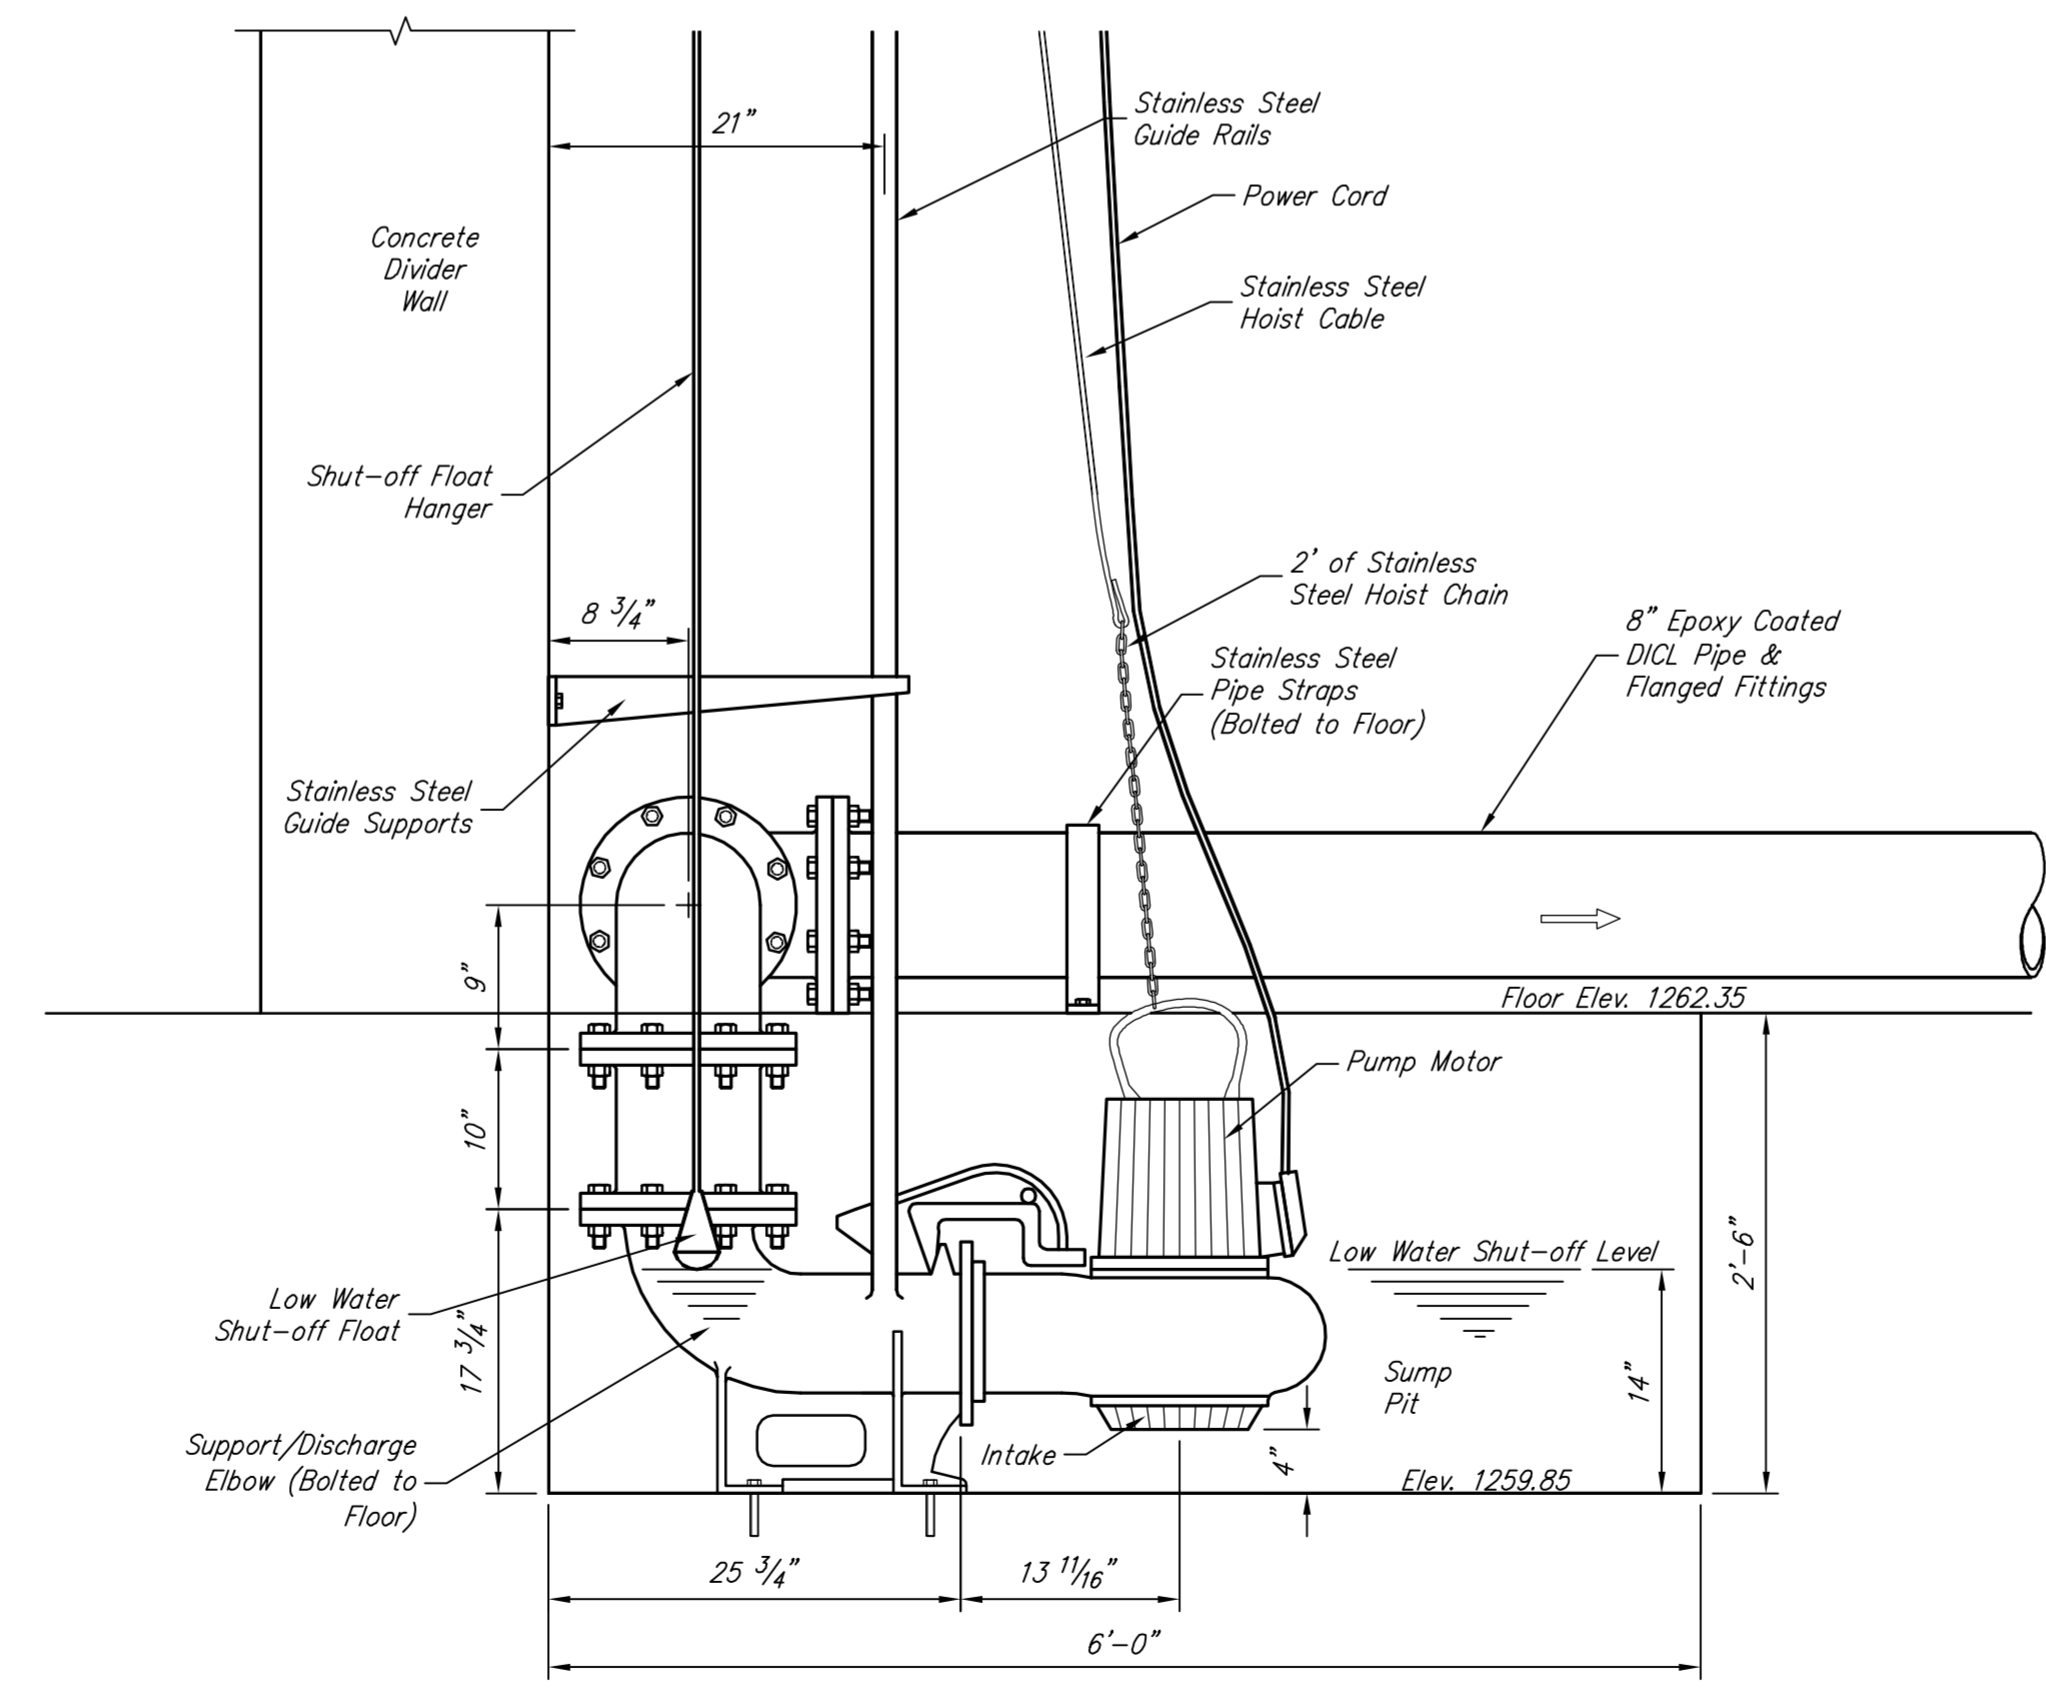

SIDE VIEW
Scale: 1" = 1'

NOTE:
Dimensions given are for Flygt Pump CP-3127 with a 412 Impeller. The Contractor shall adjust dimensions as required if other pump is used.

PUMP SCHEDULE

MARK	TYPE	GPM	HEAD (FT)	EFF. %	HP	RPM	PHASE
P-1	SUBMERSIBLE	1,200	12.6	60% MIN.	7.6	1730	1

Drawing File: E:\Projects\Meridian Drainage\Details\Inline Filter Details.dwg (Pump)
 Design: KEK
 Drawn: JAK
 Approved: JFB
 Scale: NOTED

Project No. 08-02E038 CAPITAL IMPROVEMENT PROJECT
DEBRIS REMOVAL STRUCTURE
SUBMERSIBLE PUMP DETAILS
 MERIDIAN AVENUE DRAINAGE OUTFALL PROJECT

Baughman Company, P.A.
 315 Ellis St., Wichita, KS 67211 P 316-262-7271 F 316-262-0149
 ENGINEERING | SURVEYING | PLANNING | LANDSCAPE ARCHITECTURE

January 2013
 SHEET
104
 OF
119