

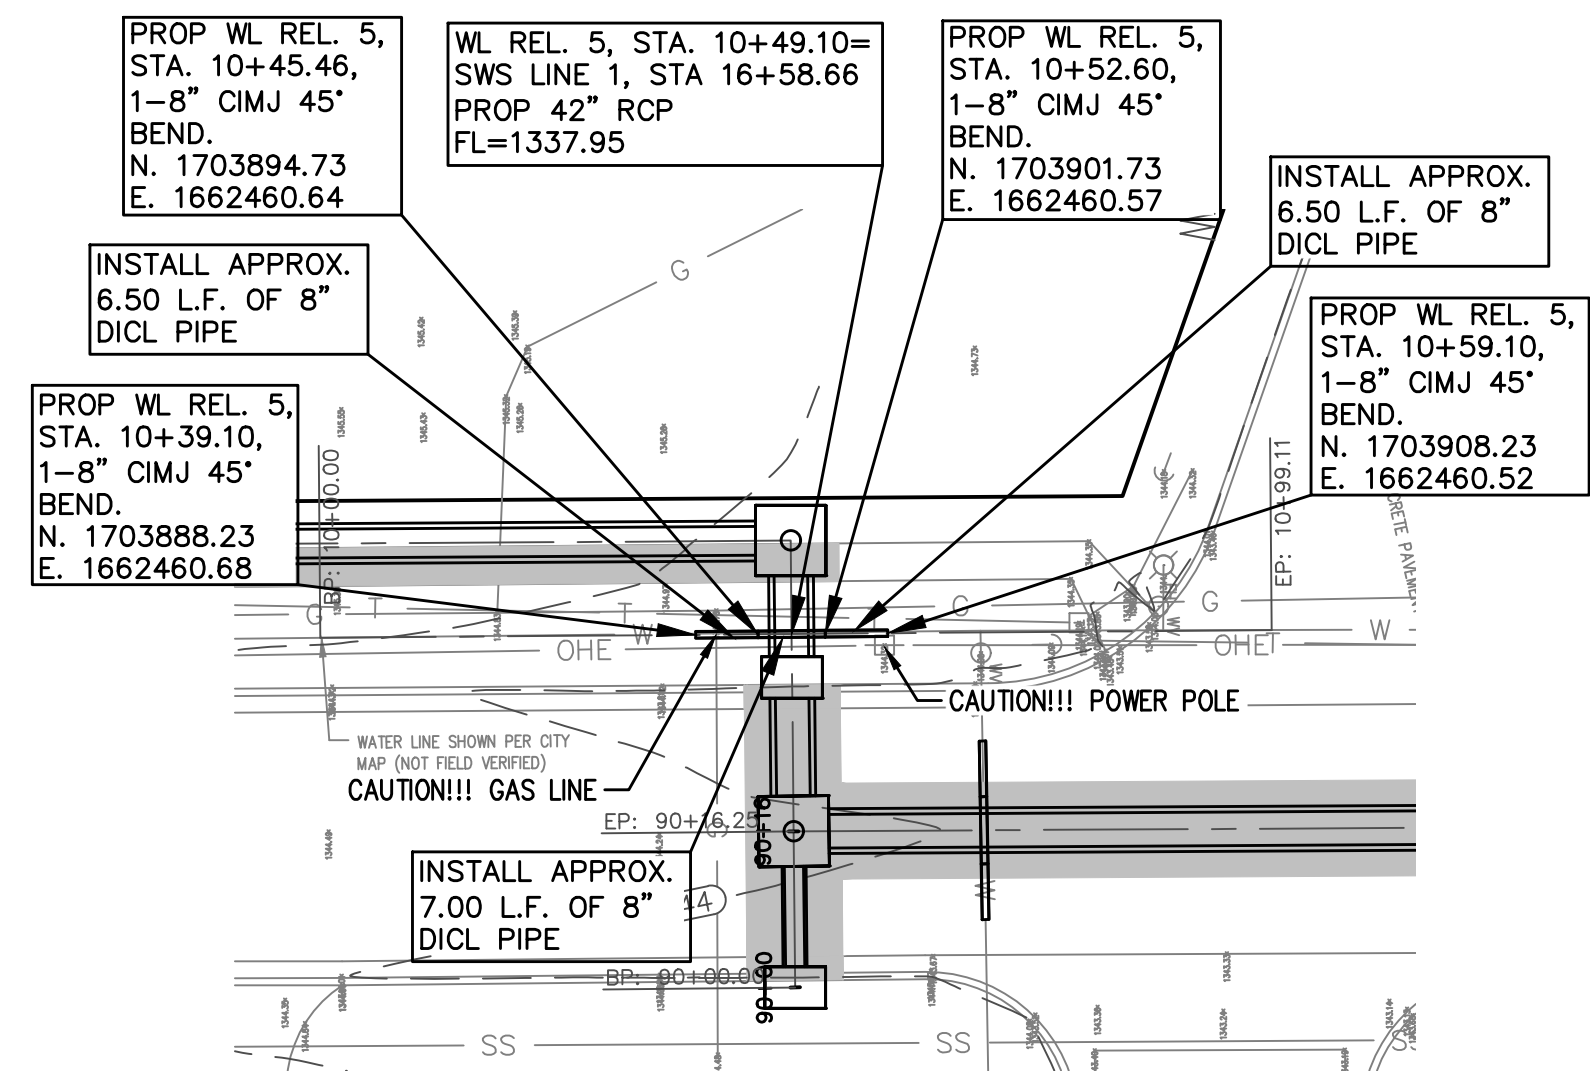


UTILITY RELOCATION NOTE:
ALL UTILITY OWNERS HAVE BEEN NOTIFIED OF REQUIRED UTILITY RELOCATIONS DUE TO PROJECT IMPROVEMENTS. CONTRACTOR SHALL VERIFY ALL EXISTING UTILITY ELEVATIONS AND COORDINATE WITH UTILITY OWNERS ON THE STATUS OF THE REQUIRED UTILITY RELOCATES AND/OR PLANS FOR RELOCATION DURING CONSTRUCTION.


| | | | |
|----------------------|----------------|------------------|------------------|
| KANSAS GAS SERVICE | PAMELA GUNTER | 0:1-316-832-3187 | 0:1-888-482-4950 |
| WESTAR ENERGY | HEIDE HANCOCK | 0:1-316-261-6824 | 0:1-888-383-1183 |
| AT&T | JASON EDWARDS | 0:1-316-268-2008 | 0:1-800-870-8390 |
| COX COMMUNICATIONS | JEREMY WALLACE | C:1-316-260-7195 | O:263-2061 |
| C.O.W. WATER & SEWER | GREG LOLLEY | 0:1-316-268-4555 | |

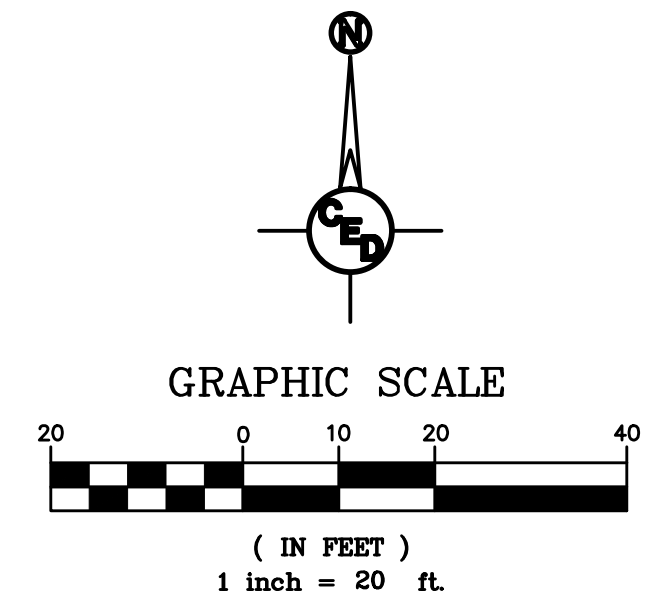

Water Line Relocation No. 5

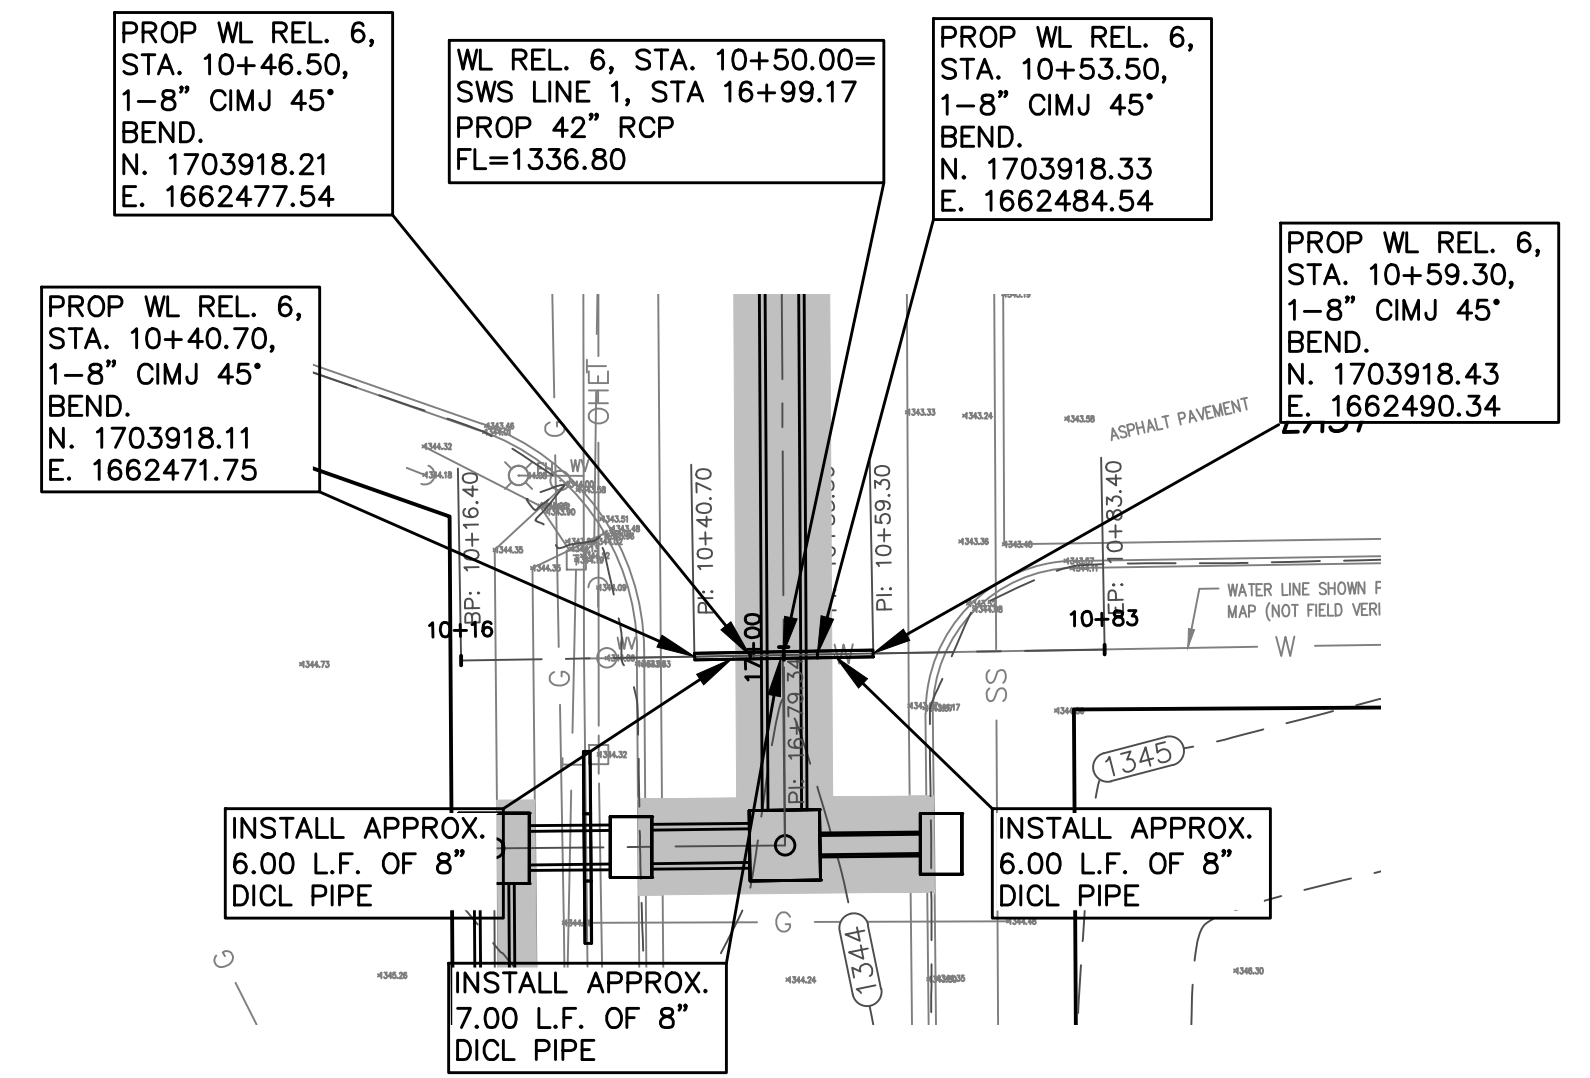

Water Line Relocation No. 6

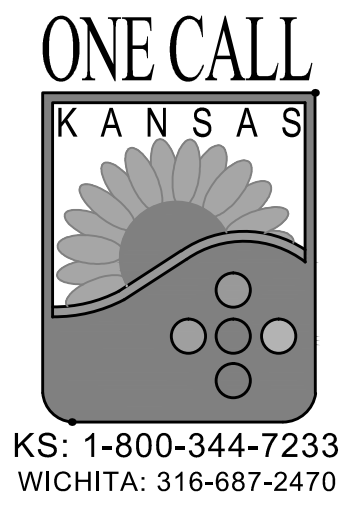

NORTH IVA & 27TH STREET NORTH

DRAINAGE IMPROVEMENTS

SEC. 2, T27S, R1E
WICHITA, KANSAS

CERTIFIED ENGINEERING DESIGN, P.A.
CIVIL ENGINEERING SERVICES



1935 WEST MAPLE STREET
WICHITA, KANSAS 67213
PH.(316)262-8808 FAX.(316)262-1669

ISSUED FOR CONSTRUCTION

PROJECT NO.: 20101910
ISSUE DATE: 10/20/2011
CONTACT: C WINKLER / H FORAKER
DRAWN BY: CC, CW CHECKED BY: HDF

WATER LINE RELOCATION PLAN AND PROFILE

