
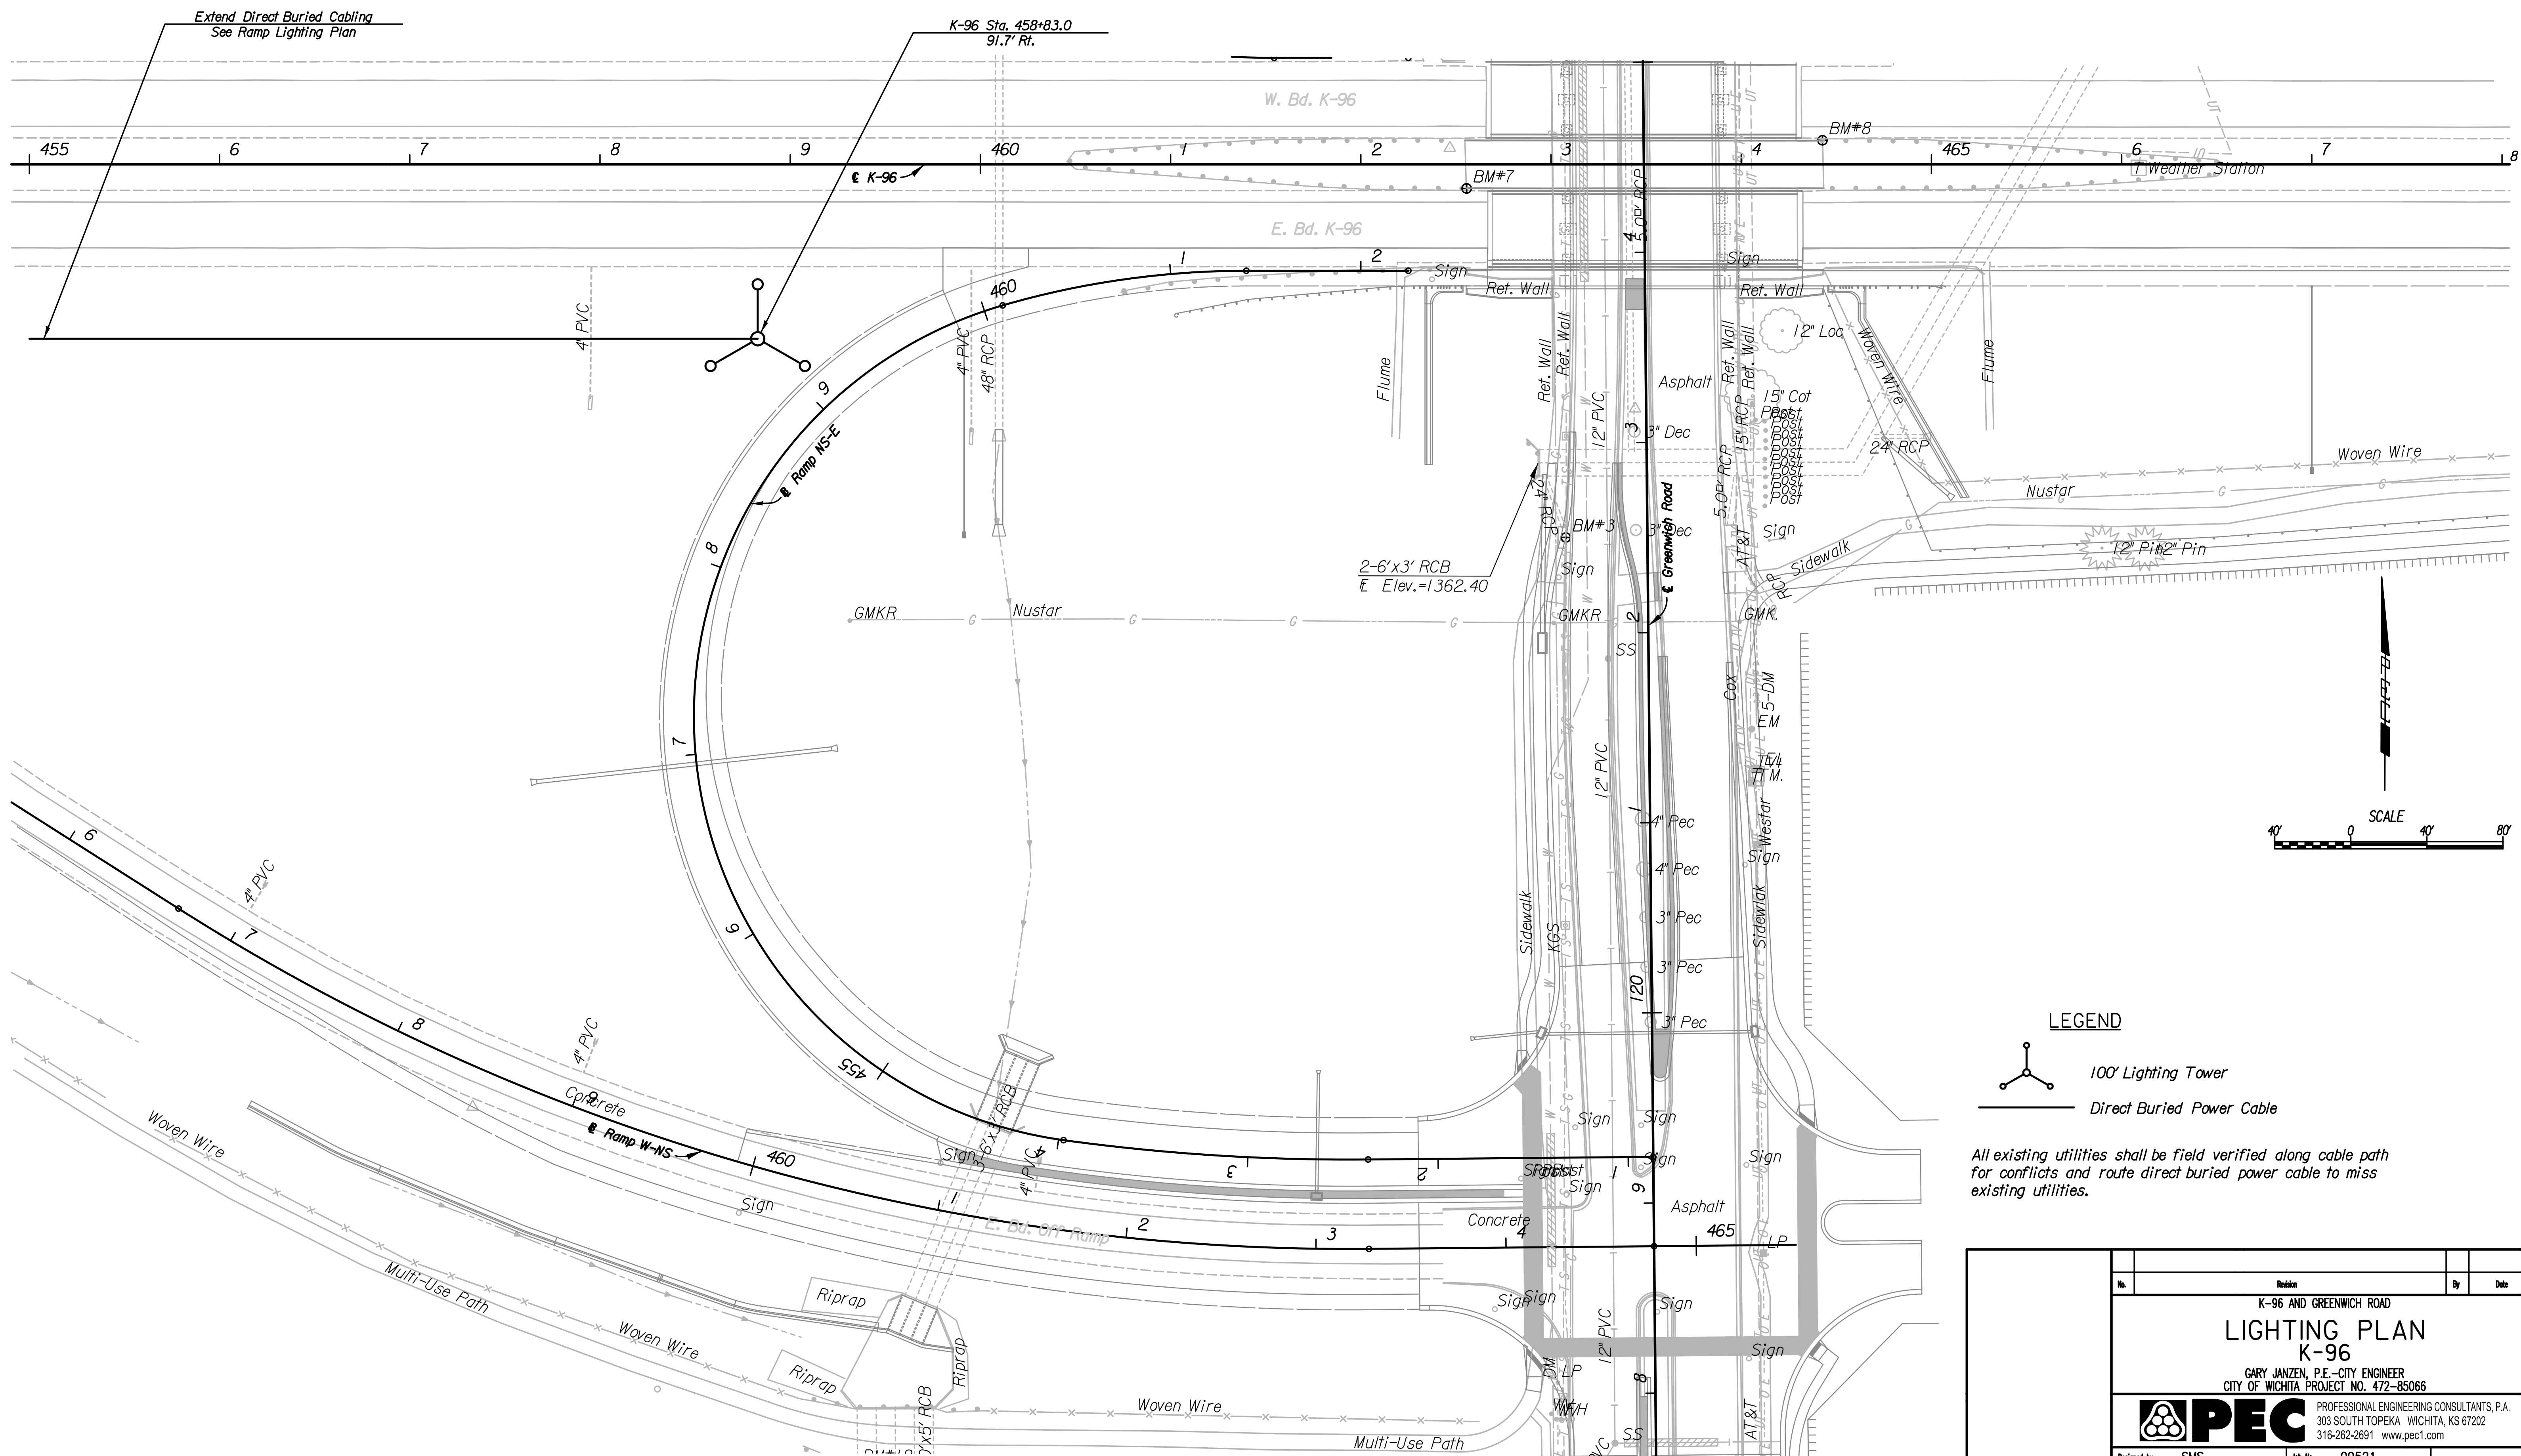



Plotted By: svb Date: 12/31/2013 9:51:06 AM  
 FILE: I:\2009\0952\Lighting\0952L\F01.dgn

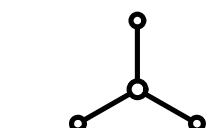

**LEGEND**

 100' Lighting Tower

 Direct Buried Power Cable

All existing utilities shall be field verified along cable path for conflicts and route direct buried power cable to miss existing utilities.

No.	Revision	By	Date
K-96 AND GREENWICH ROAD			
<b>LIGHTING PLAN</b>			
<b>K-96</b>			
GARY JANZEN, P.E.-CITY ENGINEER			
CITY OF WICHITA PROJECT NO. 472-85066			
<b>PEC</b> PROFESSIONAL ENGINEERING CONSULTANTS, P.A.			
303 SOUTH TOPEKA WICHITA, KS 67202			
316-262-2691 www.pec1.com			
Designed by	SMS	Job No.	09521
Drawn by	WAN	Date	Jan., 2014
			Sht. 149 of 388