
 
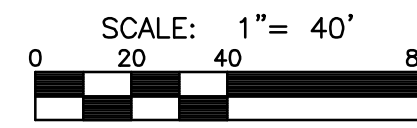


- NOTES:**
1. CONTRACTOR TO VERIFY THE DEPTH AND LOCATION OF EXISTING UTILITIES PRIOR TO CONSTRUCTION.
 2. CONTRACTOR SHALL COORDINATE WORK IN THIS AREA WITH WESTAR ENERGY. WESTAR TO TEMPORARILY SUPPORT POWER POLE TO FACILITATE SEWER CONSTRUCTION.



**PLAN LINE 1
PROFILE LINE 1**

**PLAN LINE 2
PROFILE LINE 2**

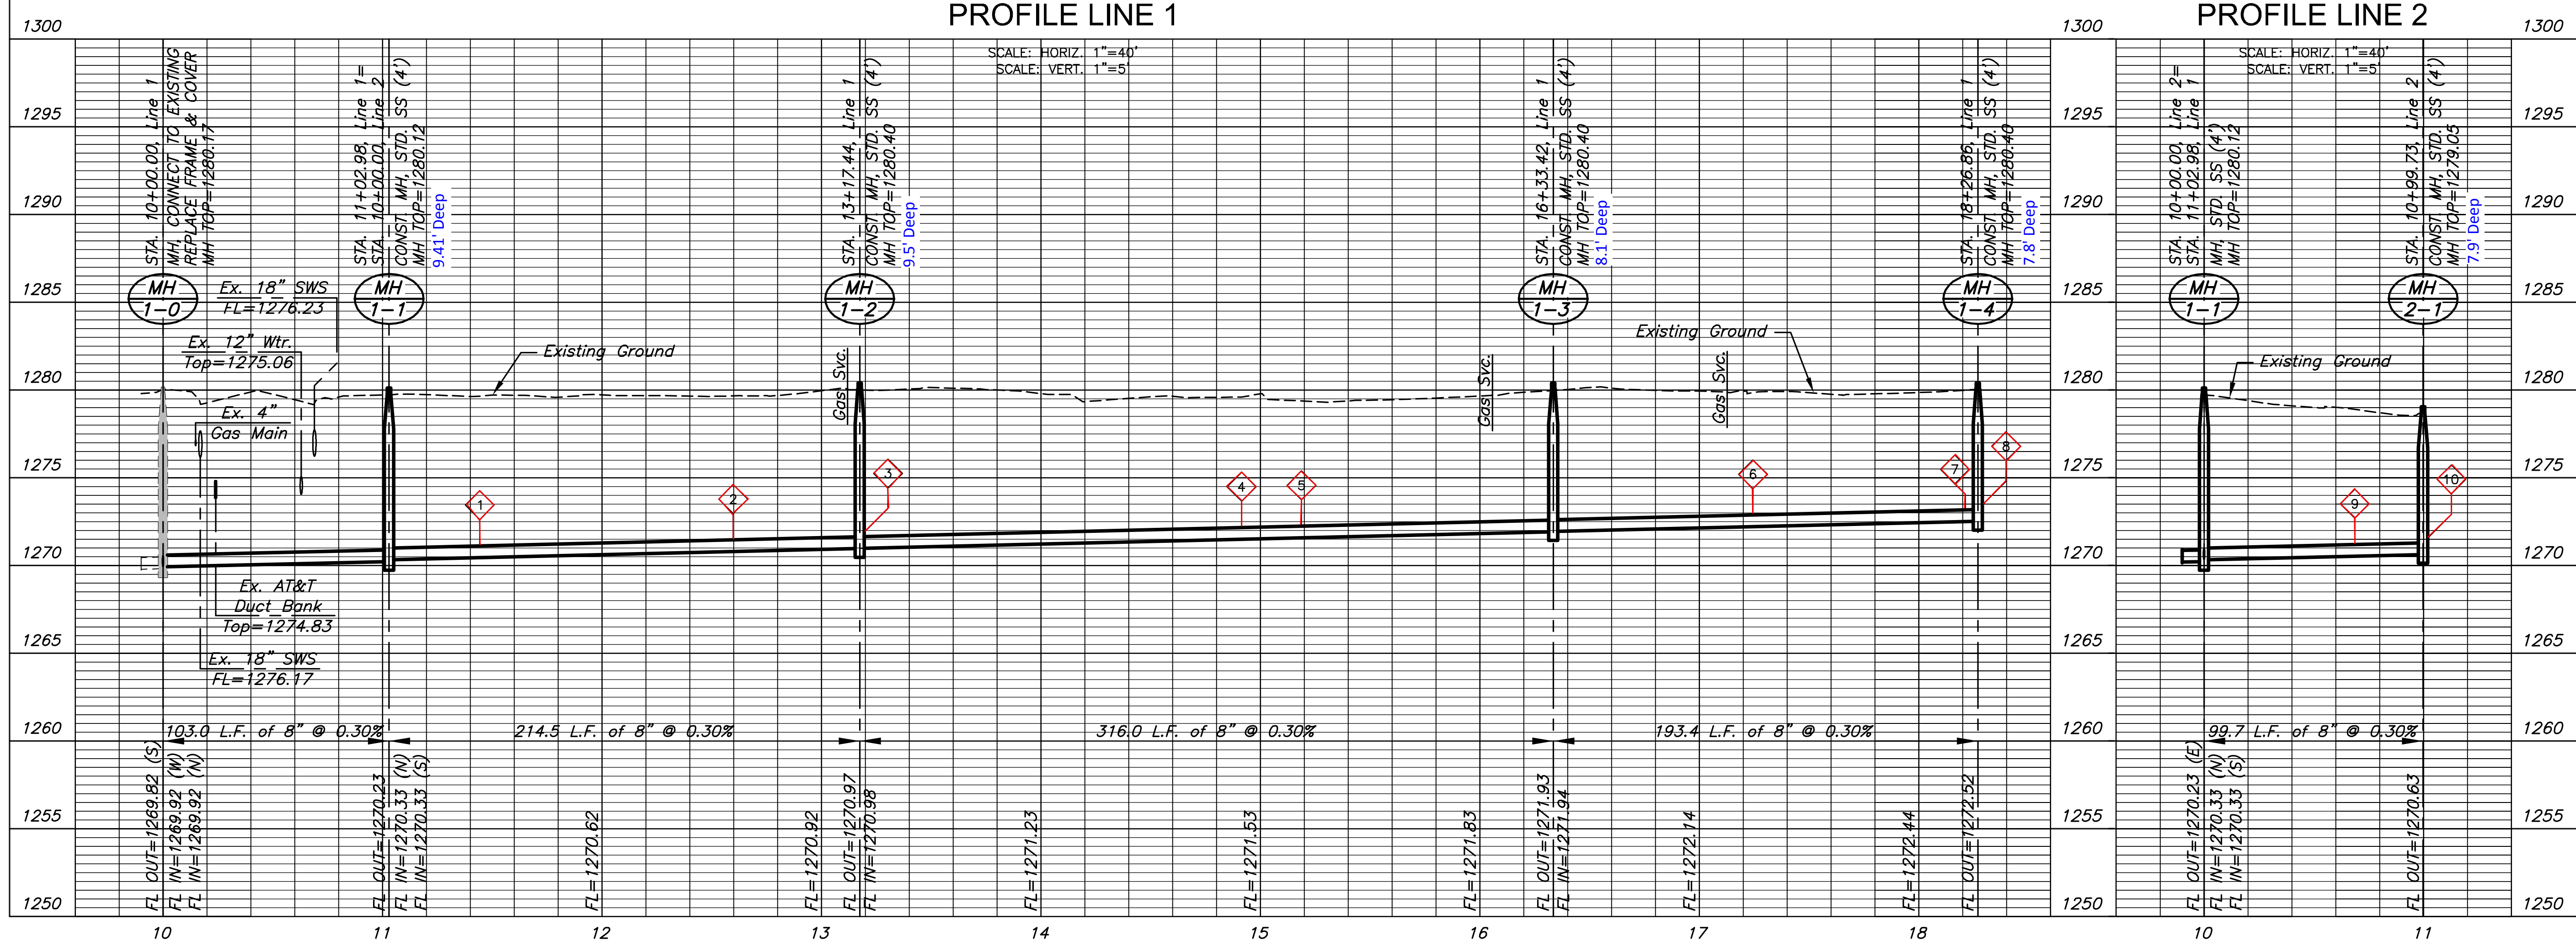

SANITARY SEWER PLANS FOR
LATERAL 100, MAIN 1
SOUTHWEST INTERCEPTOR SEWER
 CITY OF WICHITA, KANSAS

©2013 MKEC Engineering All Rights Reserved
 These drawings and their contents, including, but not limited to, all concepts, designs, & ideas are the exclusive property of MKEC Engineering (MKEC), and may not be used or reproduced in any way without the express consent of MKEC.

PLAN AND PROFILE LINES 1 & 2

PROJECT NO.	468-84947	
DATE	DATE	
SCALE	1" = 40' (HZ.)	
DESIGNED	DRAWN	CHECKED
DMU	DMU	JRA
NO.	REVISION	DATE
SHEET NO.		
5 OF 21		

U:\CTA\833\WOL\PROJECTS\2014\1401040325_CITY OF WICHITA_SW INTERCEPTOR SEWER\DWG\CAD\DWG\SAN140325SAN.DWG