


# DUCTLESS SPLIT SYSTEM SCHEDULE

MARK IN	MARK OUT	INDOOR UNIT				OUTDOOR UNIT				HEAT				VOLTAGE	REMARKS	ELECT. REF.	
		MNTG.	CFM	EDB/ EWB	MCA	CAPACITY (MBH)		ODB	SEER	MCA	CAPACITY (MBH)		EDB				ODB
						RATED	MINIMUM				RATED	MINIMUM					
DAC-1	DCU-1	WALL	500	80/67	②	24	5.2	95	17.5	14	--	--	--	--	208/1	①	

① BASED ON FRIEDRICH M24CG WALL MOUNT DUCTLESS SPLIT SYSTEM. PROVIDE WITH WIRED CONTROLLER, INVERTER COMPRESSOR, WASHABLE FILTER, 410A REFG.  
 ② SINGLE POINT CONNECTION TO OUTDOOR UNIT.

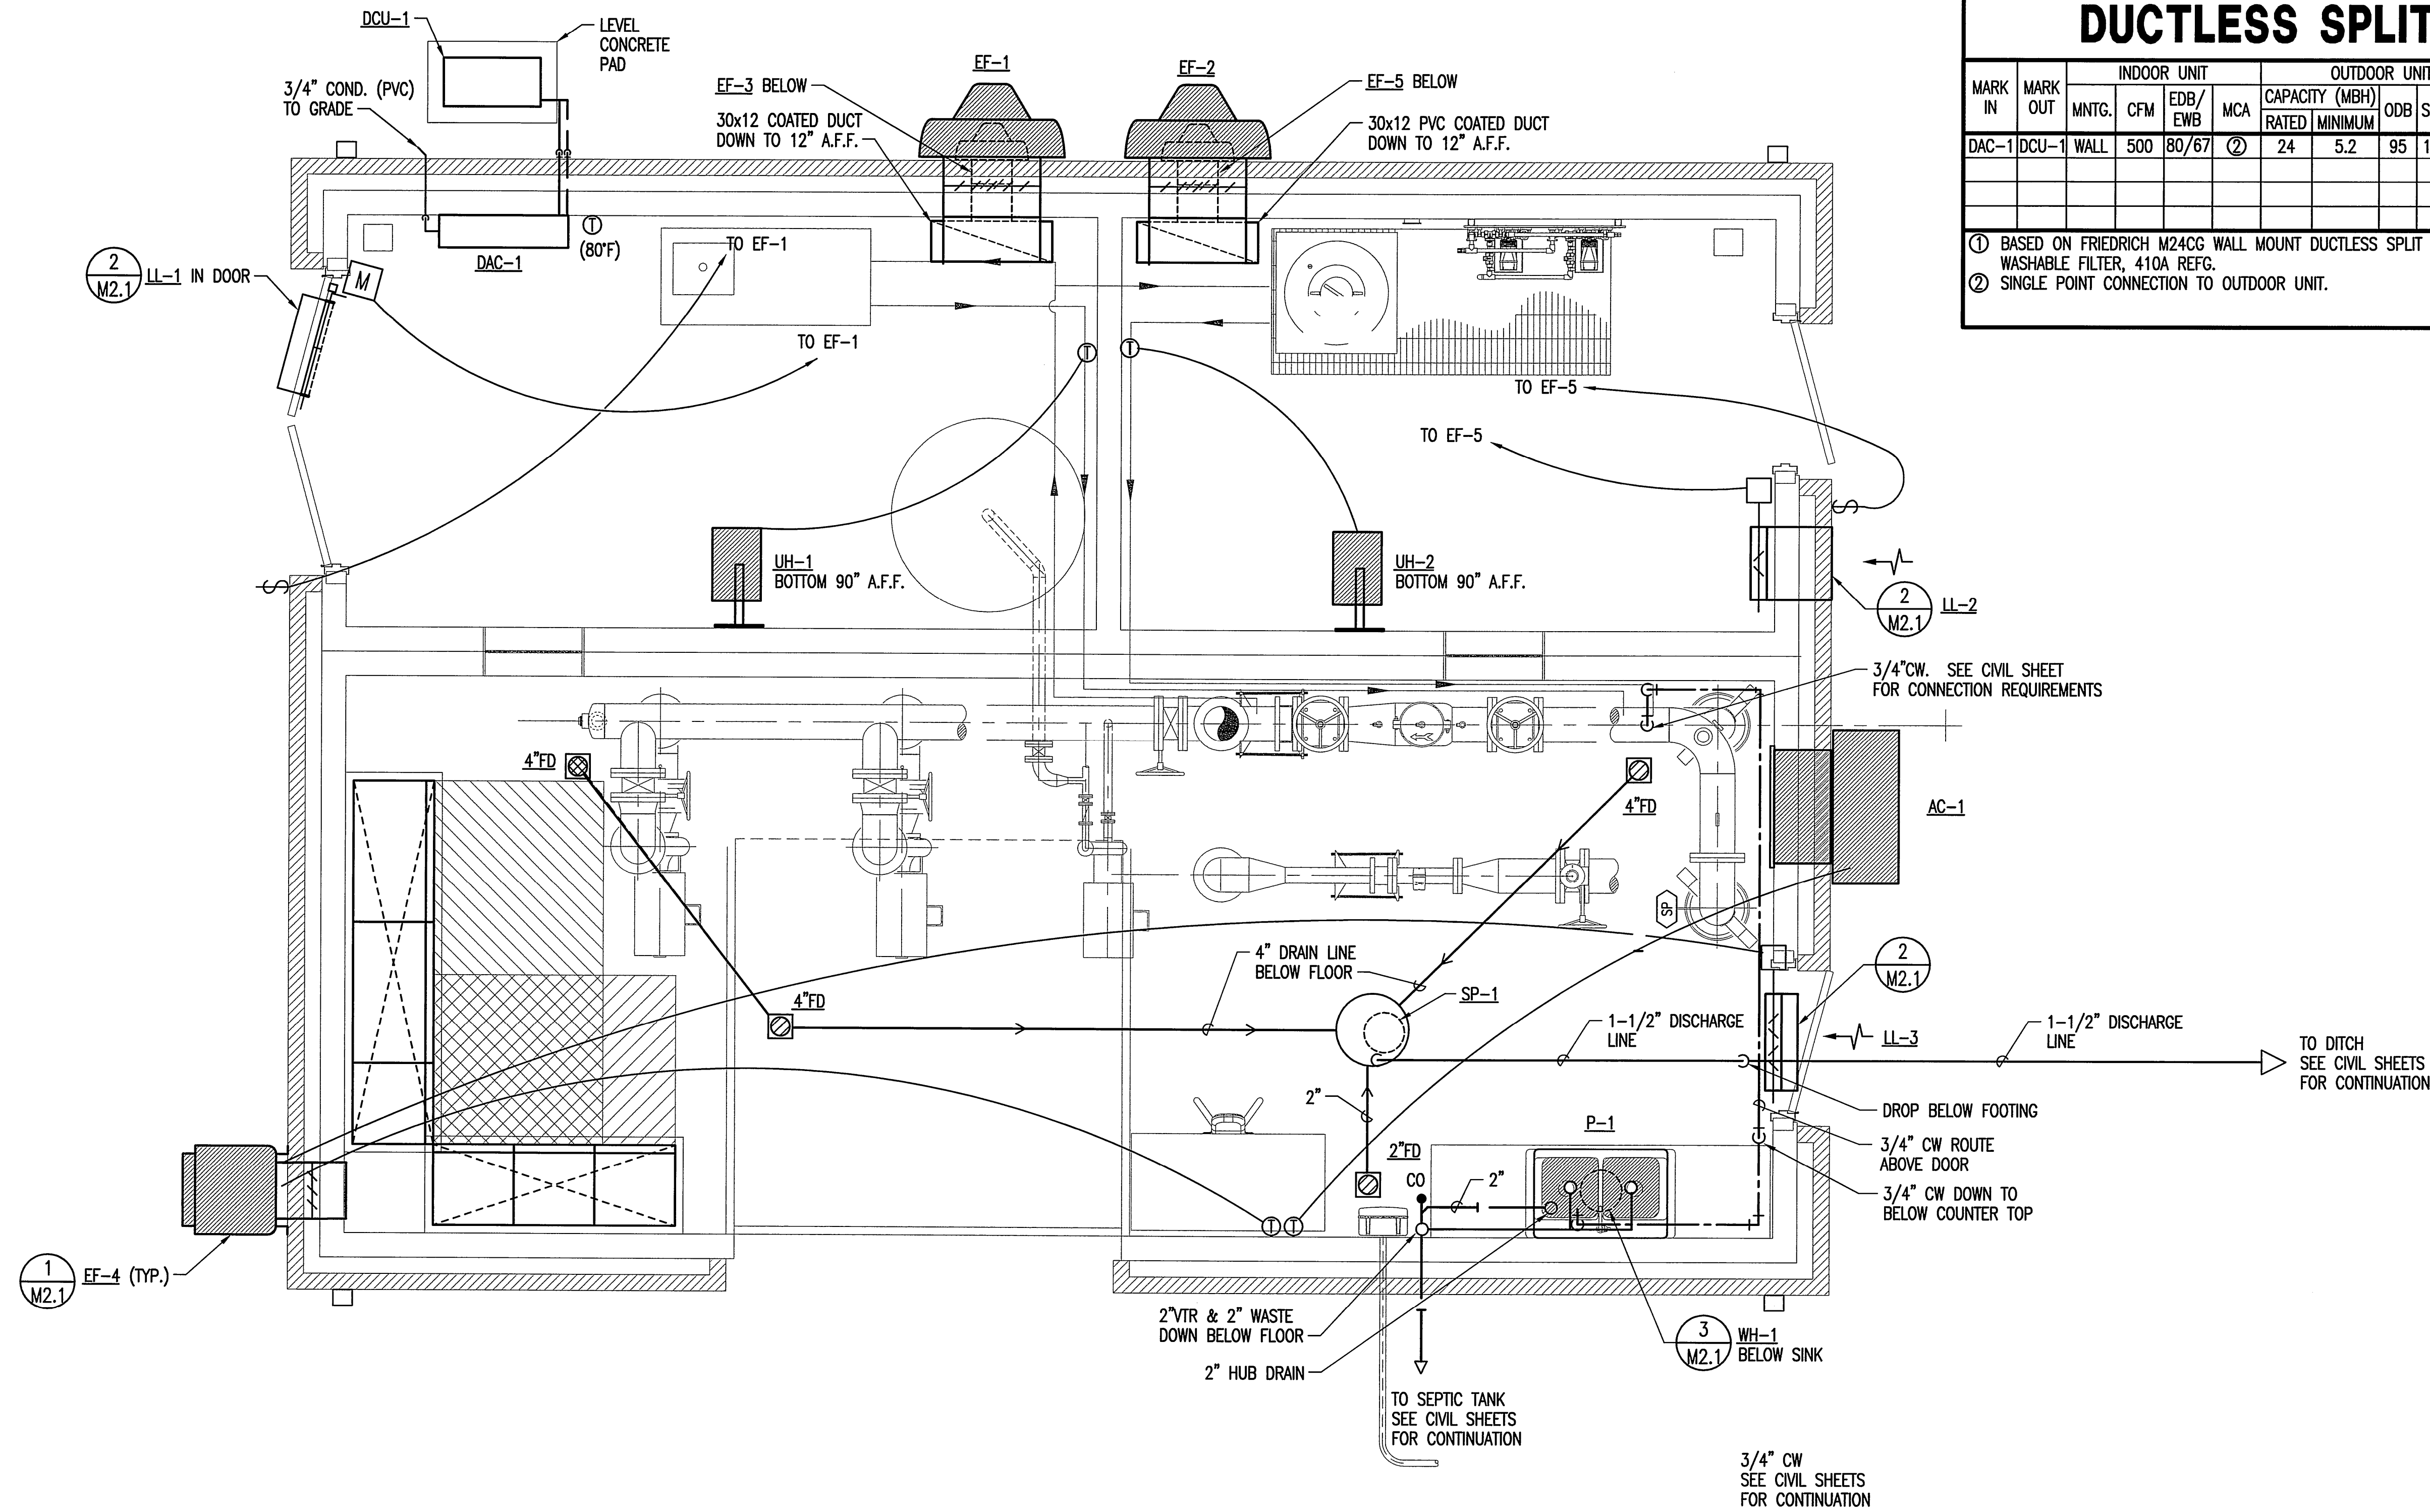

1 MECHANICAL FLOOR PLAN  
 SCALE: 1/2" = 1'-0"

Sheet 07-11-2013 11:13:55 AM by JMU  
 Plot Scale: 1/2" = 1'-0" 4/10/51 P.M.  
 M:\2011\1123\1123 M1-1 MECHANICAL FLOOR PLAN

SEDGWICK COUNTY RURAL WATER DISTRICT #1  
 WATER DISTRIBUTION SYSTEM IMPROVEMENTS  
**MECHANICAL FLOOR PLANS**  
 GARY JANZEN, P.E. - CITY ENGINEER  
 CITY OF WICHITA PROJECT NO. 448-90565

No.	Revision	By	Date

Designed by JBG  
 Drawn by JMU

Job No. 34-11123  
 Date JULY 2013

Sht. M1.1 of 24