


Saved: 01-31-2015 12:32:25 PM by: CIV  
 Plot Scale: 1:1 02-24-2015 10:45:10 AM by: CHRIS VAIL  
 U:\Wichita-Facility\2014\14229\001\Elec\Drawings\EG.4 EXISTING ONE-LINE DIAGRAM

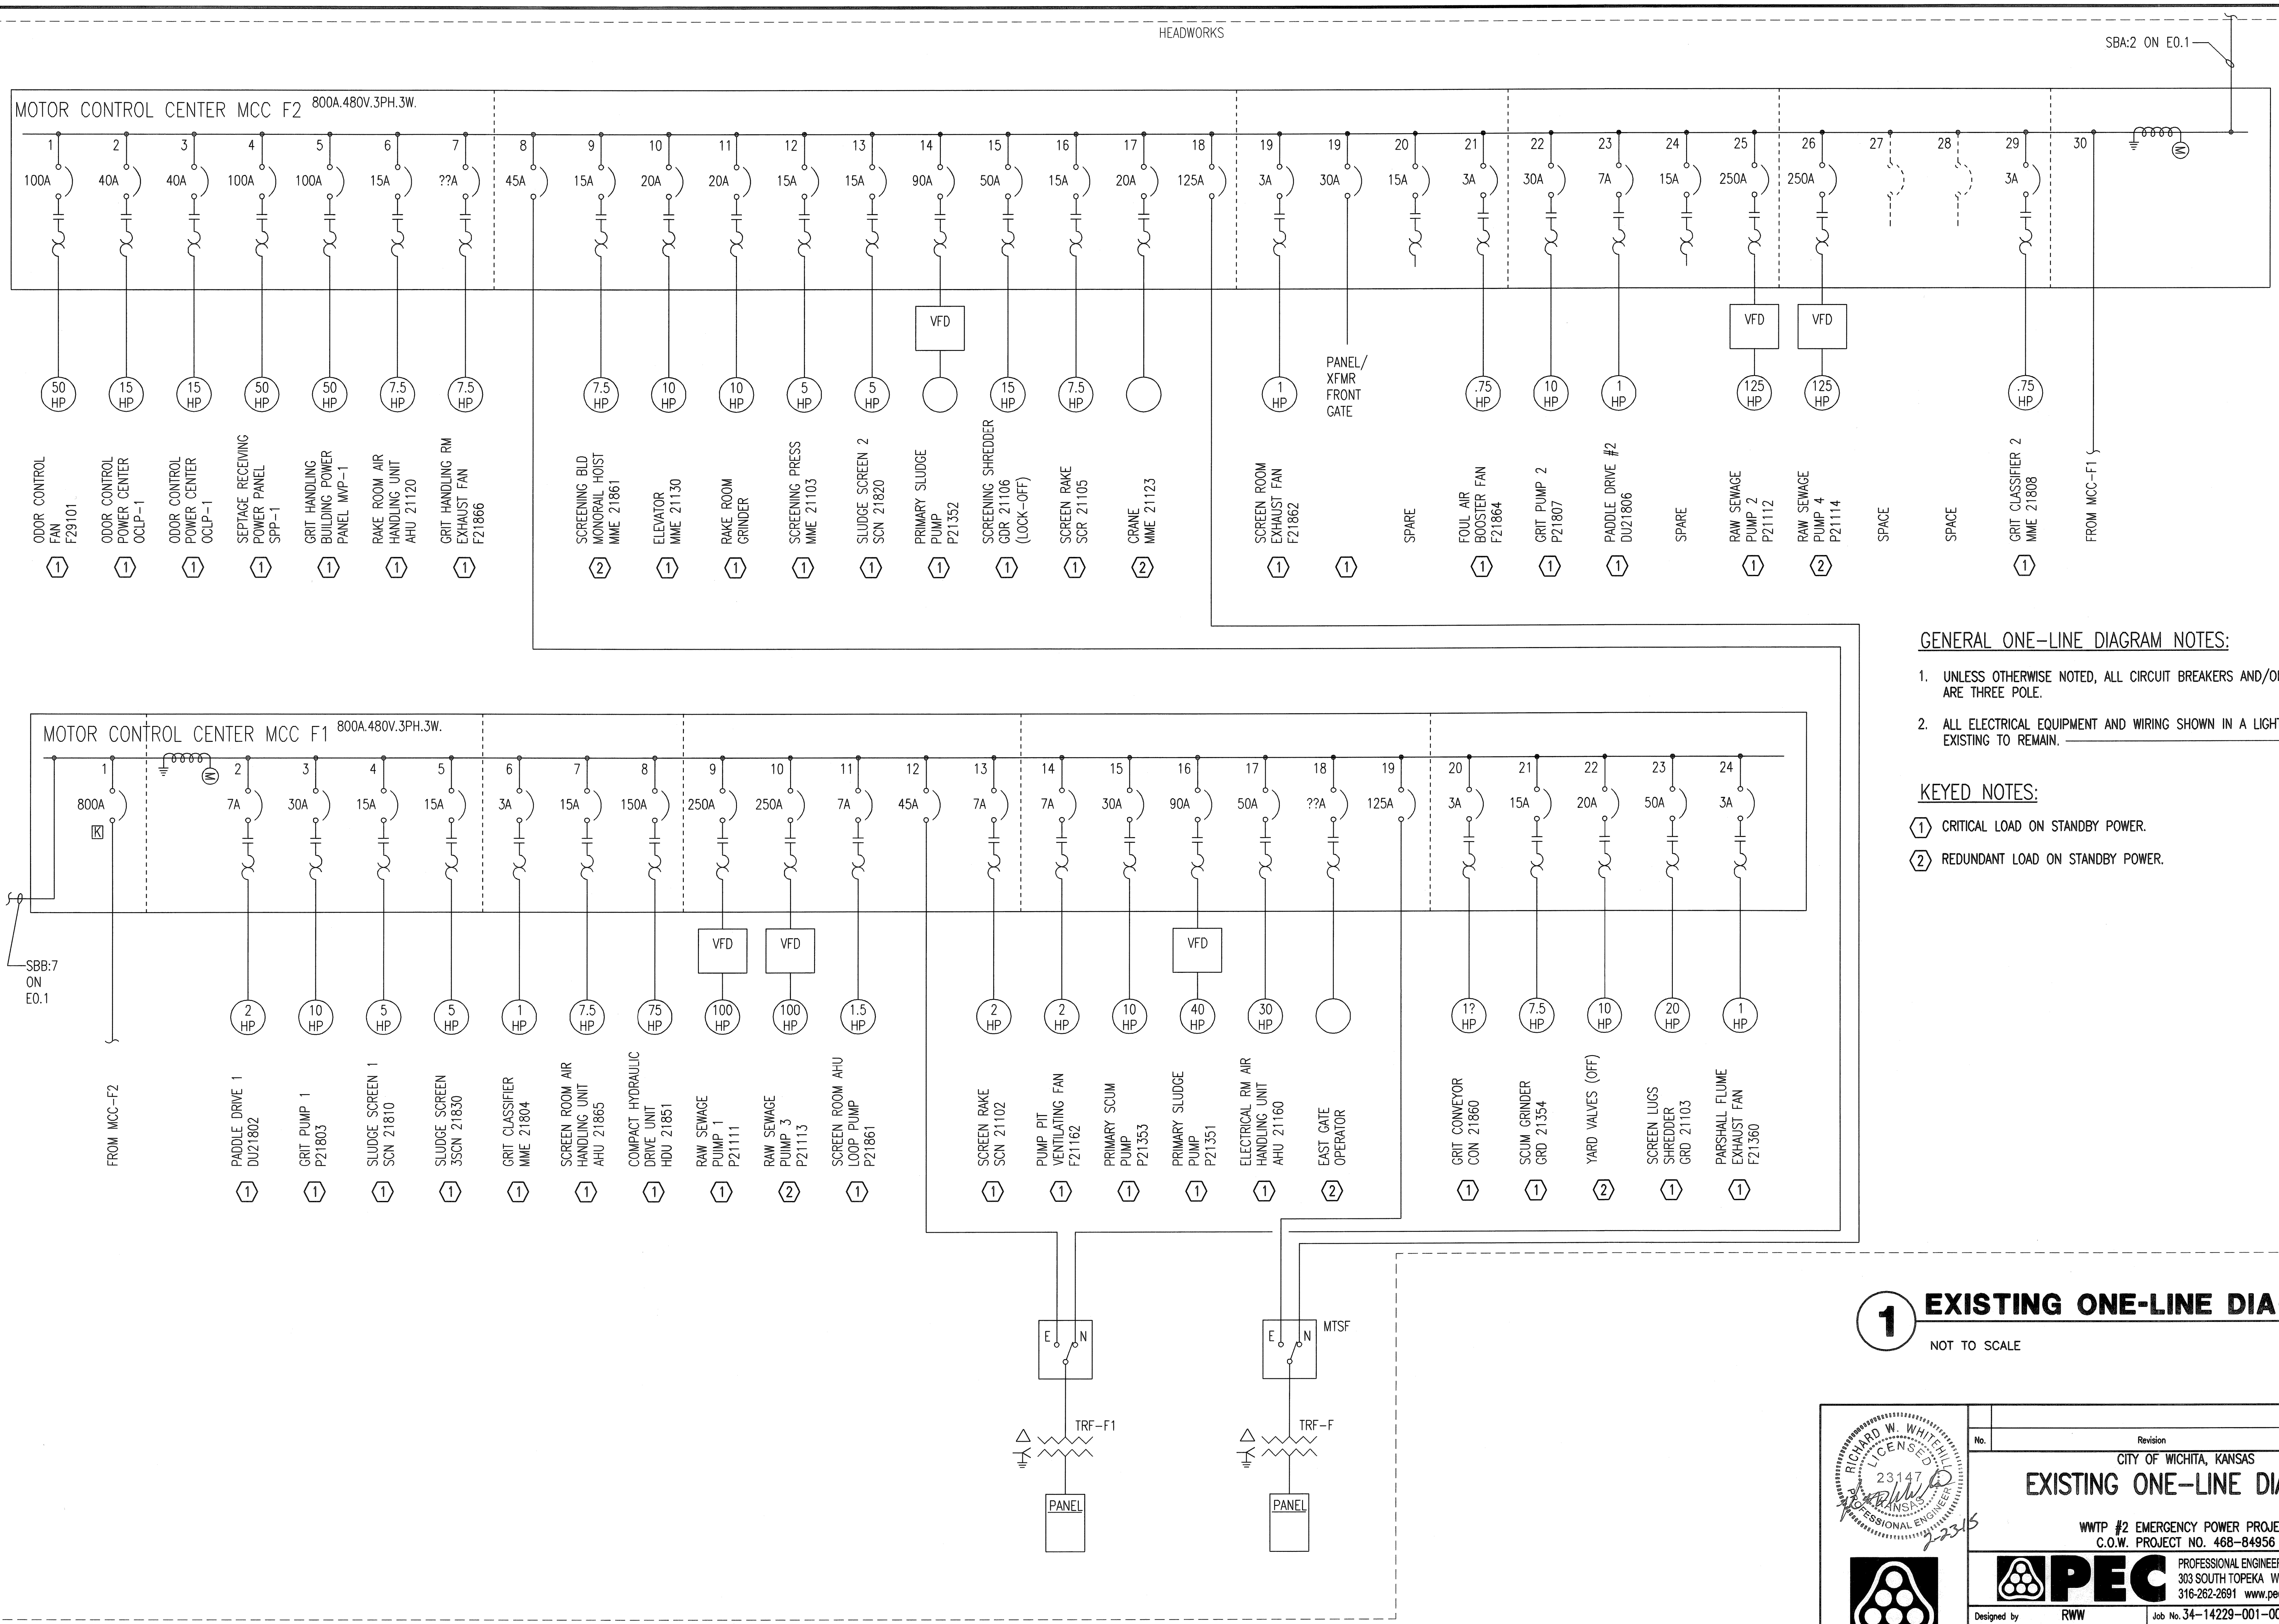

- GENERAL ONE-LINE DIAGRAM NOTES:**
- UNLESS OTHERWISE NOTED, ALL CIRCUIT BREAKERS AND/OR SWITCHES ARE THREE POLE.
  - ALL ELECTRICAL EQUIPMENT AND WIRING SHOWN IN A LIGHT LINE, IS EXISTING TO REMAIN.

- KEYED NOTES:**
- ① CRITICAL LOAD ON STANDBY POWER.
  - ② REDUNDANT LOAD ON STANDBY POWER.

**1 EXISTING ONE-LINE DIAGRAM**  
 NOT TO SCALE

	Revision		By	Date
	CITY OF WICHITA, KANSAS <b>EXISTING ONE-LINE DIAGRAM</b>			
	WWTP #2 EMERGENCY POWER PROJECT C.O.W. PROJECT NO. 468-84956			
	IPEC PROFESSIONAL ENGINEERING CONSULTANTS, P.A. 303 SOUTH TOPEKA WICHITA, KS 67202 316-262-2691 www.pec1.com			
Designed by	RWW	Job No.	34-14229-001-0042	Sht. E0.4 of 36
Drawn by	CJV	Date	2/23/15	