


Sheet 01-31-2015 12:33:19 PM by CJV
 Plot Scale 1:1 02-24-2015 04:49 AM by CHRIS VAIL
 U:\Wichita-Facility\2014\14229\001\Elec\Drawings\EO.8 EXISTING ONE-LINE DIAGRAM

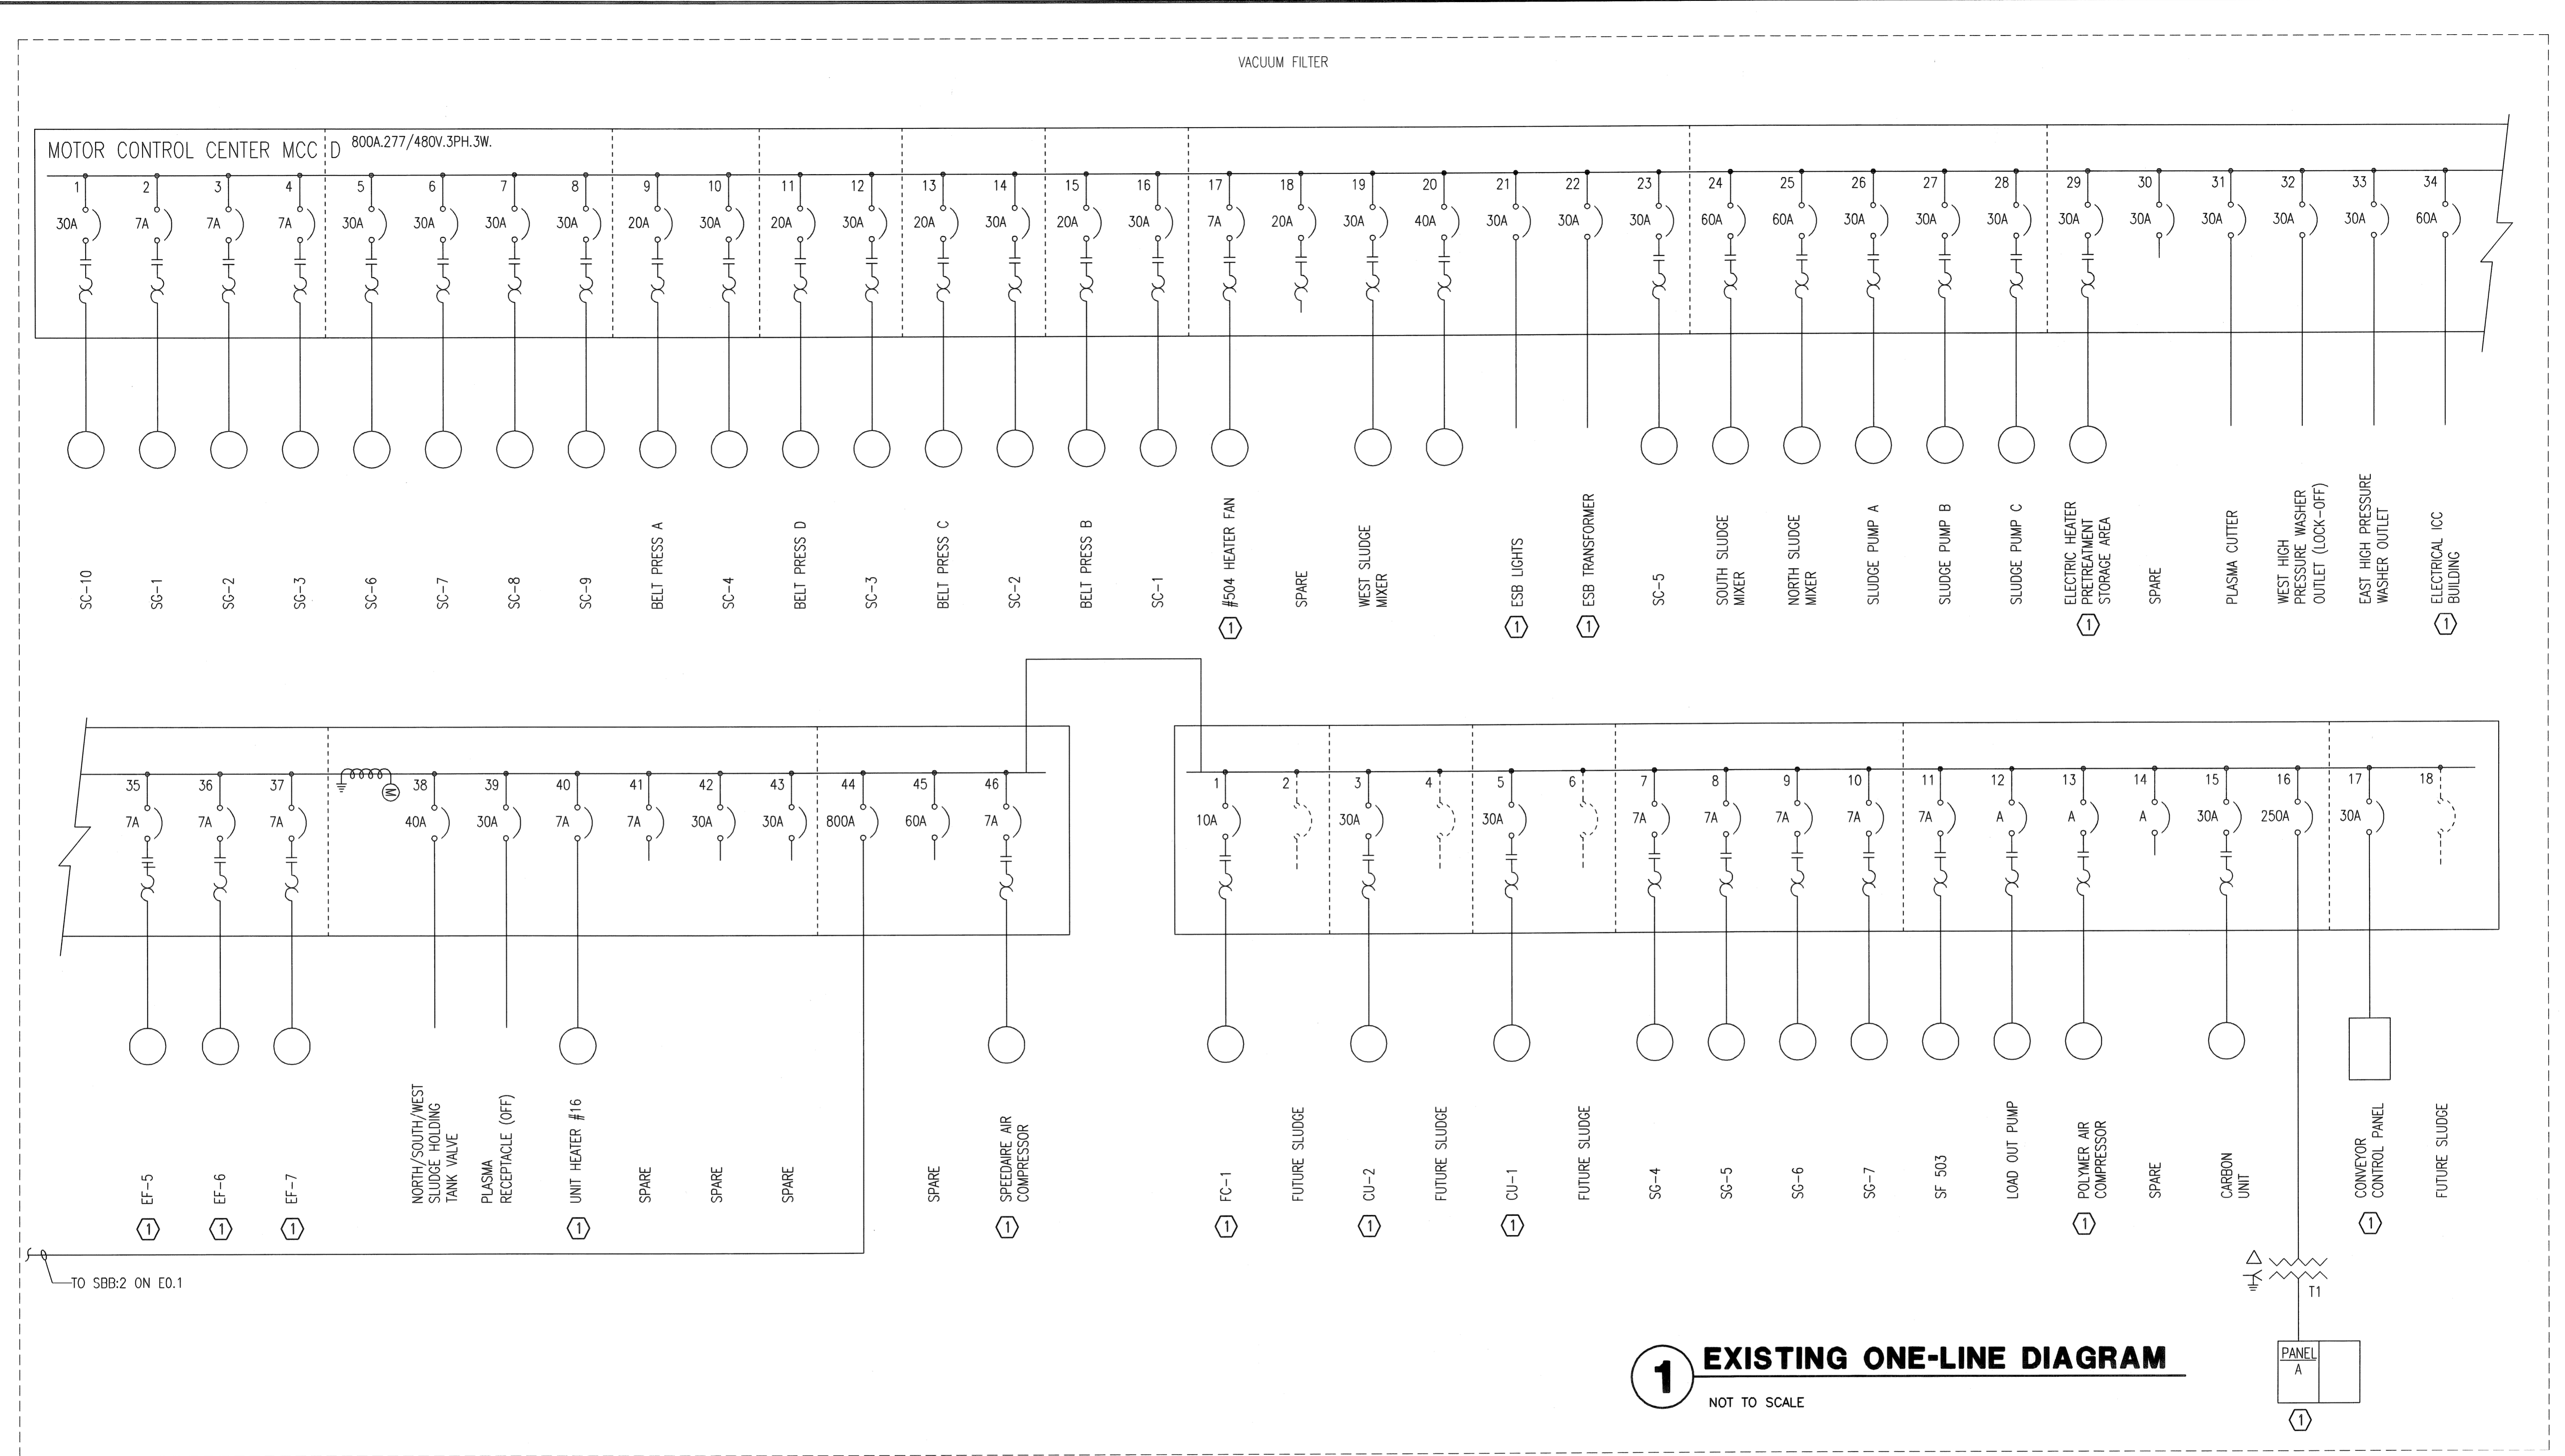

1 EXISTING ONE-LINE DIAGRAM
NOT TO SCALE

- GENERAL ONE-LINE DIAGRAM NOTES:**
- UNLESS OTHERWISE NOTED, ALL CIRCUIT BREAKERS AND/OR SWITCHES ARE THREE POLE.
 - ALL ELECTRICAL EQUIPMENT AND WIRING SHOWN IN A LIGHT LINE, IS EXISTING TO REMAIN.
- KEYED NOTES:**
- CRITICAL LOAD ON STANDBY POWER.

	Revision		By	Date
	CITY OF WICHITA, KANSAS			
	EXISTING ONE-LINE DIAGRAM			
	WWTP #2 EMERGENCY POWER PROJECT C.O.W. PROJECT NO. 468-84956			
		PROFESSIONAL ENGINEERING CONSULTANTS, P.A. 303 SOUTH TOPEKA WICHITA, KS 67202 316-262-2691 www.pec1.com		
		Designed by RWW Drawn by CJV	Job No. 34-14229-001-0042 Date 2/23/15	Sht. E0.8 of 36