


GENERAL ONE-LINE DIAGRAM NOTES:

1. UNLESS OTHERWISE NOTED, ALL CIRCUIT BREAKERS AND/OR SWITCHES ARE THREE POLE.
2. ALL ELECTRICAL EQUIPMENT AND WIRING SHOWN IN A LIGHT LINE, IS EXISTING TO REMAIN.

KEYED NOTES:

- ① CRITICAL LOAD ON STANDBY POWER.

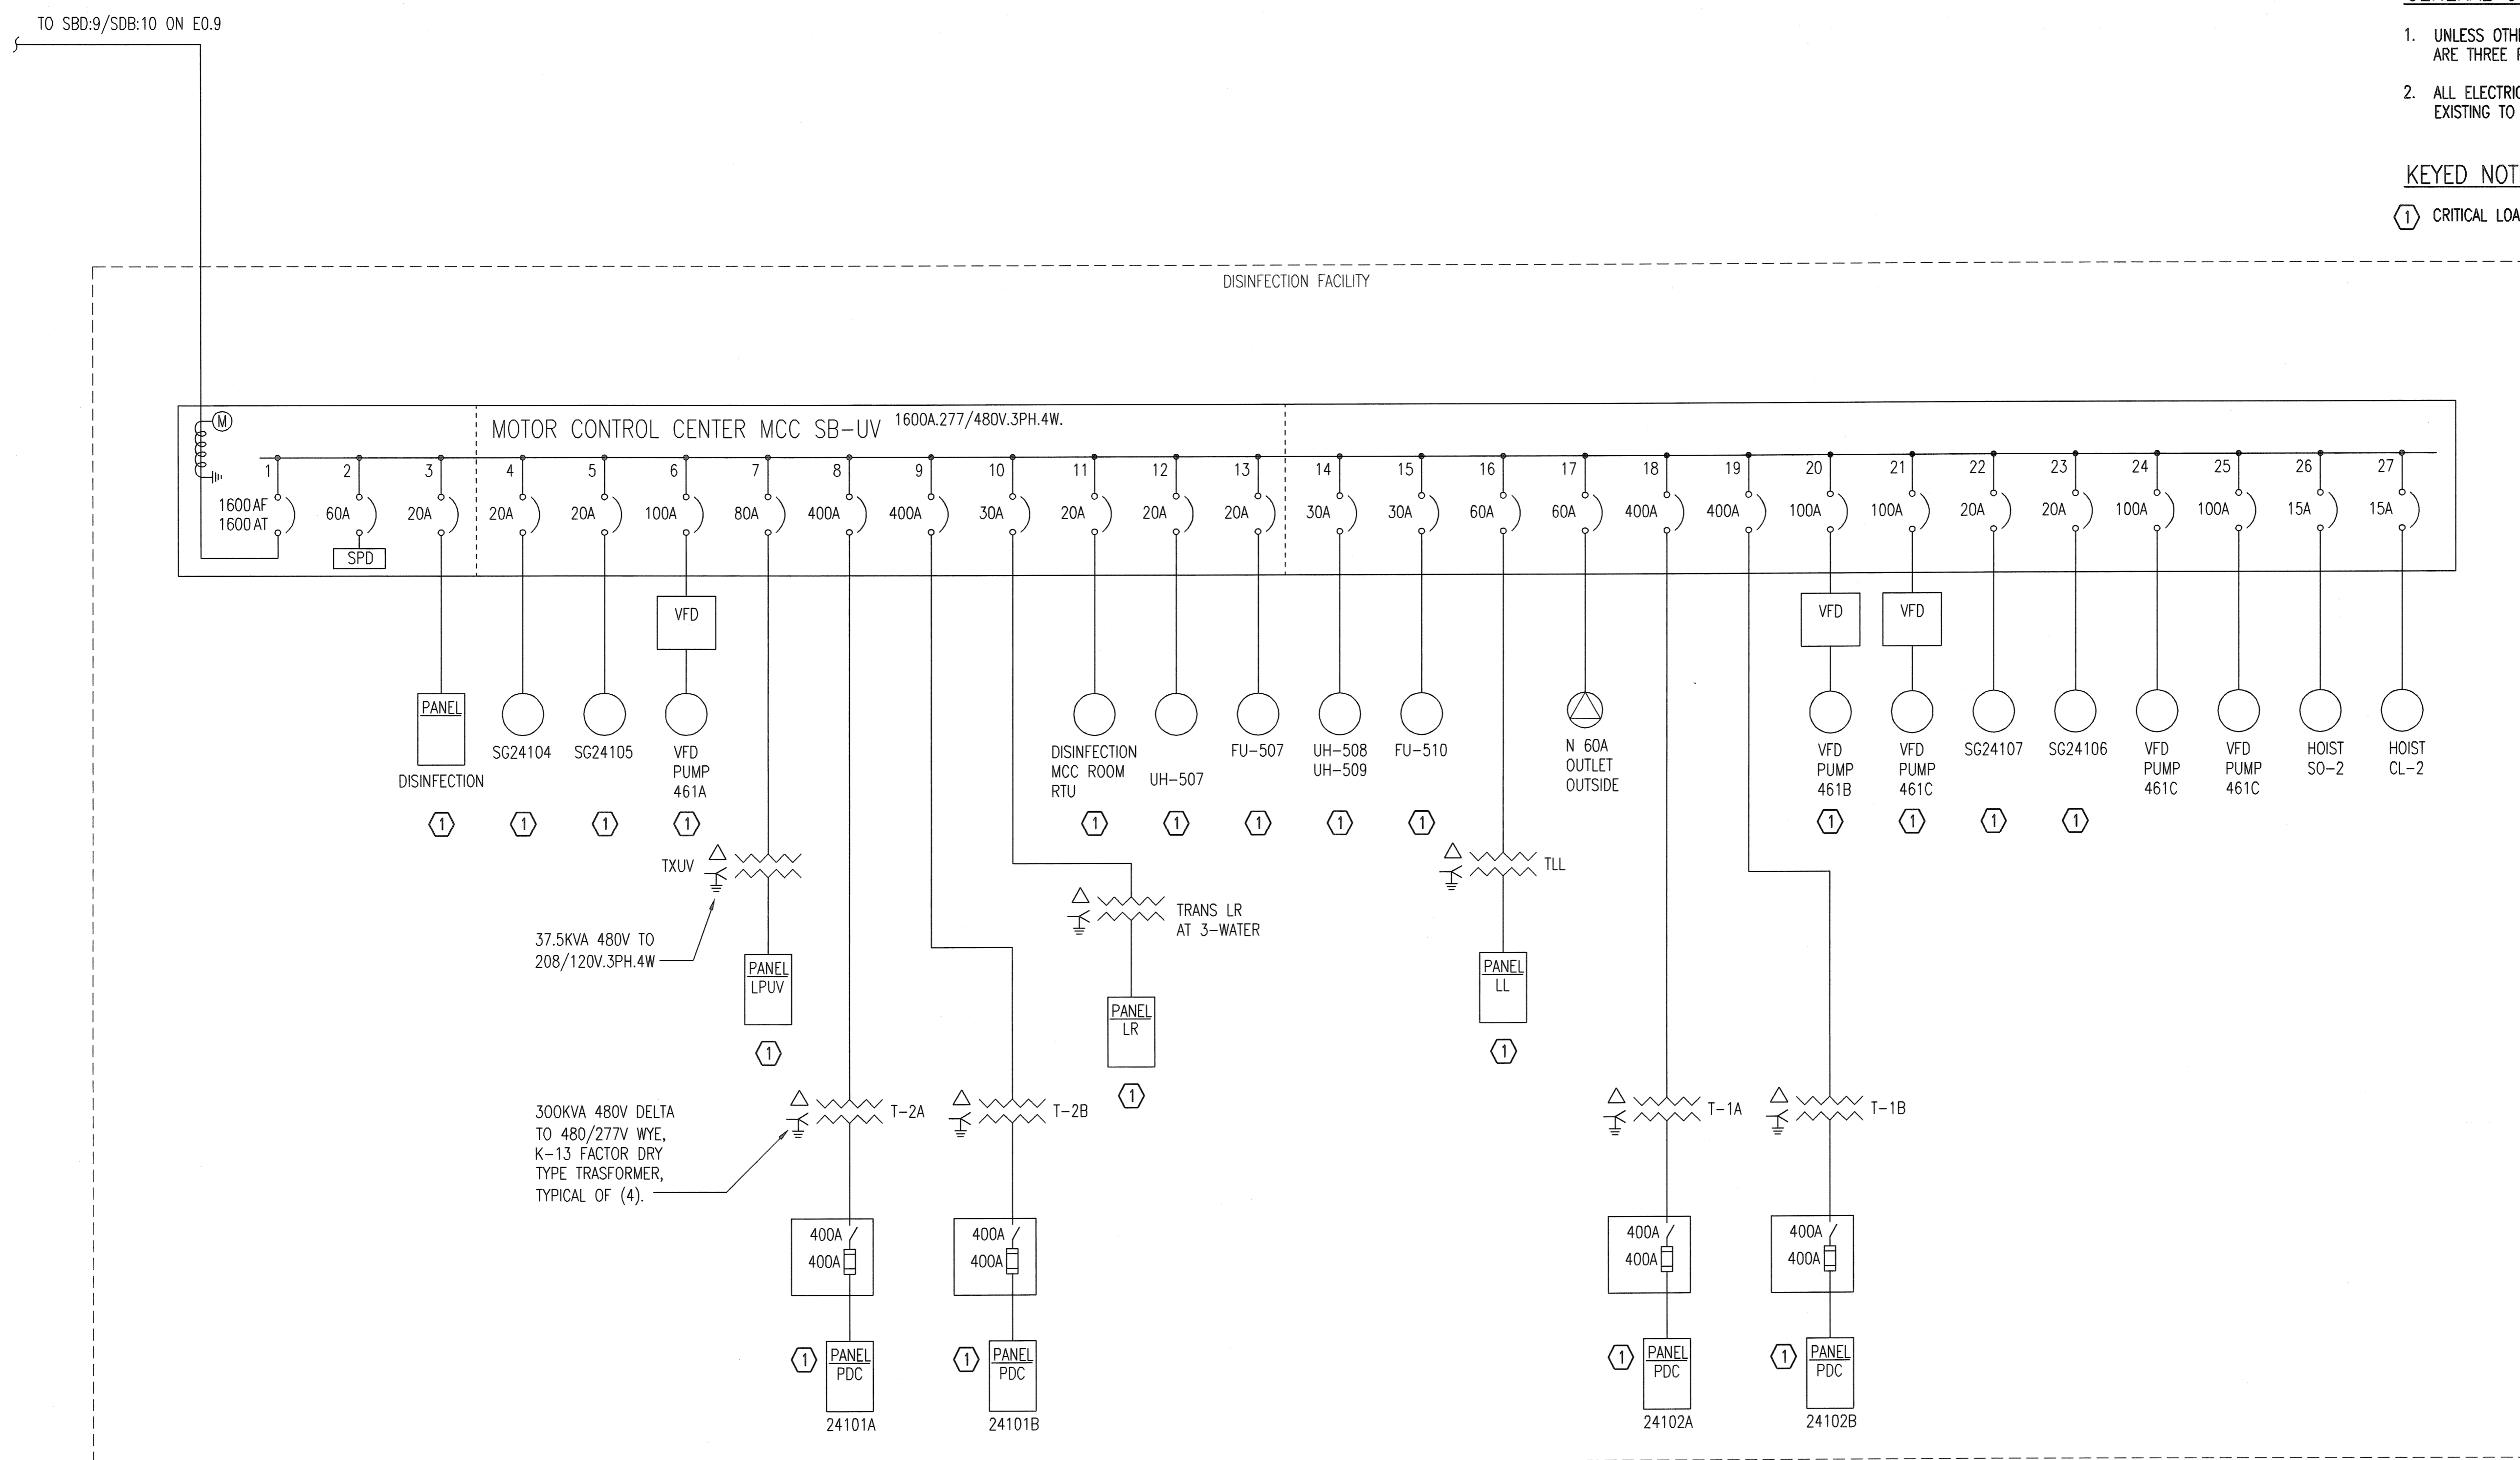

1 EXISTING ONE-LINE DIAGRAM
NOT TO SCALE

Saved: 01-31-2015 12:33:46 PM by: CW
 U:\Wichita-Facility\2014-14229-001\Drawings\14229-001-E0.10 PLANT 2 ONE-LINE DIAGRAM

	Revision		By	Date
	CITY OF WICHITA, KANSAS EXISTING ONE-LINE DIAGRAM			
	WWTP #2 EMERGENCY POWER PROJECT C.O.W. PROJECT NO. 468-84956			
	PROFESSIONAL ENGINEERING CONSULTANTS, P.A. 303 SOUTH TOPEKA WICHITA, KS 67202 316-262-2691 www.pec1.com			
Designed by	RWW	Job No. 34-14229-001-0042	Sht. E0.10 of 36	
Drawn by	CJV	Date	2/23/15	