
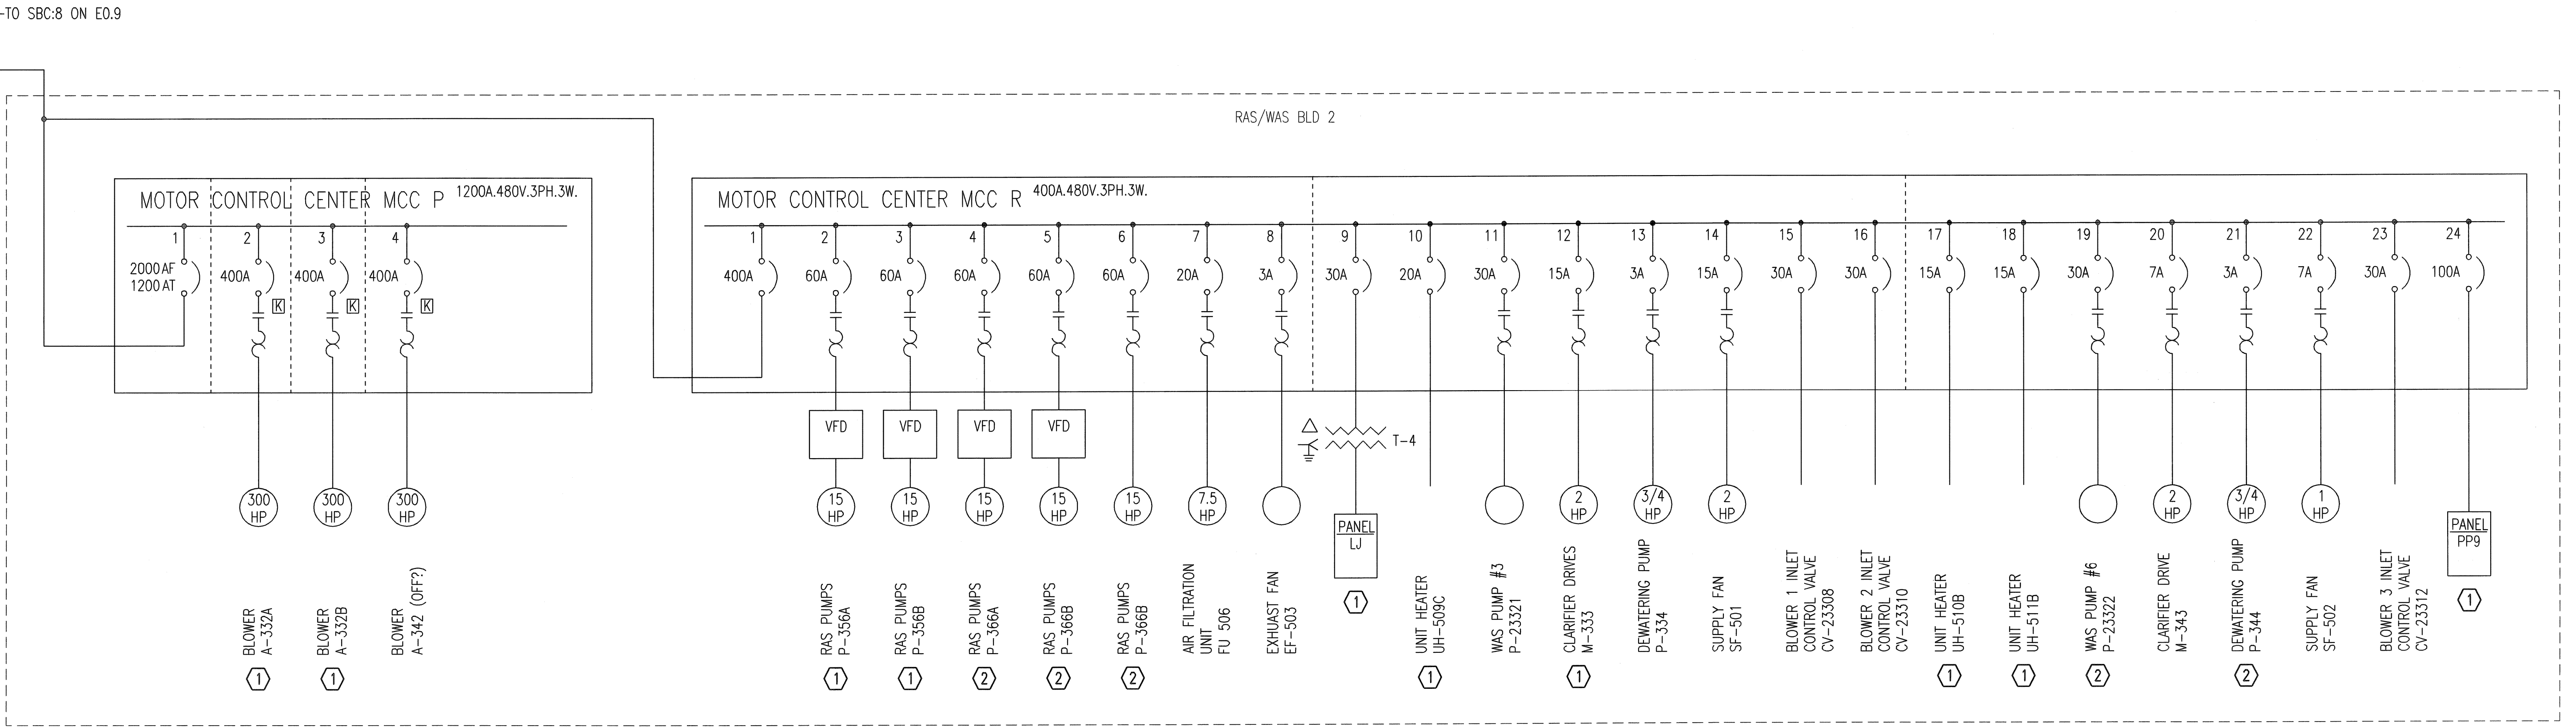


Saved: 01-31-2015 12:33:59 PM by: CJV
 Plot Scale: 1:1 02-24-2015 10:44:34 AM by: CHRIS VALL
 U:\Wichita-Fossil\2014\14229\001\Elec\Drawings\EO.11 EXISTING ONE-LINE DIAGRAM

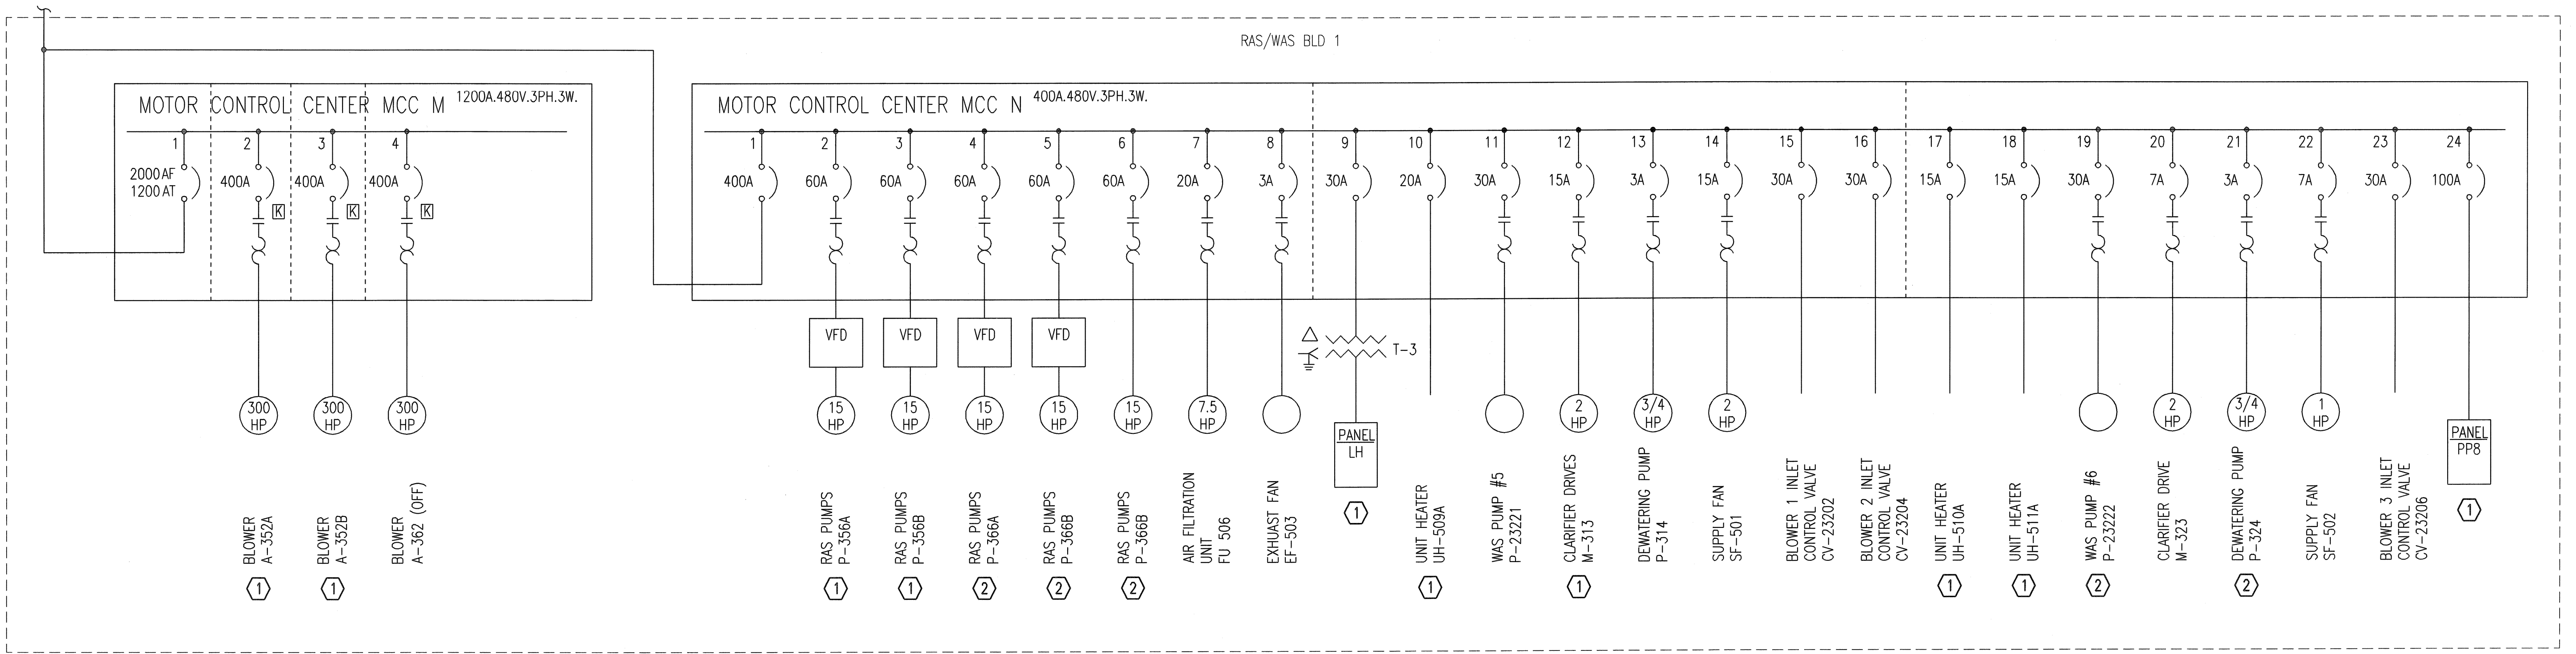

GENERAL ONE-LINE DIAGRAM NOTES:

- UNLESS OTHERWISE NOTED, ALL CIRCUIT BREAKERS AND/OR SWITCHES ARE THREE POLE.
- ALL ELECTRICAL EQUIPMENT AND WIRING SHOWN IN A LIGHT LINE, IS EXISTING TO REMAIN.

KEYED NOTES:

- ① CRITICAL LOAD ON STANDBY POWER.
- ② REDUNDANT LOAD ON STANDBY POWER.

1 EXISTING ONE-LINE DIAGRAM
NOT TO SCALE

	Revision By _____ Date _____
CITY OF WICHITA, KANSAS EXISTING ONE-LINE DIAGRAM	
WWT# #2 EMERGENCY POWER PROJECT C.O.W. PROJECT NO. 468-84956	
PECC PROFESSIONAL ENGINEERING CONSULTANTS, P.A. 303 SOUTH TOPEKA WICHITA, KS 67202 316-262-2691 www.pecc.com	
Designed by RWW Drawn by CJV	Job No. 34-14229-001-0042 Date 2/23/15 Sht. EO.11 of 36