



FOUNDATION PLAN 2/S1.1
COVER PLAN 3/S1.1

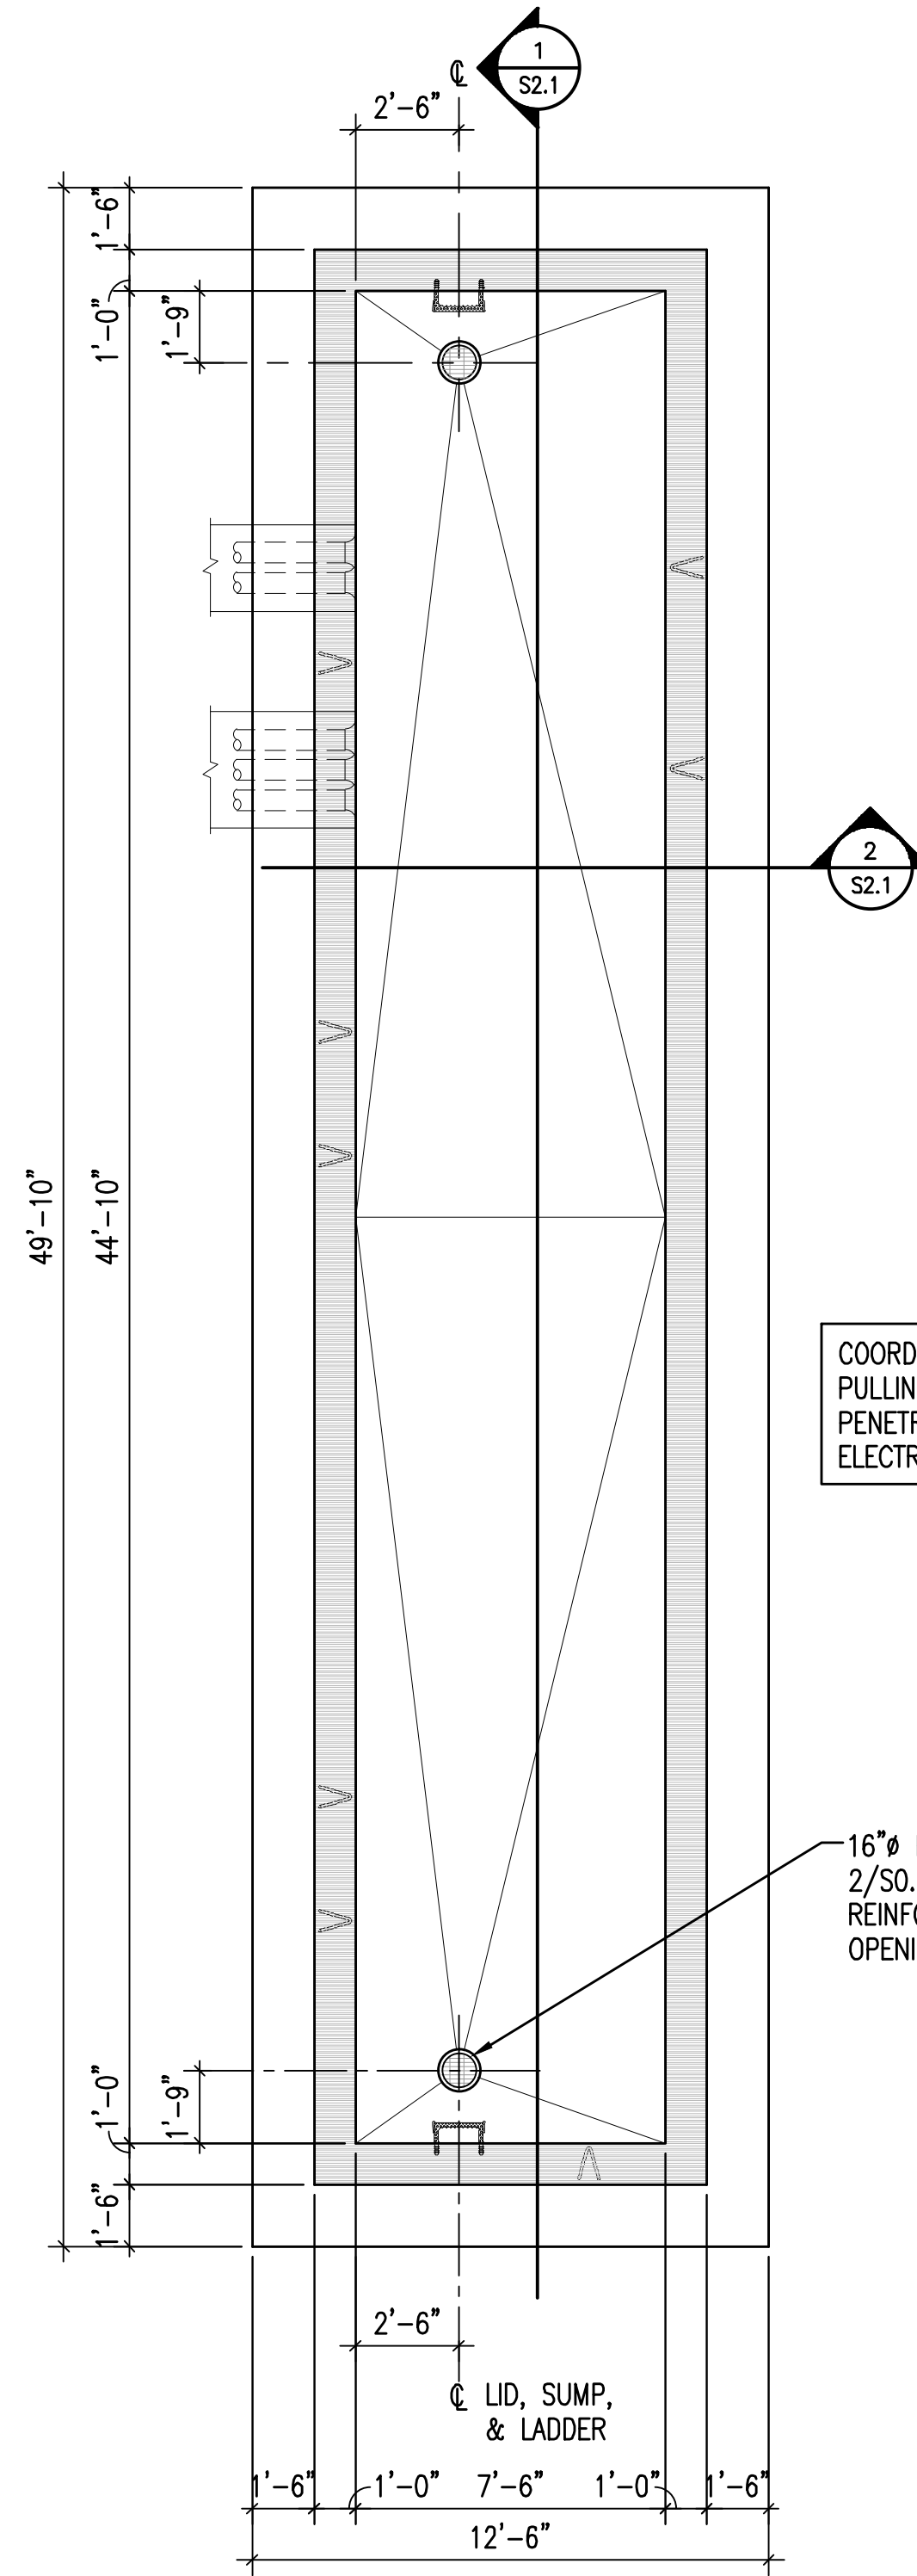

COORDINATE DUCT BANK,
PULLING IRONS, AND ELECTRICAL
PENETRATION LOCATIONS WITH
ELECTRICAL CONTRACTOR.



16"Ø PLASTIC SUMP, REF.
2/S0.1 FOR ADDITIONAL
REINFORCEMENT AROUND
OPENING

2 VAULT FOUNDATION PLAN
S1.1 1/4"=1'0"

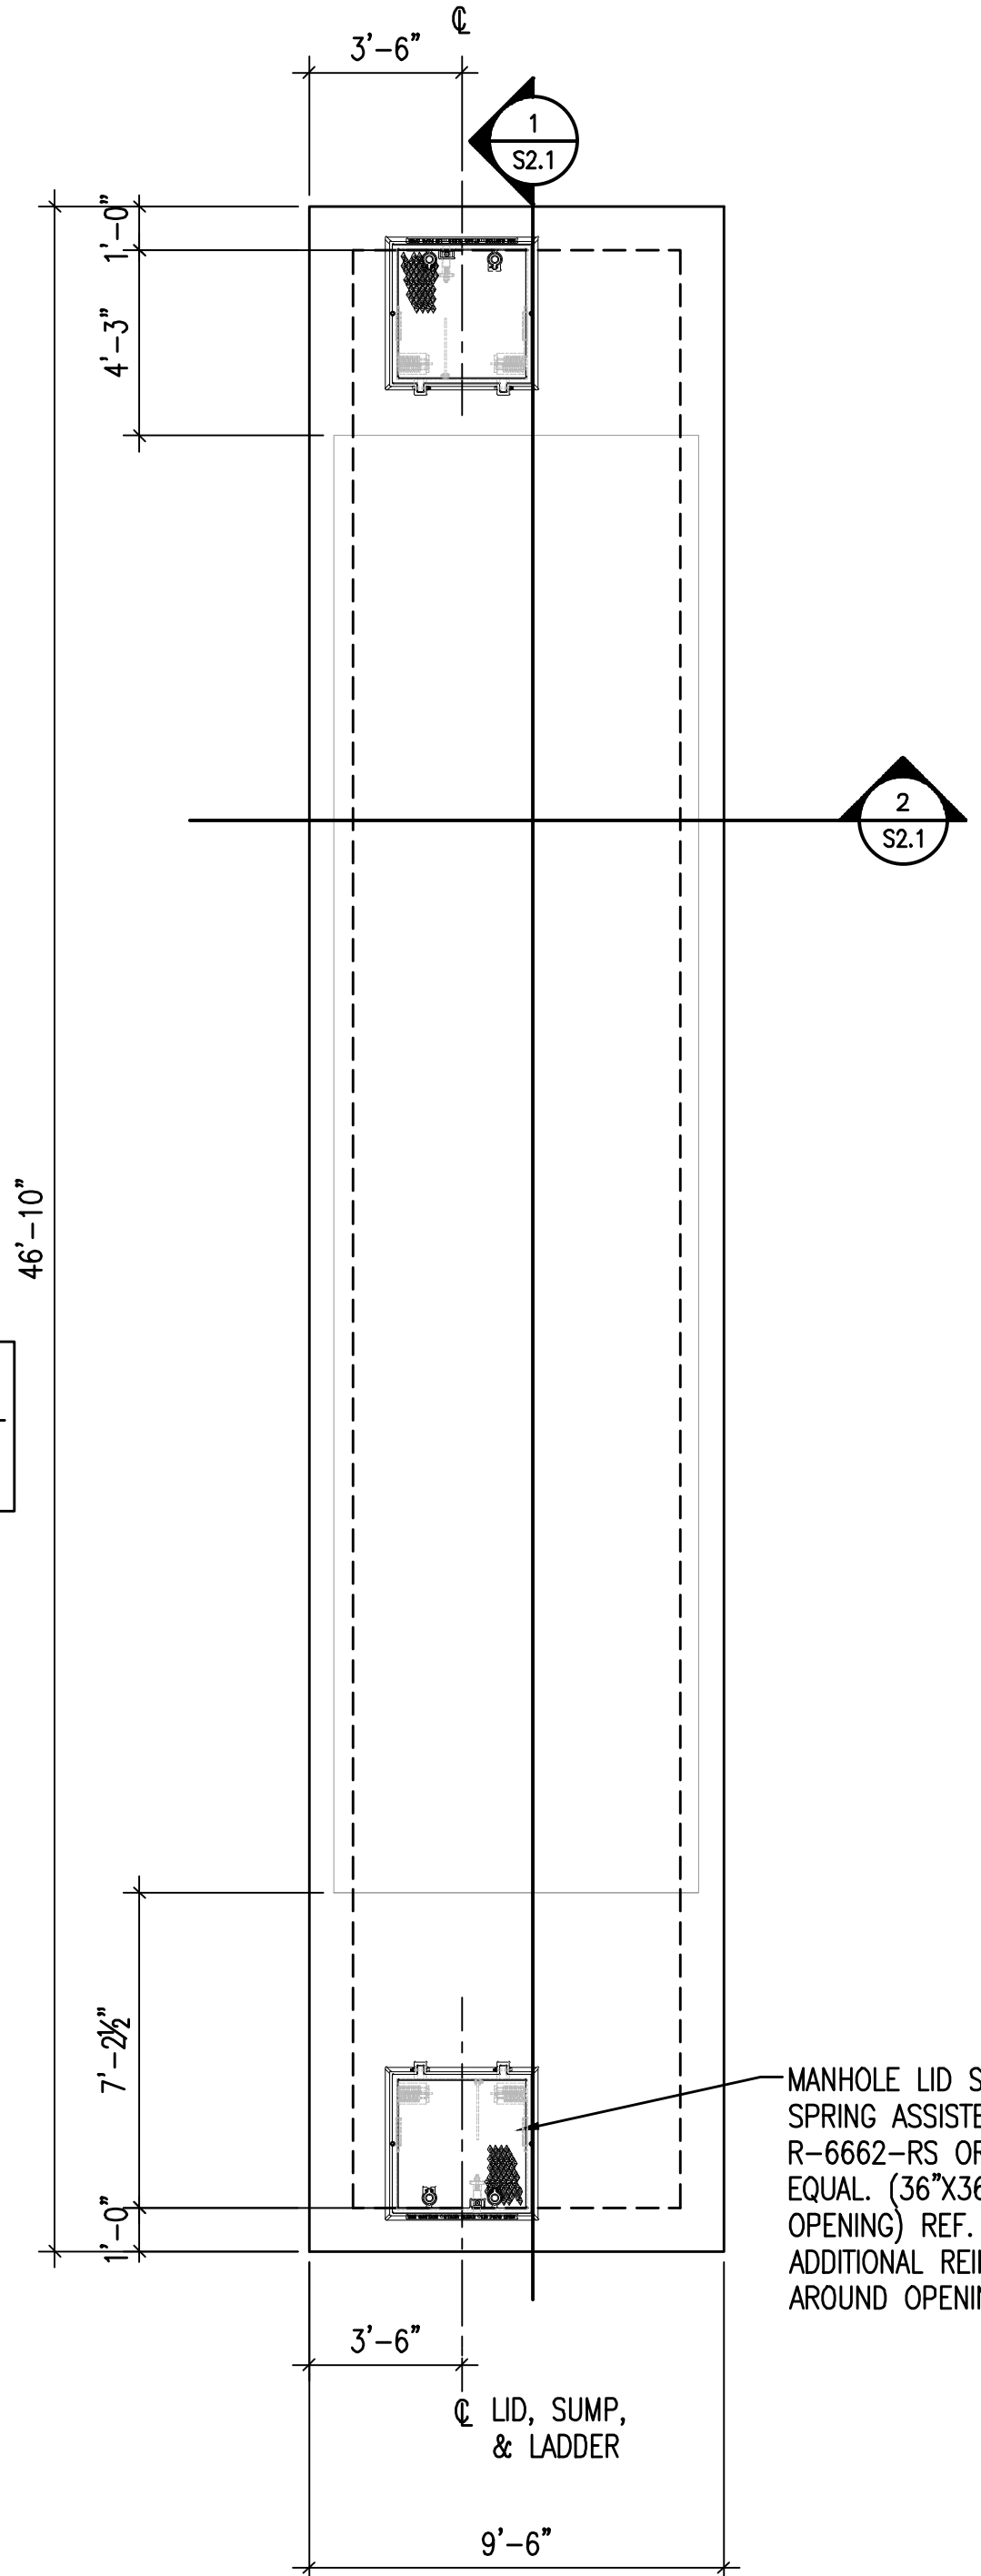


MANHOLE LID SHALL BE
SPRING ASSISTED NEENAH
R-6662-RS OR APPROVED
EQUAL. (36"X36" MIN.
OPENING) REF. 2/S0.1 FOR
ADDITIONAL REINFORCEMENT
AROUND OPENING

3 VAULT COVER PLAN
S1.1 1/4"=1'0"

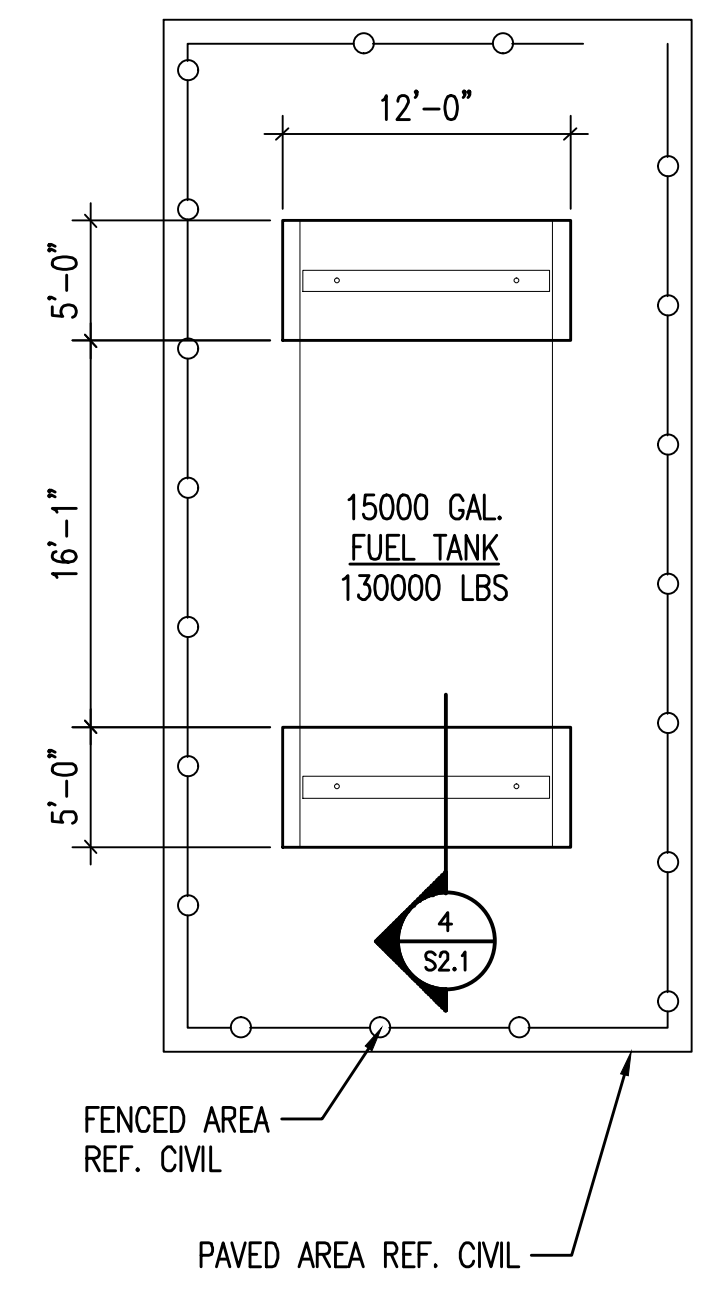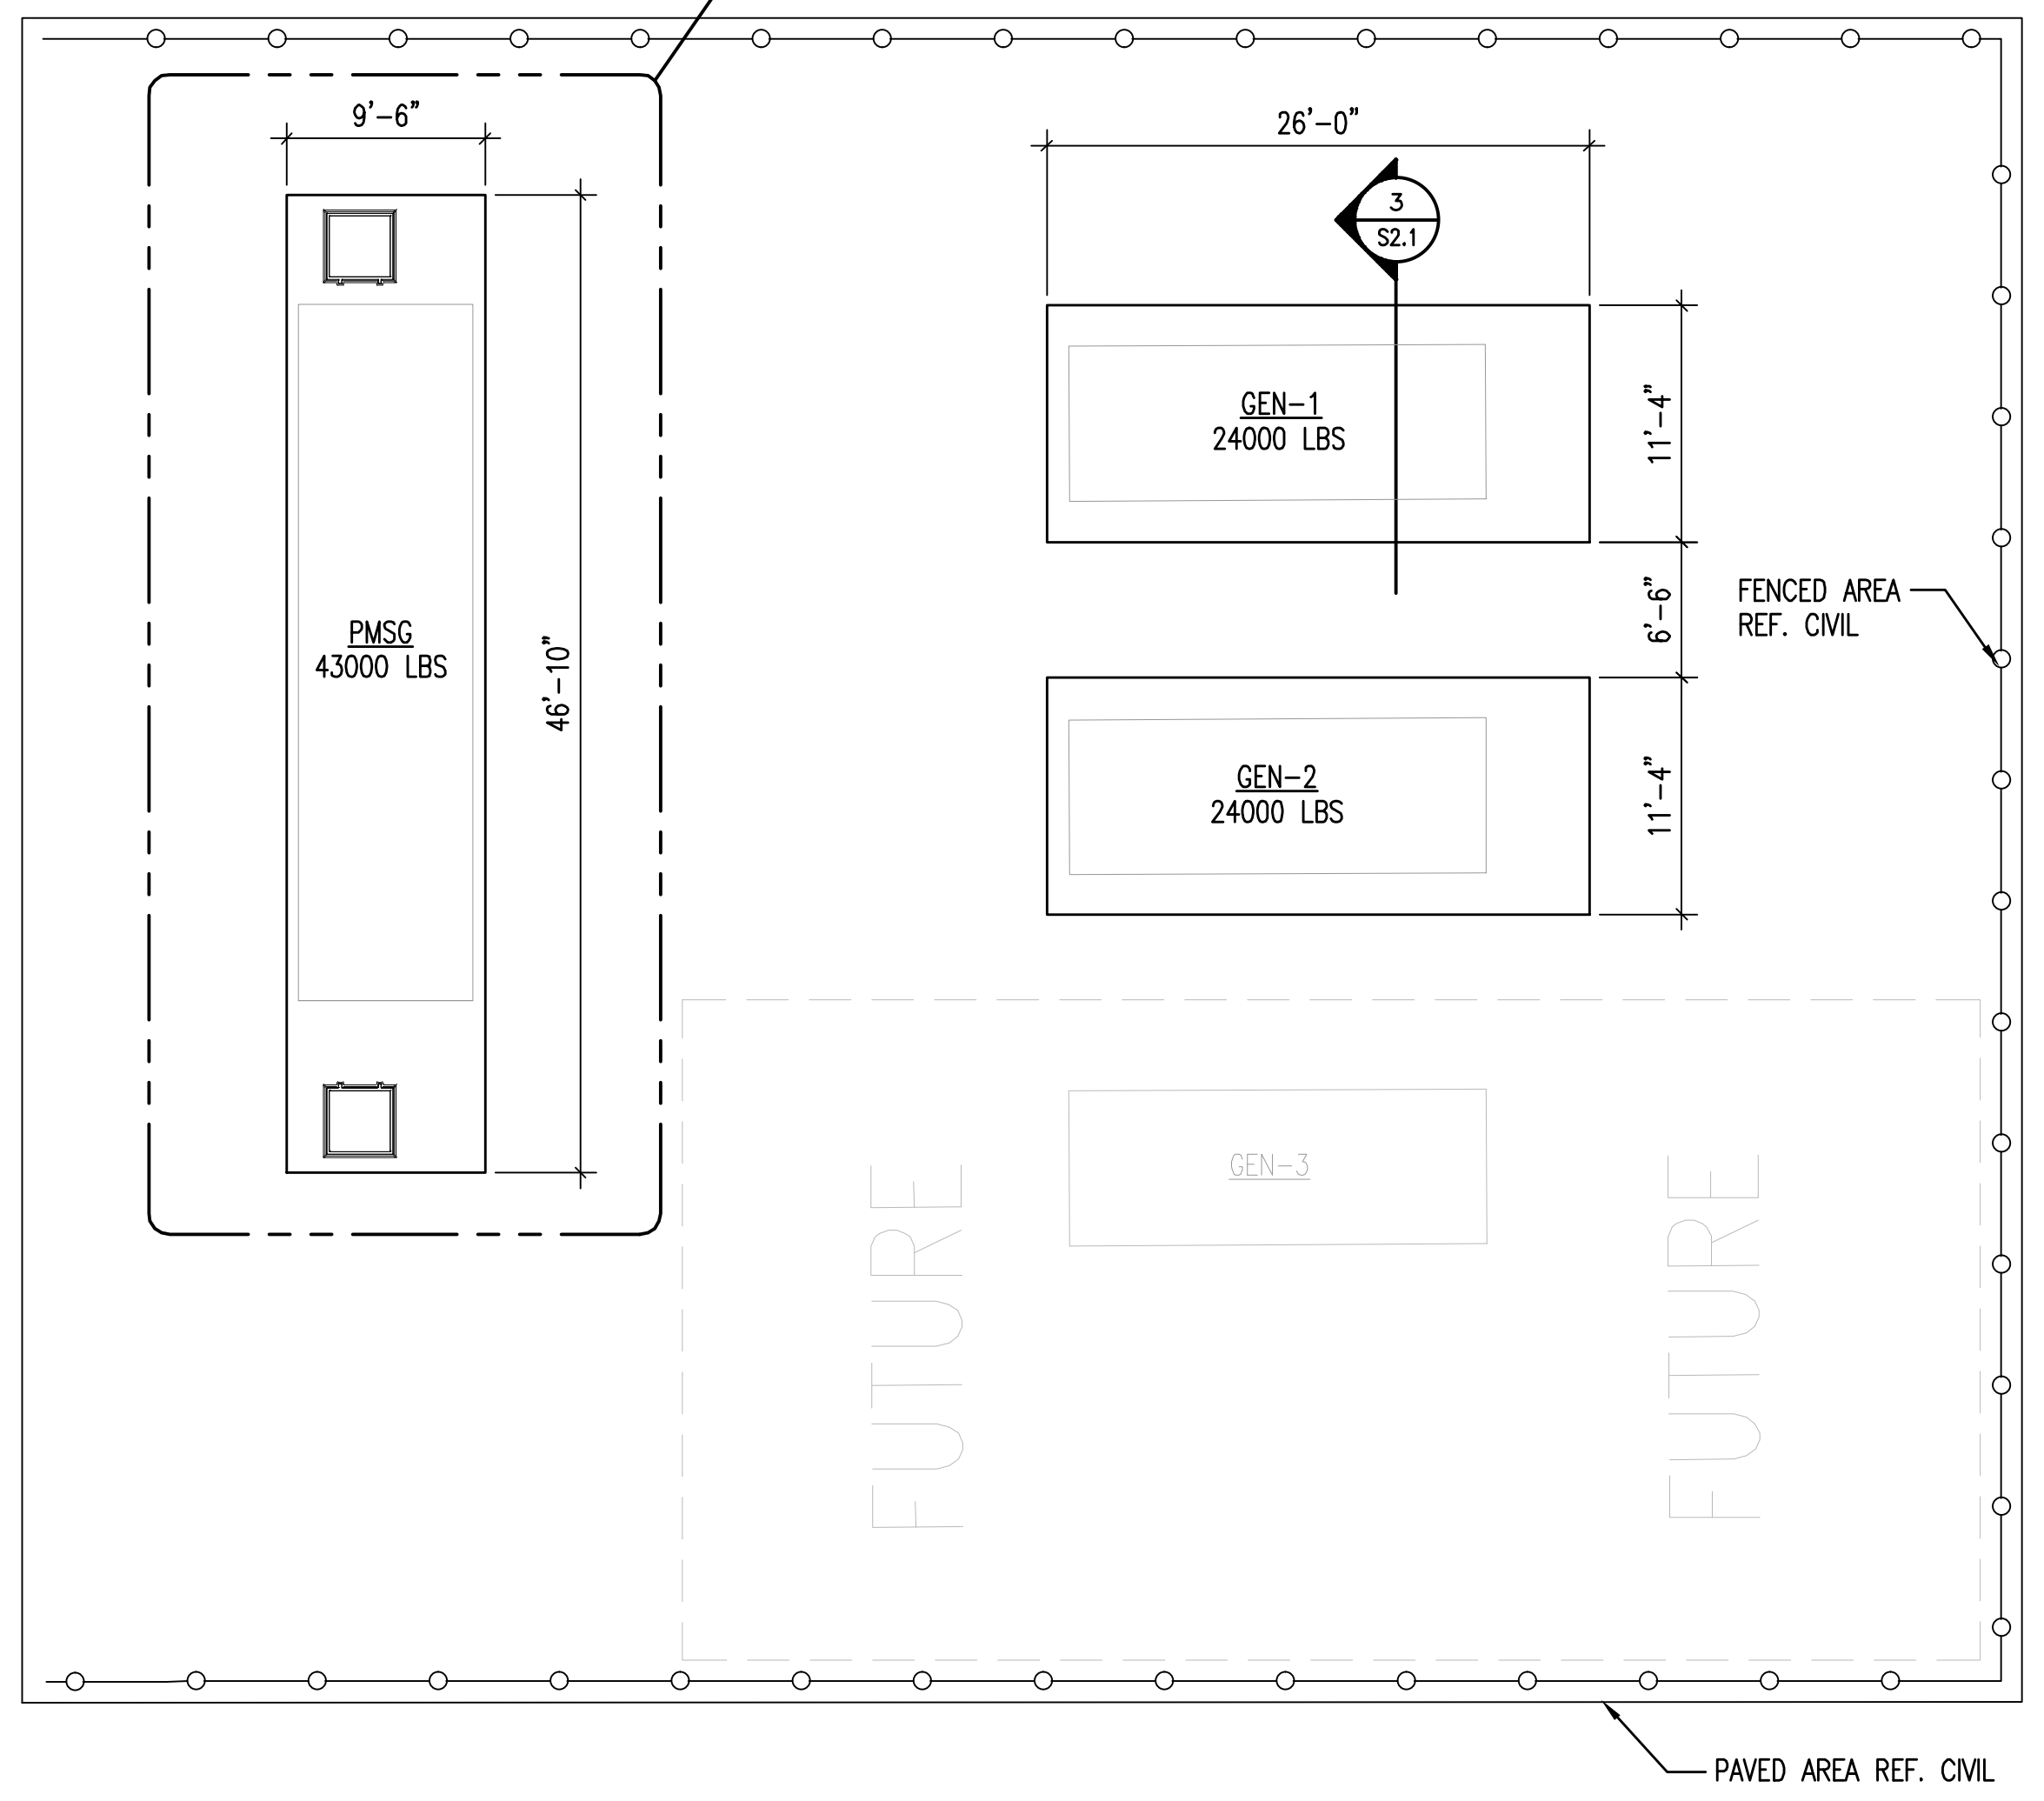

1 EQUIPMENT PLAN
S1.1 1/8"=1'0"

Saved 02-23-2015 2:17:40 PM by DKC
U:\Projects\2015\02\03\Struct\Drawings\03\14229-001_S1.1

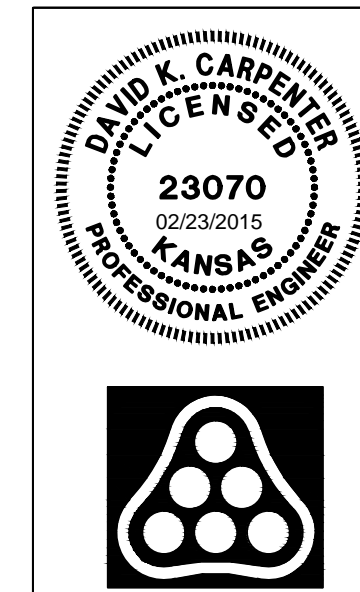

No.	Revision	By	Date
CITY OF WICHITA, KANSAS			
STRUCTURAL PLANS			
WWTP #2 EMERGENCY POWER PROJECT C.O.W. PROJECT NO. 468-84956			
PEC		PROFESSIONAL ENGINEERING CONSULTANTS, P.A. 303 SOUTH TOPEKA WICHITA, KS 67202 316-262-2691 www.pec1.com	
Designed by	DKC	Job No. 34-14229-001-0042	Sht. S1.1 of 36
Drawn by	JTR	Date February 2015	