


Saved 02-23-2015 11:15:59 AM by CAL  
 Plot Scale 12:02:21-2015 12:24:47 AM by DRAK LEWIS  
 C:\Vista\Plot\2015\14229\001\WTP\Drawings\14229-001\_C4\_Site Grading Plan

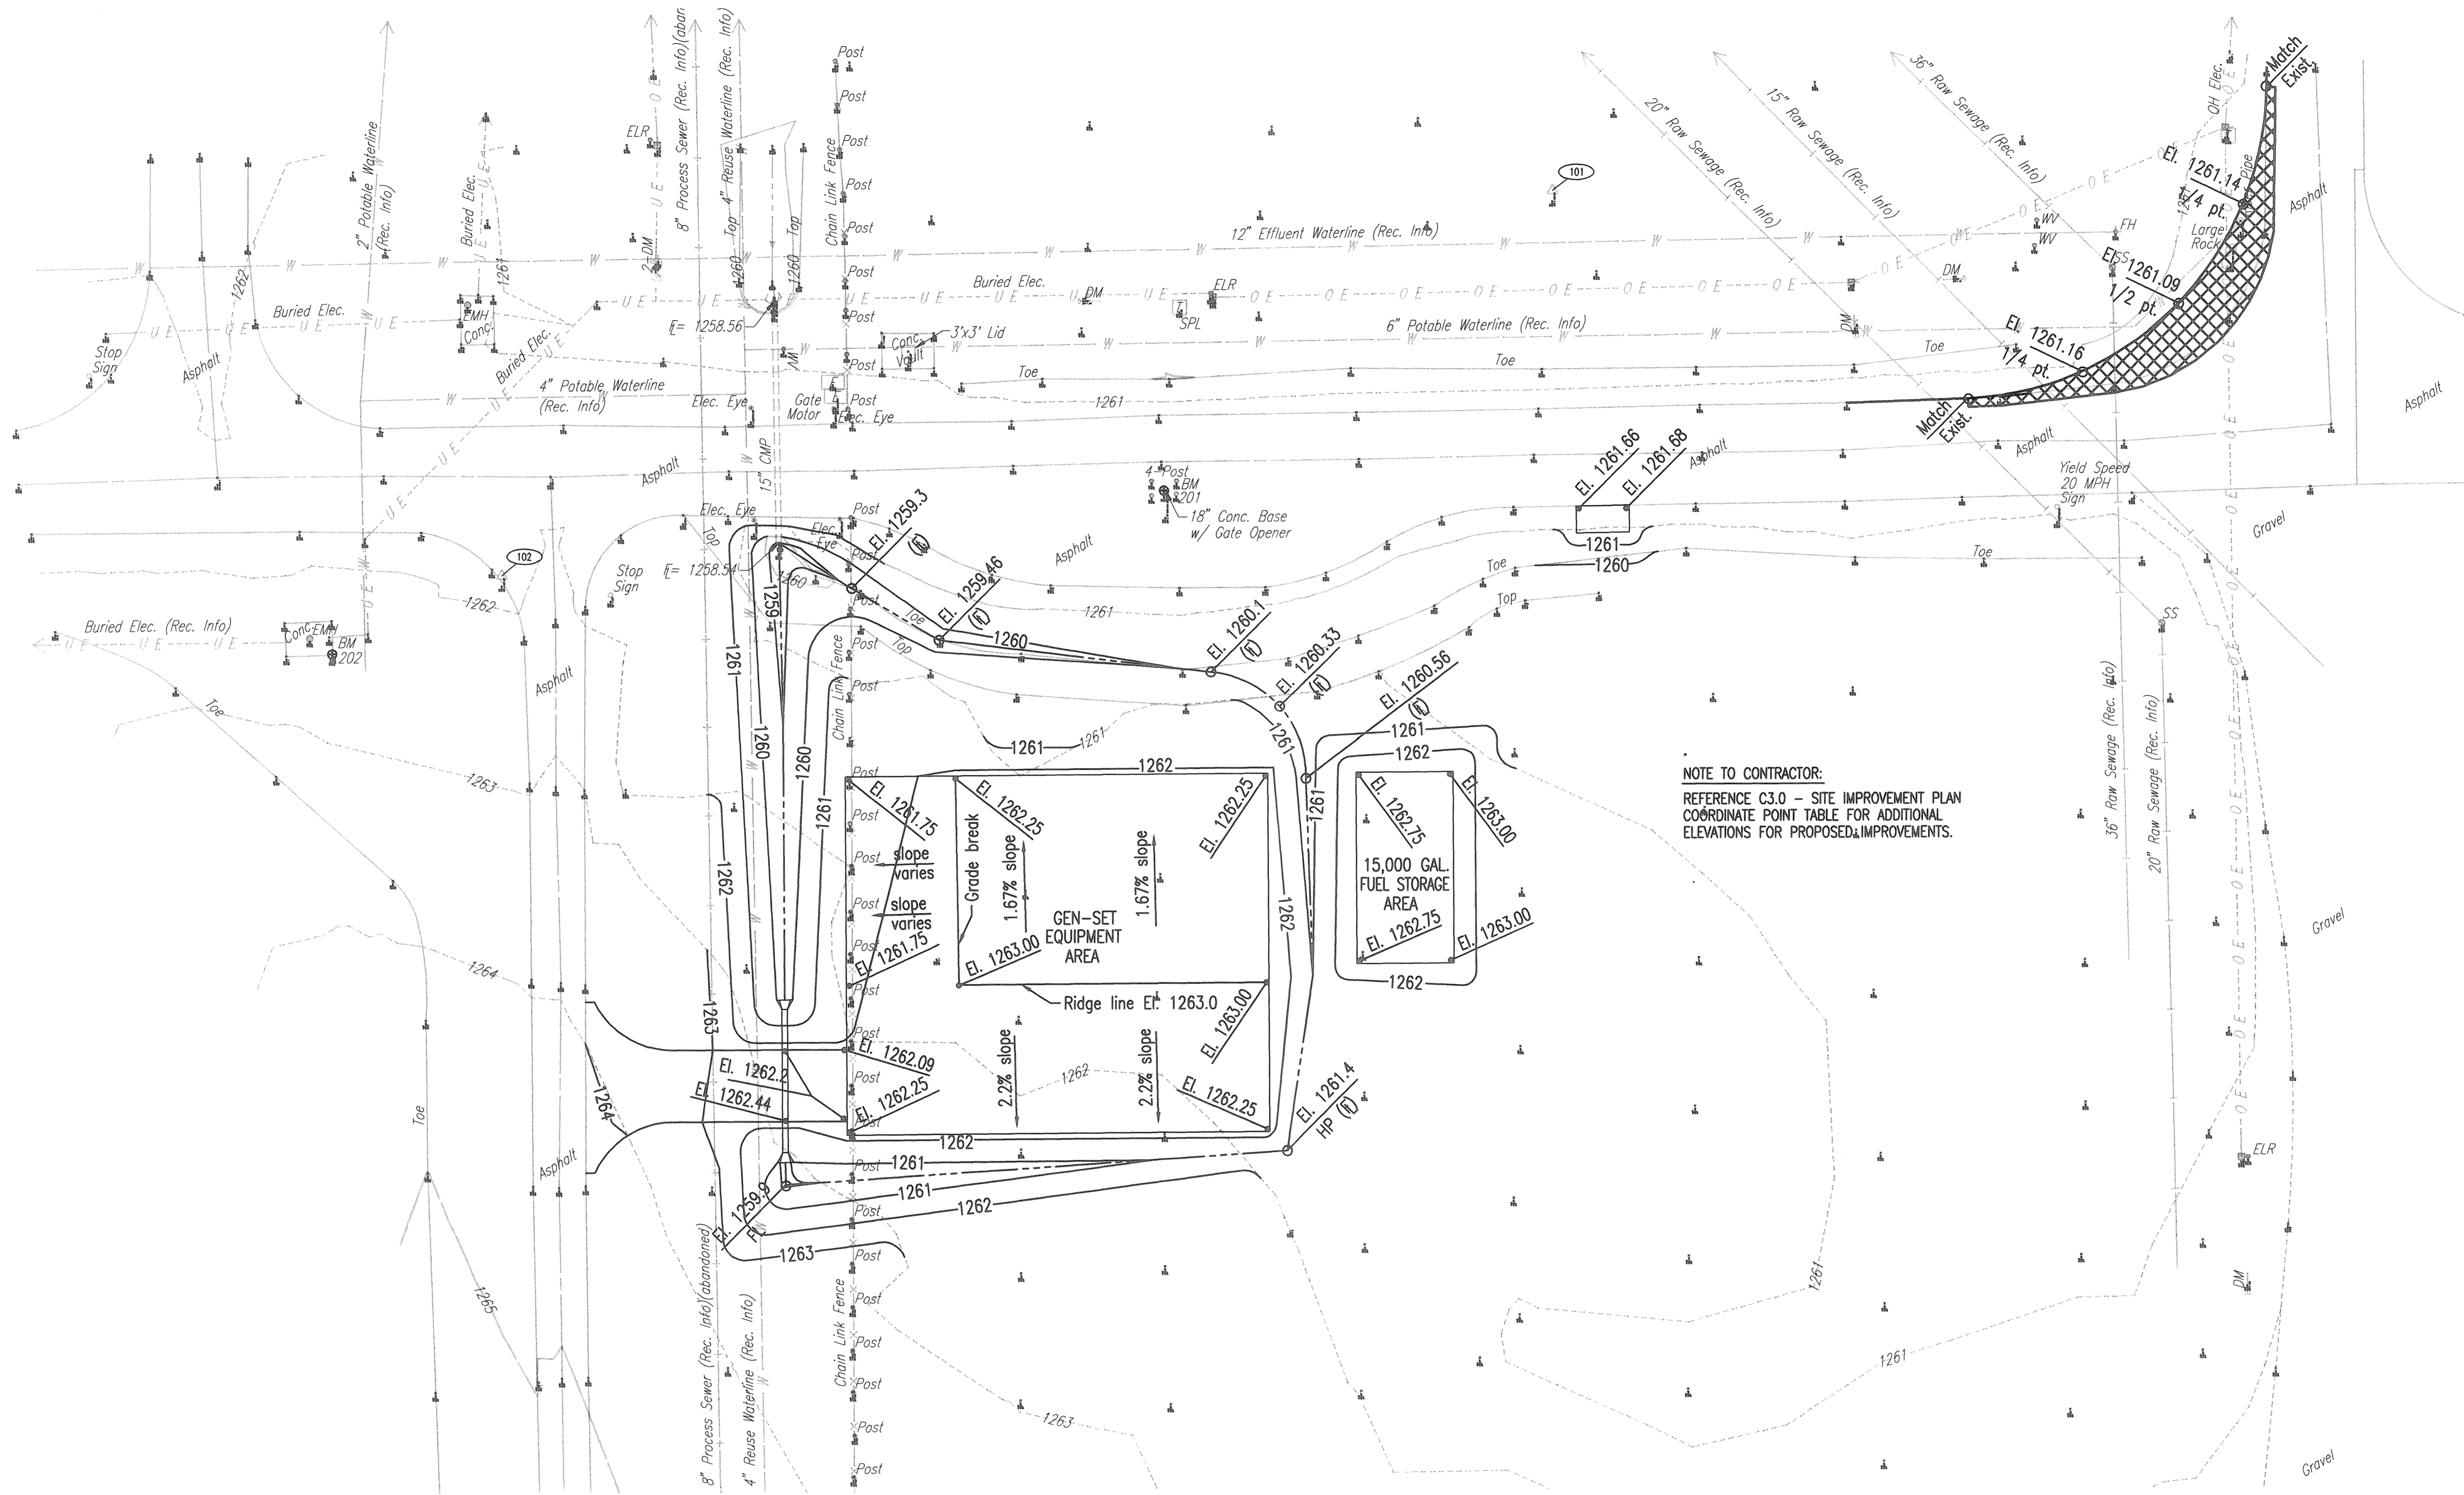

**NOTE TO CONTRACTOR:**  
 REFERENCE C3.0 - SITE IMPROVEMENT PLAN  
 COORDINATE POINT TABLE FOR ADDITIONAL  
 ELEVATIONS FOR PROPOSED IMPROVEMENTS.

**P&E**  
 Scale: 1" = 20'

	Revision		By	Date
	CITY OF WICHITA, KANSAS			
	<b>SITE GRADING PLAN</b>			
	WTP #2 EMERGENCY POWER PROJECT C.O.W. PROJECT NO. 468-84956			
	PROFESSIONAL ENGINEERING CONSULTANTS, P.A. 303 SOUTH TOPEKA WICHITA, KS 67202 316-262-2691 www.pec1.com			
	Designed by MEB Drawn by CAL	Job No. 34-14229-001-0042 Date February 2015	SHL C4.0 of 36	