


STORMWATER DRAIN #394 FOR  
**FOX RIDGE PLAZA ADDITION**

**LANDSCAPE PLAN**

PROJECT NO.	468-84953	
DATE	JULY 2015	
SCALE	1"=30'	
DESIGNED	DRAWN	CHECKED
JAG	MLP	JAG
#		###/###
NO.	REVISION	DATE

J:\PROJECTS\2011\1010577 PREMIER FOX RIDGE PLAZA\AS-CIVIL\LANDSCAPE\11577\_LA-01-PRIVATE.DWG  
 PLOTTED: Wednesday, July 22, 2015 @ 09:20AM

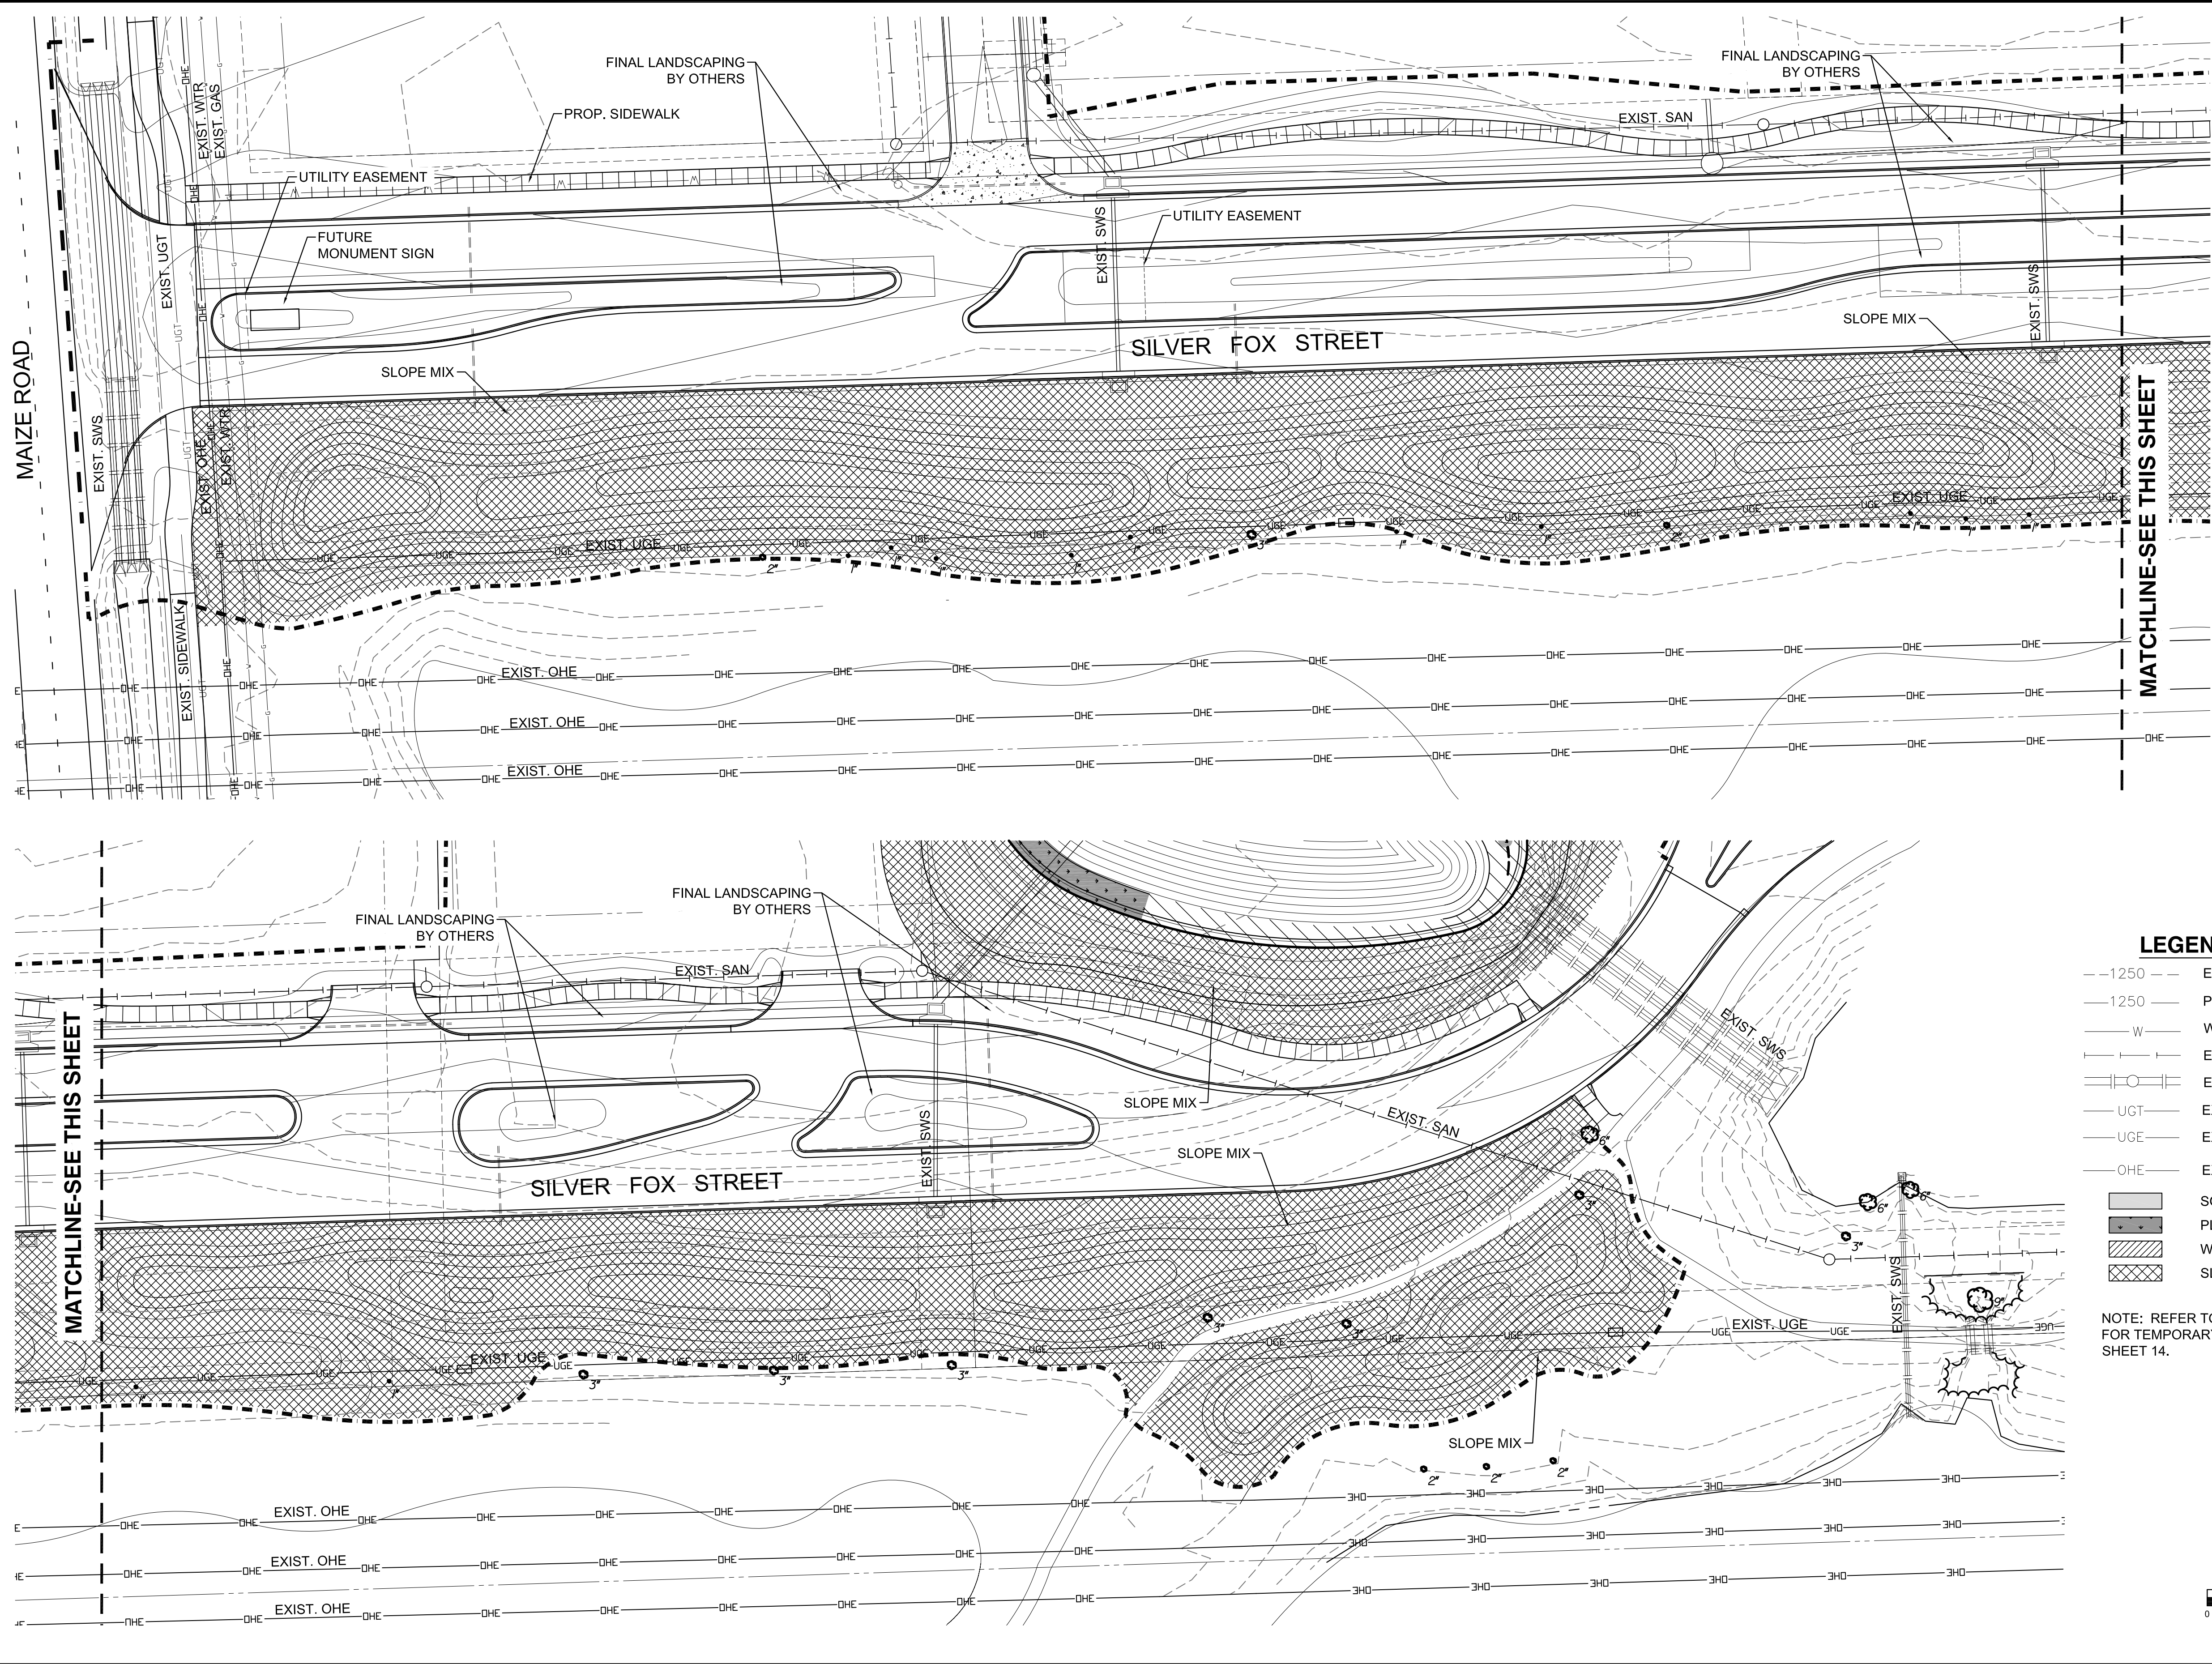

**LEGEND**

- 1250--- EXISTING CONTOUR
- - -1250- - - PROPOSED CONTOUR
- W WATERLINE
- EXISTING SANITARY SEWER
- EXISTING STORMWATER SEWER
- UGT --- EXISTING UNDERGROUND TELEPHONE
- UGE --- EXISTING UNDERGROUND ELECTRICAL
- OHE --- EXISTING OVERHEAD ELECTRICAL
- [Hatched Box] SOD AREAS
- [Solid Box] PLUGGED AREAS
- [Diagonal Hatched Box] WET PRAIRIE MIX
- [Cross-hatched Box] SLOPE MIX

NOTE: REFER TO EROSION CONTROL PLANS FOR TEMPORARY SEEDING LOCATIONS. SHEET 14.

