


# LATERAL 13, MAIN 16 OF THE FOUR MILE CREEK SEWER IN THE CITY OF WICHITA, KANSAS

OCA NO. 744336

CITY OF WICHITA PROJECT NO. 468-84818  
GARY JANZEN, P.E. - INTERIM CITY ENGINEER

WB Carter - Contractor  
J. Westhoff - City of Wichita, Field Project Engineer  
D. Hicks - City of Wichita, Inspector  
Stubs and Risers  
As-built  
Release Date: 8/20/2012  
: APROsas 10/08/2012

**AS-BUILT PLANS**  
**CONTRACTOR: MIES CONSTRUCTION**  
**SUPERINTENDENT: ALBERT WILLIAMS**  
**CLIENT: CITY OF WICHITA**  
**INSPECTOR: JACOB MORRIS, SCHWAB-EATON, P.A.**  
**PDF BY: JCM 11/23/15**

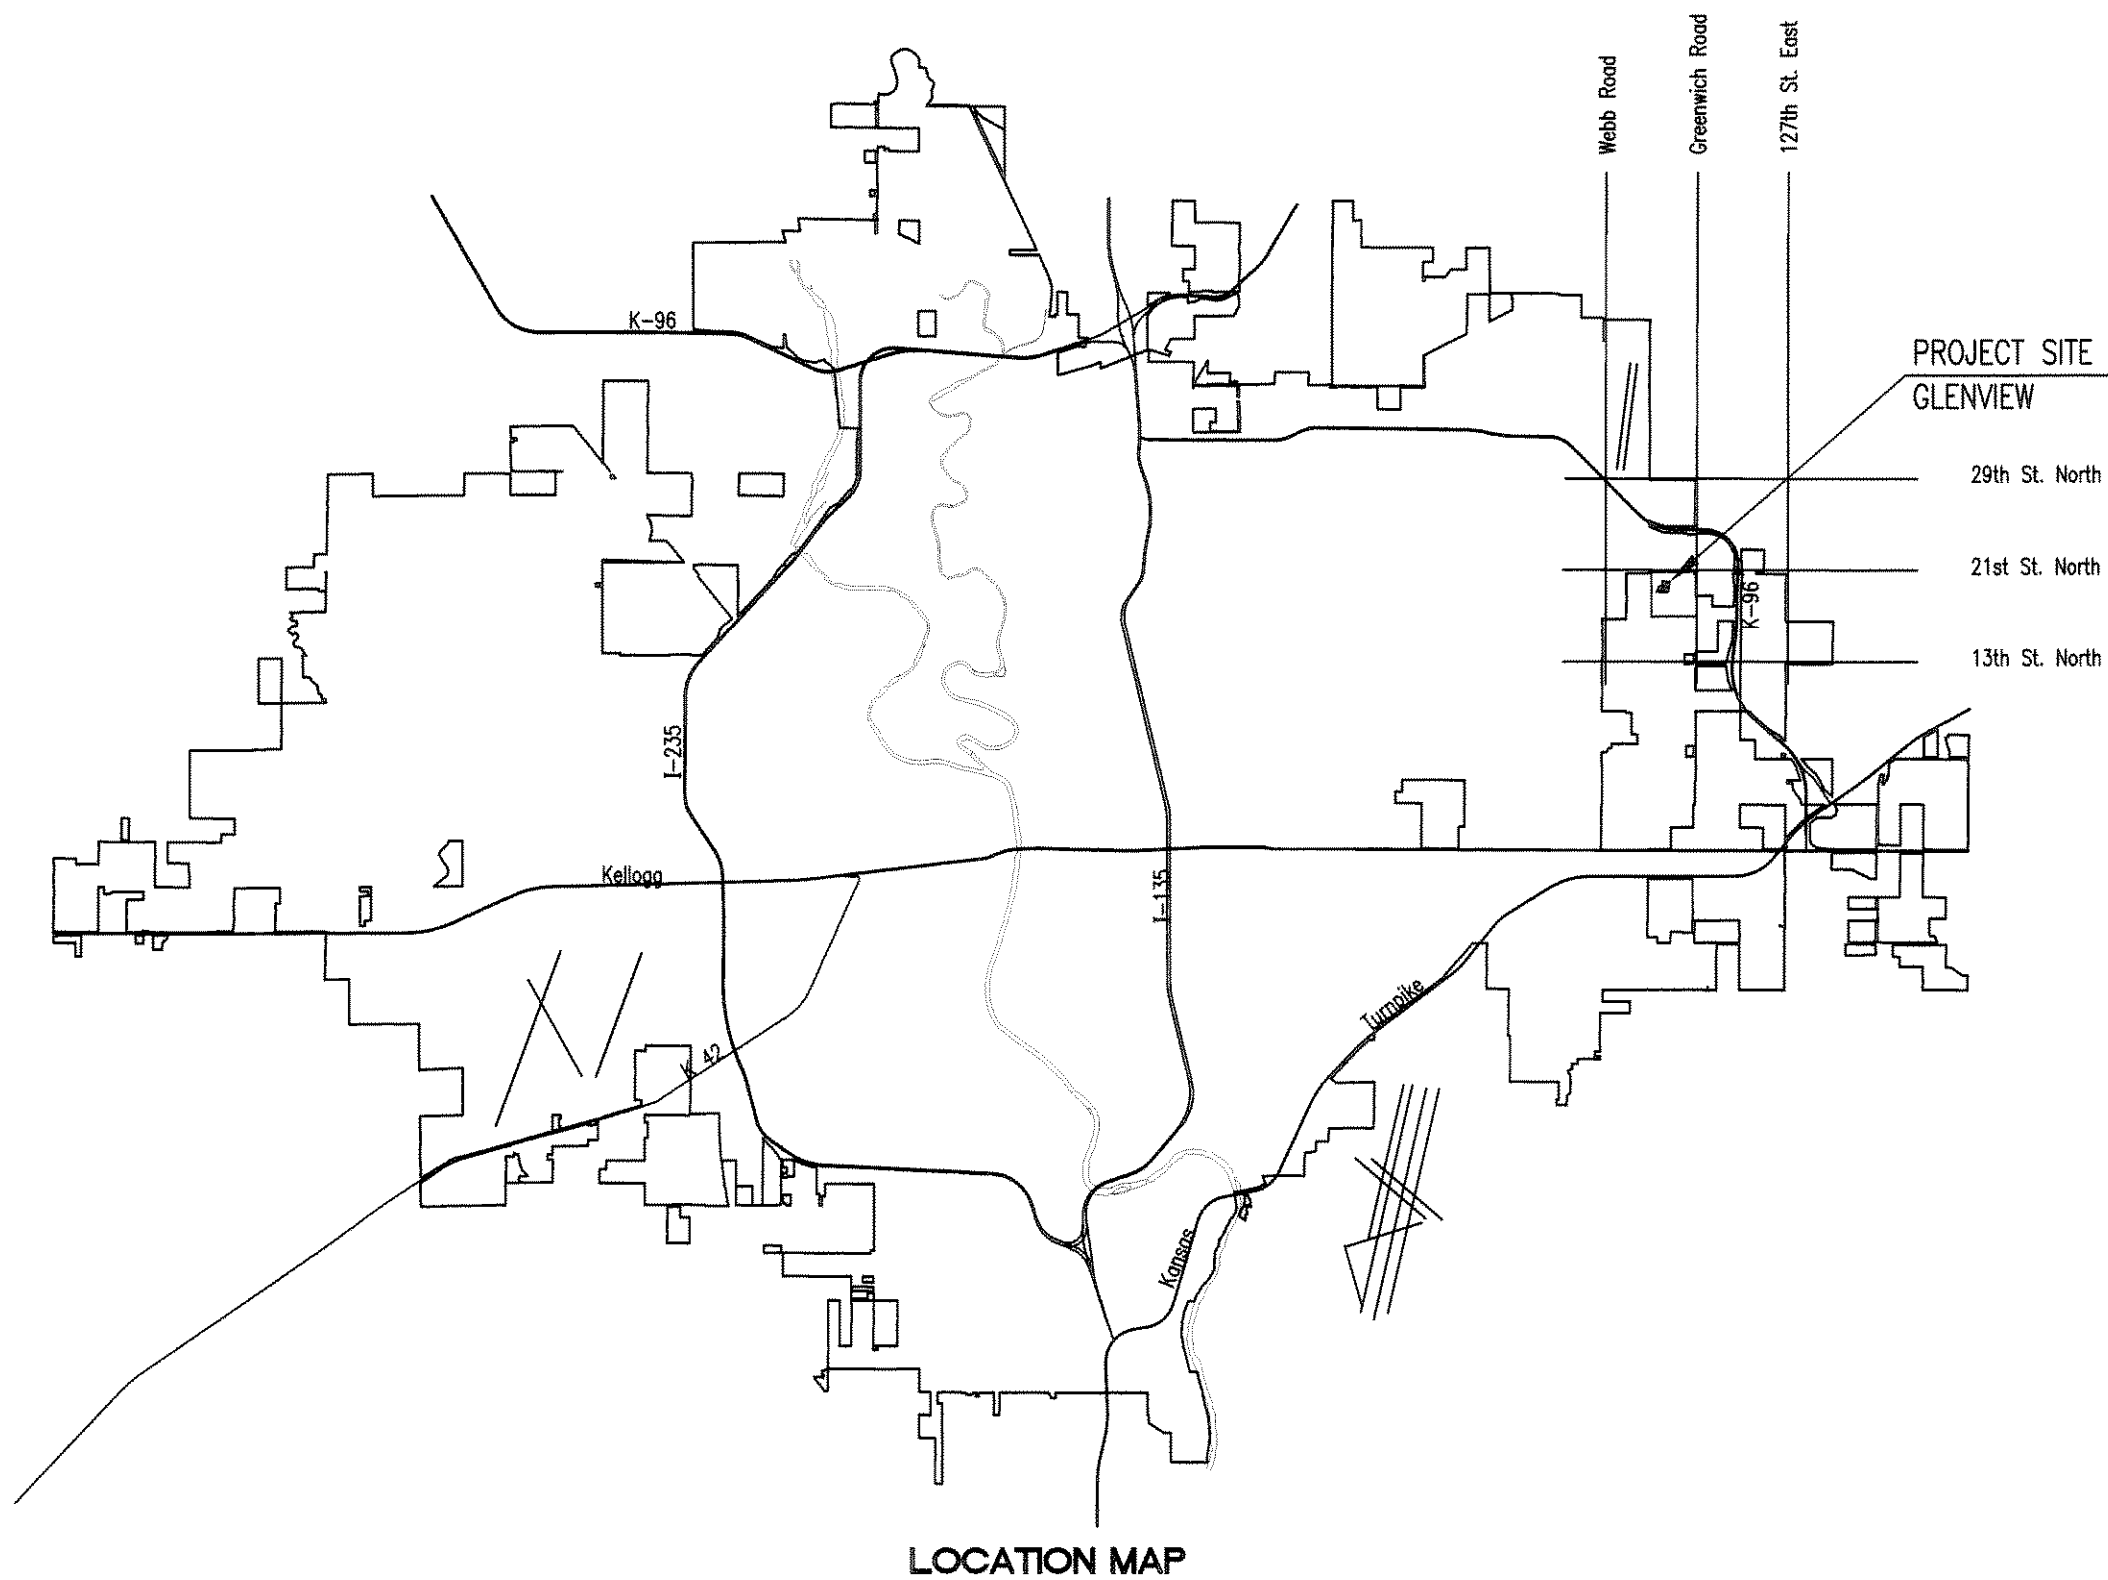

DEVELOPER CONTACT

MR. DAVID HAMBRICK  
SLAWSON COMPANIES  
727 N. WACO, SUITE 400  
WICHITA, KANSAS 67203  
(316) 263-3201

INDEX OF SHEETS

SHEET NO. 1	TITLE SHEET
SHEET NO. 2	KEY MAP AND GENERAL NOTES
SHEET NO. 3	PLAN
SHEET NO. 4-6	PLAN/PROFILE
SHEET NO. 7	STANDARD TYPE "P" MANHOLE DETAILS
SHEET NO. 8	MH FRAME AND COVER DETAILS
SHEET NO. 9	VERTICAL RISER DETAILS
SHEET NO. 10	EROSION CONTROL PLAN
SHEET NO. 11-14	EROSION CONTROL DETAILS

CONSTRUCTION SCHEDULE/COORDINATION

THE CONTRACTOR(S) FOR THE FOLLOWING PROJECTS SHALL COORDINATE THEIR EFFORTS SUCH THAT ANY NECESSARY SIMULTANEOUS CONSTRUCTION (INCLUDING PRIVATE PAVING IMPROVEMENTS) CAN PROCEED CONCURRENTLY WITHOUT CAUSING UNDUE DELAYS SO THAT CONSTRUCTION CAN BE COMPLETED WITHIN THE TIME FRAME AS NOTED. THE CONTRACTOR(S) SHALL COMPLETE THE FOLLOWING PUBLIC IMPROVEMENTS PROJECTS BY SEPTEMBER 10, 2012 UNLESS OTHERWISE INDICATED IN THE PROJECT SPECIAL PROVISIONS.

468-84818 LATERAL 13, MAIN 16 of the FOUR MILE CREEK SEWER  
448-90552 WATER DISTRIBUTION SYSTEM  
468-84819 STORM WATER DRAIN #663

## JUNE 2012

PLANS PREPARED BY  
**PROFESSIONAL ENGINEERING CONSULTANTS, P.A.**  
ENGINEERS  
WICHITA, KANSAS

