

4/22/2016 9:17:25 AM



Wichita, KS • 316-684-9600

# CITY OF WICHITA, KANSAS RE-USE WATER PUMP STATION TO SERVE SPIRT AEROSYSTEMS

©2016 MKEC Engineering  
All Rights Reserved  
www.mkec.com  
These drawings and their contents, including, but not limited to, all concepts, designs, & ideas are the exclusive property of MKEC Engineering (MKEC), and may not be used or reproduced in any way without the express consent of MKEC.

## PIPING AND INST. DIAGRAM

PROJECT NO.	468-85112
DATE	04/18/16
SCALE	AS NOTED
DESIGNED	DAS
DRAWN	JA
CHECKED	KTS

0	ISSUED FOR CONSTRUCTION	04/18/16
NO.	REVISION	DATE


SHEET NO.

G2.0

SPR-P001  
EFFLUENT REUSE PUMP  
700 GPM @ 330 FT TDH  
100HP @ 0-1800 RPM


SPR-P002  
EFFLUENT REUSE PUMP  
700 GPM @ 330 FT TDH  
100 HP @ 0-1800 RPM

SPR-P003  
EFFLUENT REUSE PUMP  
700 GPM @ 330 FT TDH  
100 HP @ 0-1800 RPM

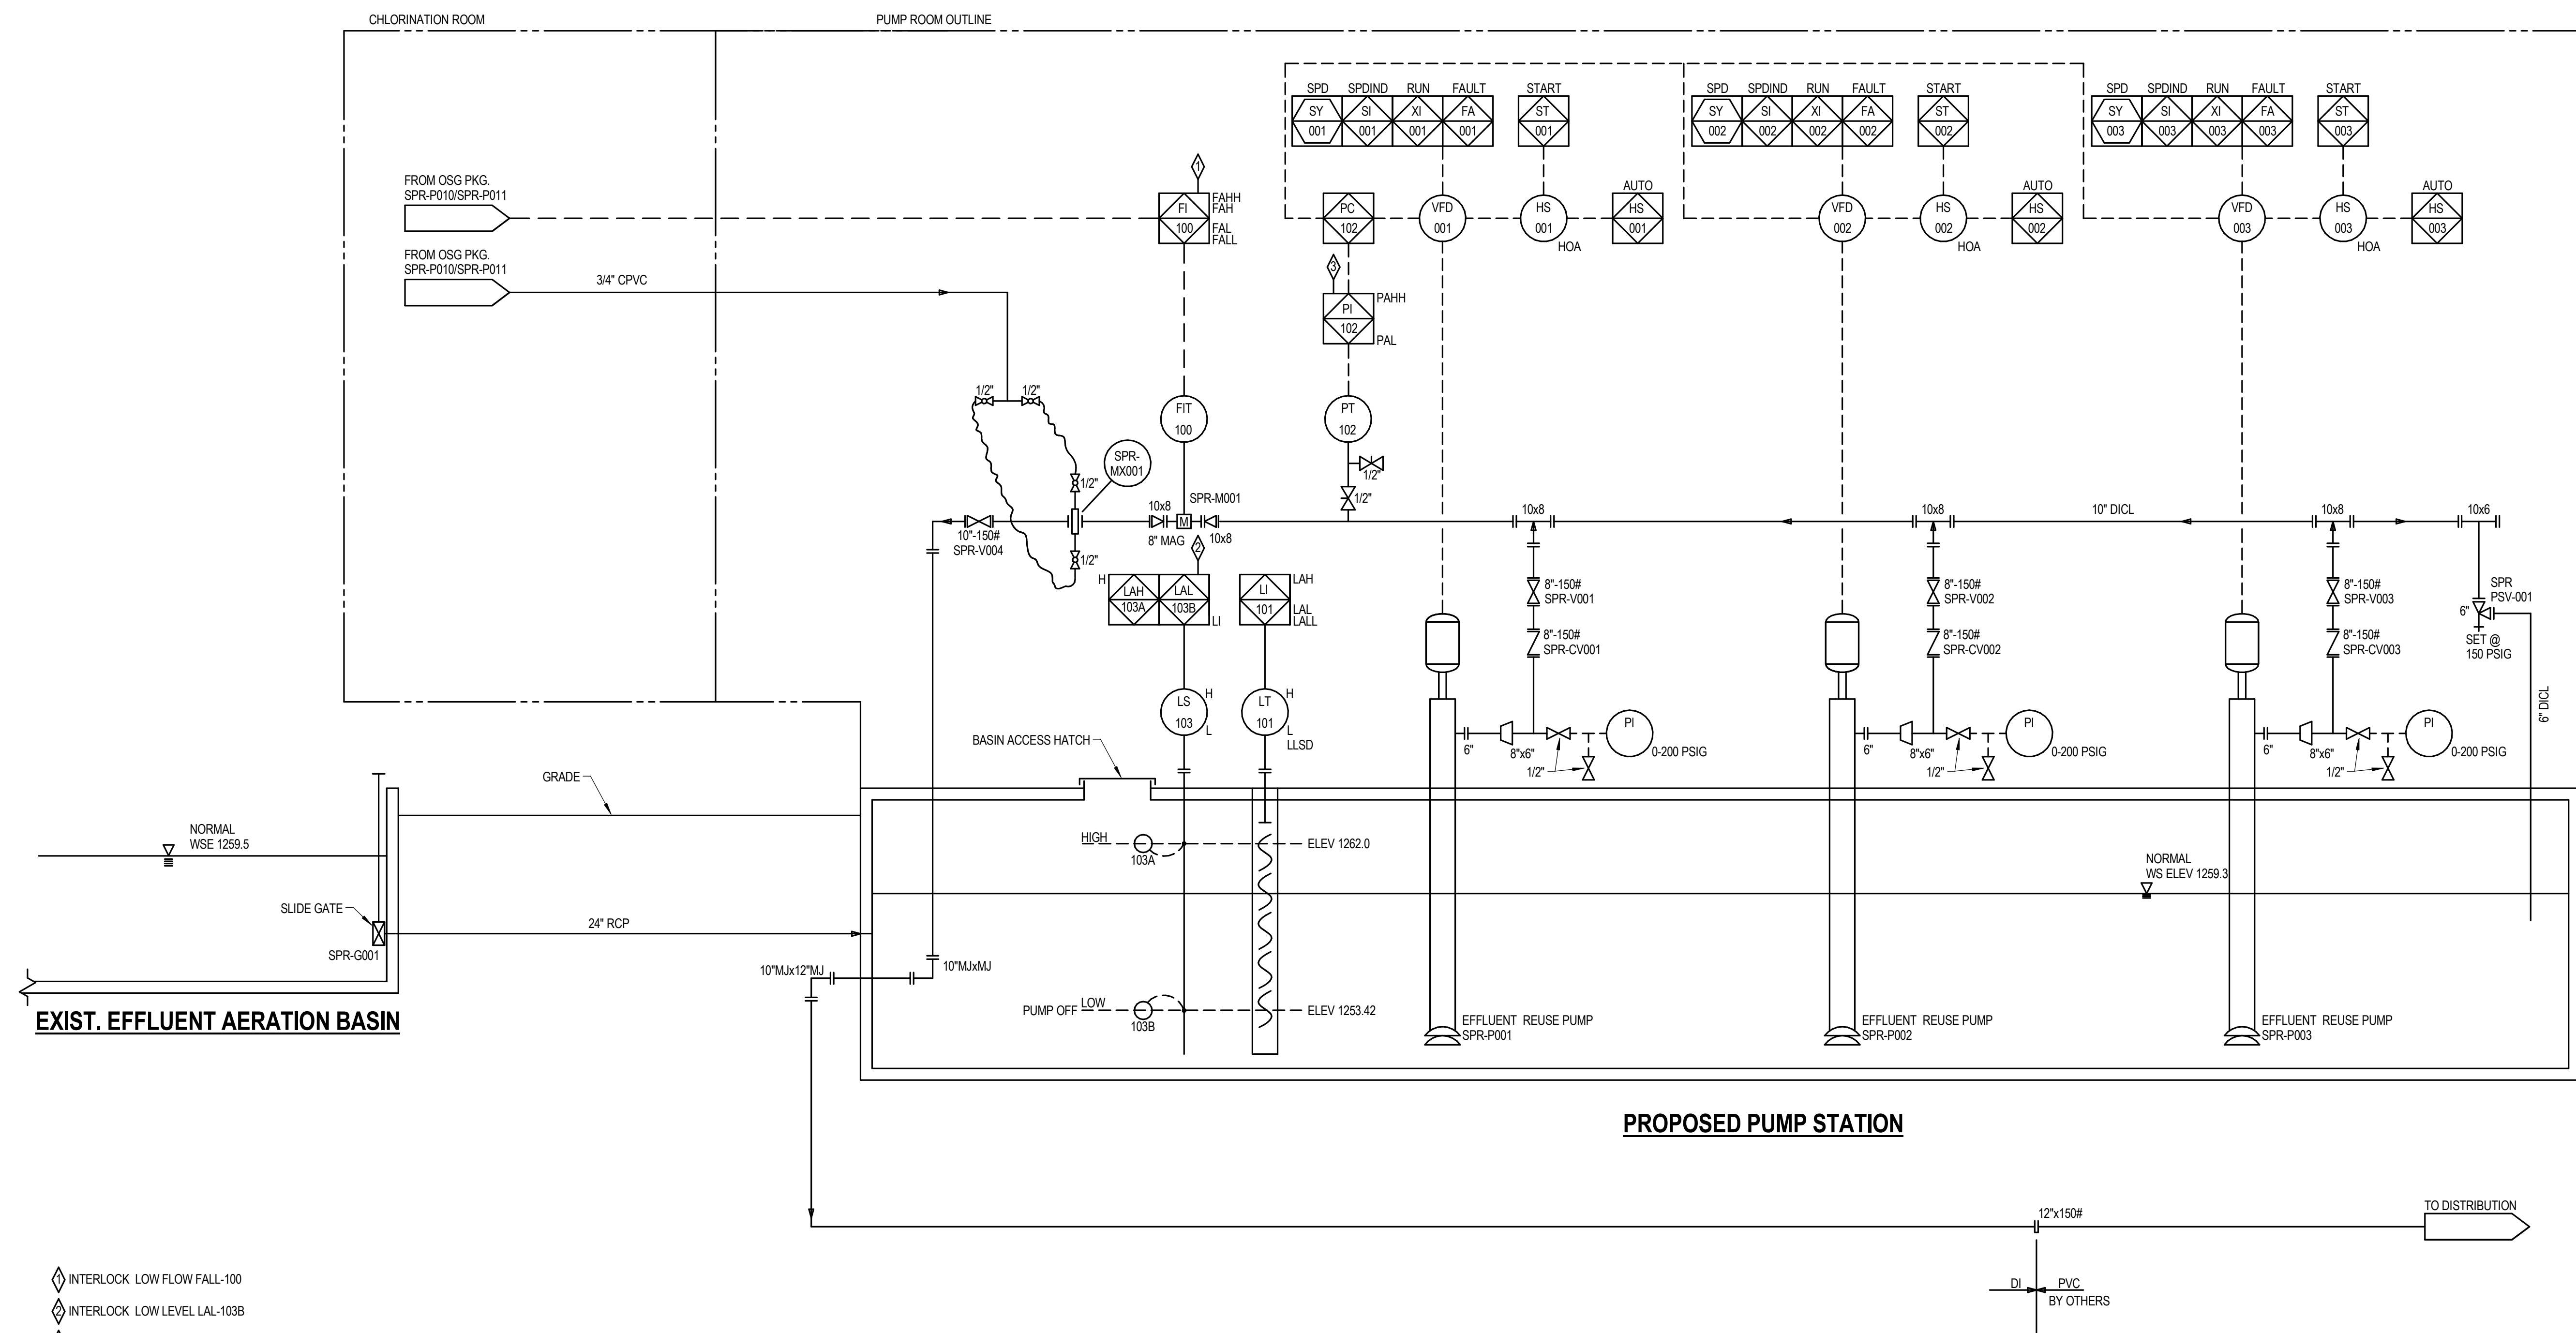

- ◇ INTERLOCK LOW FLOW FALL-100
- ◇ INTERLOCK LOW LEVEL LAL-103B
- ◇ INTERLOCK HIGH PRESSURE PAHH-102

## 1 PIPING AND INSTRUMENTATION DIAGRAM

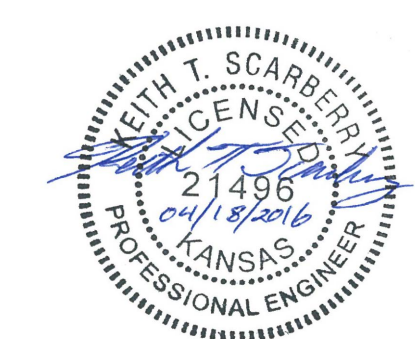

C:\Users\jlanza\Documents\15823 - COW WATER PUMP - MEP - jlanza.rvt