

CITY OF WICHITA, KANSAS
RE-USE WATER PUMP STATION
TO SERVE SPIRIT AEROSYSTEMS

©2016
MKEC Engineering
All Rights Reserved
www.mkec.com
These drawings and their contents, including, but not limited to, all concepts, designs, & ideas are the exclusive property of MKEC Engineering (MKEC), and may not be used or reproduced in any way without the express consent of MKEC.

FOUNDATION PLAN - BLDG

PROJECT NO.	468-85112	
DATE	04/18/16	
SCALE	AS NOTED	
DESIGNED	DRAWN	CHECKED
SK	CAM	AR



1 ISSUED FOR CONSTRUCTION 04/18/16		
NO.	REVISION	DATE
SHEET NO.		
S1.1		


NOTE:
SAW CUT JOINTS OR KEYED CONSTRUCTION JOINTS IN 6" SLABS ON GRADE SHALL BE SPACED TO DIVIDE THE SLAB INTO PANELS NOT TO EXCEED 225 SQUARE FEET. THE LONGER DIMENSION OF EACH PANEL SHALL NOT EXCEED THE SHORTER DIMENSIONS BY MORE THAN 20%. LINE UP w/ C.L. OF BUILDING WHERE POSSIBLE. CONTRACTOR SHALL SUBMIT JOINT LAYOUT TO ARCHITECT FOR APPROVAL. REFER TO DETAILS A/S1.1 & B/S1.1.

FOOTING SCHEDULE


MARK	SIZE	REINF.
(A)	3'-6" SQ. X 1'-0" DP. MIN.	(4) #5 EA. WAY BOT.

METAL BUILDING ANCHOR BOLT SCHEDULE

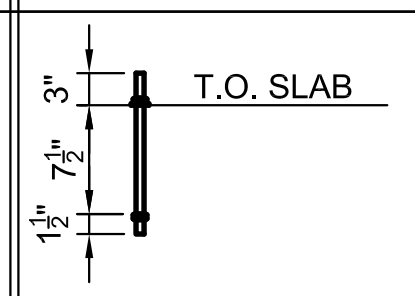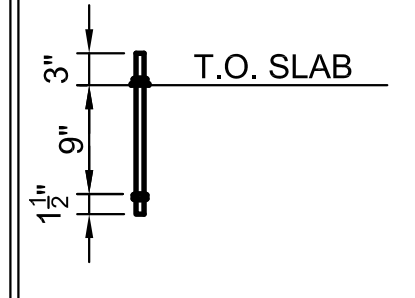
SIZE	LENGTH	DIAGRAM
$\frac{3}{8}$ " Ø	1'-0" (TACK WELD BOT. NUT)	
$\frac{1}{2}$ " Ø	1'-1 1/2" (TACK WELD BOT. NUT)	

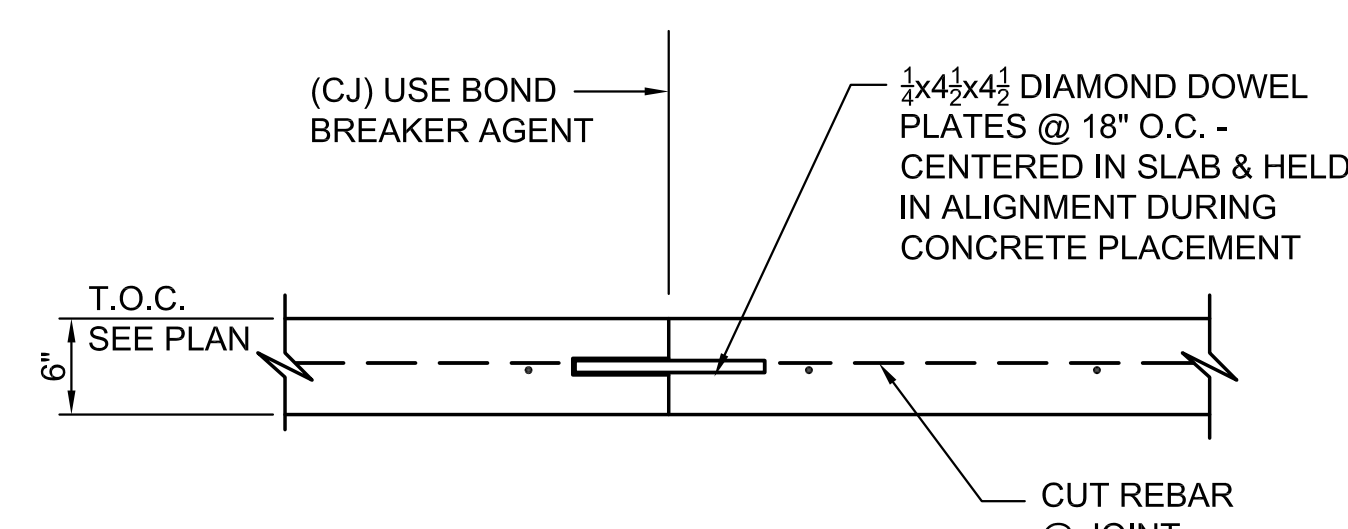

A S1.1 TYP. DOWELED CONST. JT.
SCALE: 1" = 1'-0" (6" SLAB)

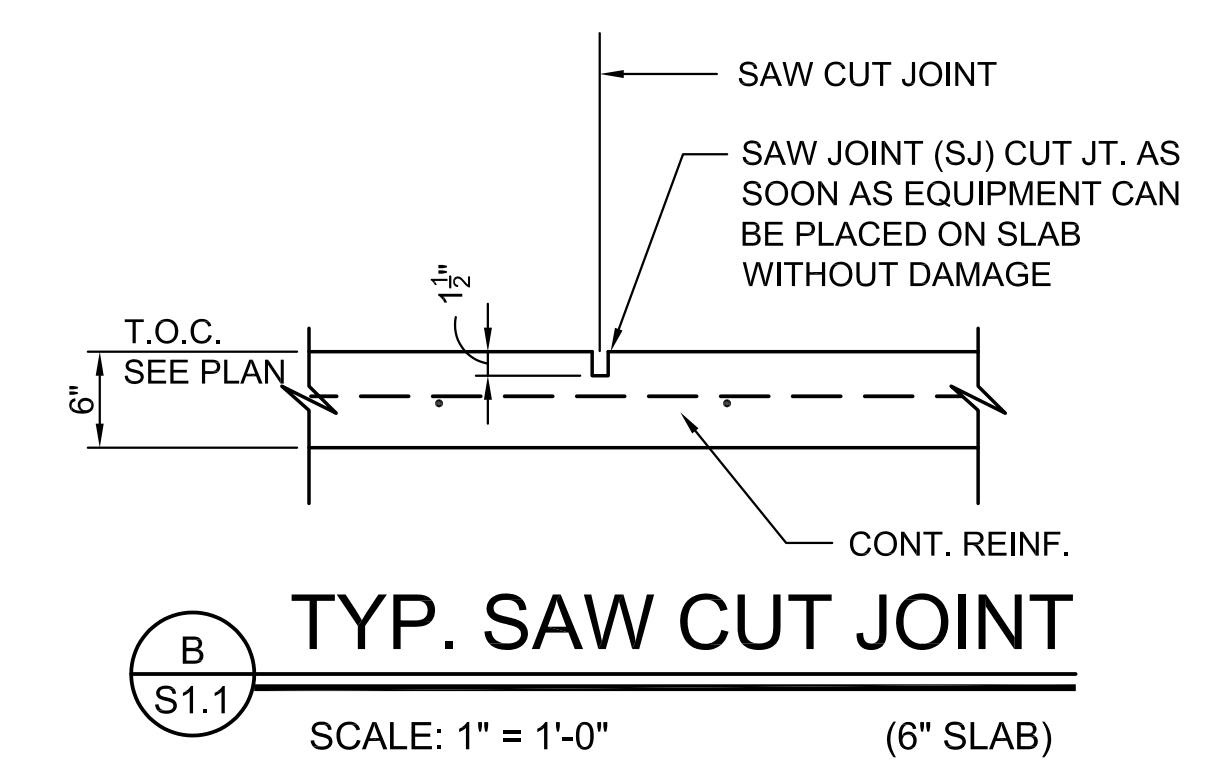

B S1.1 TYP. SAW CUT JOINT
SCALE: 1" = 1'-0" (6" SLAB)

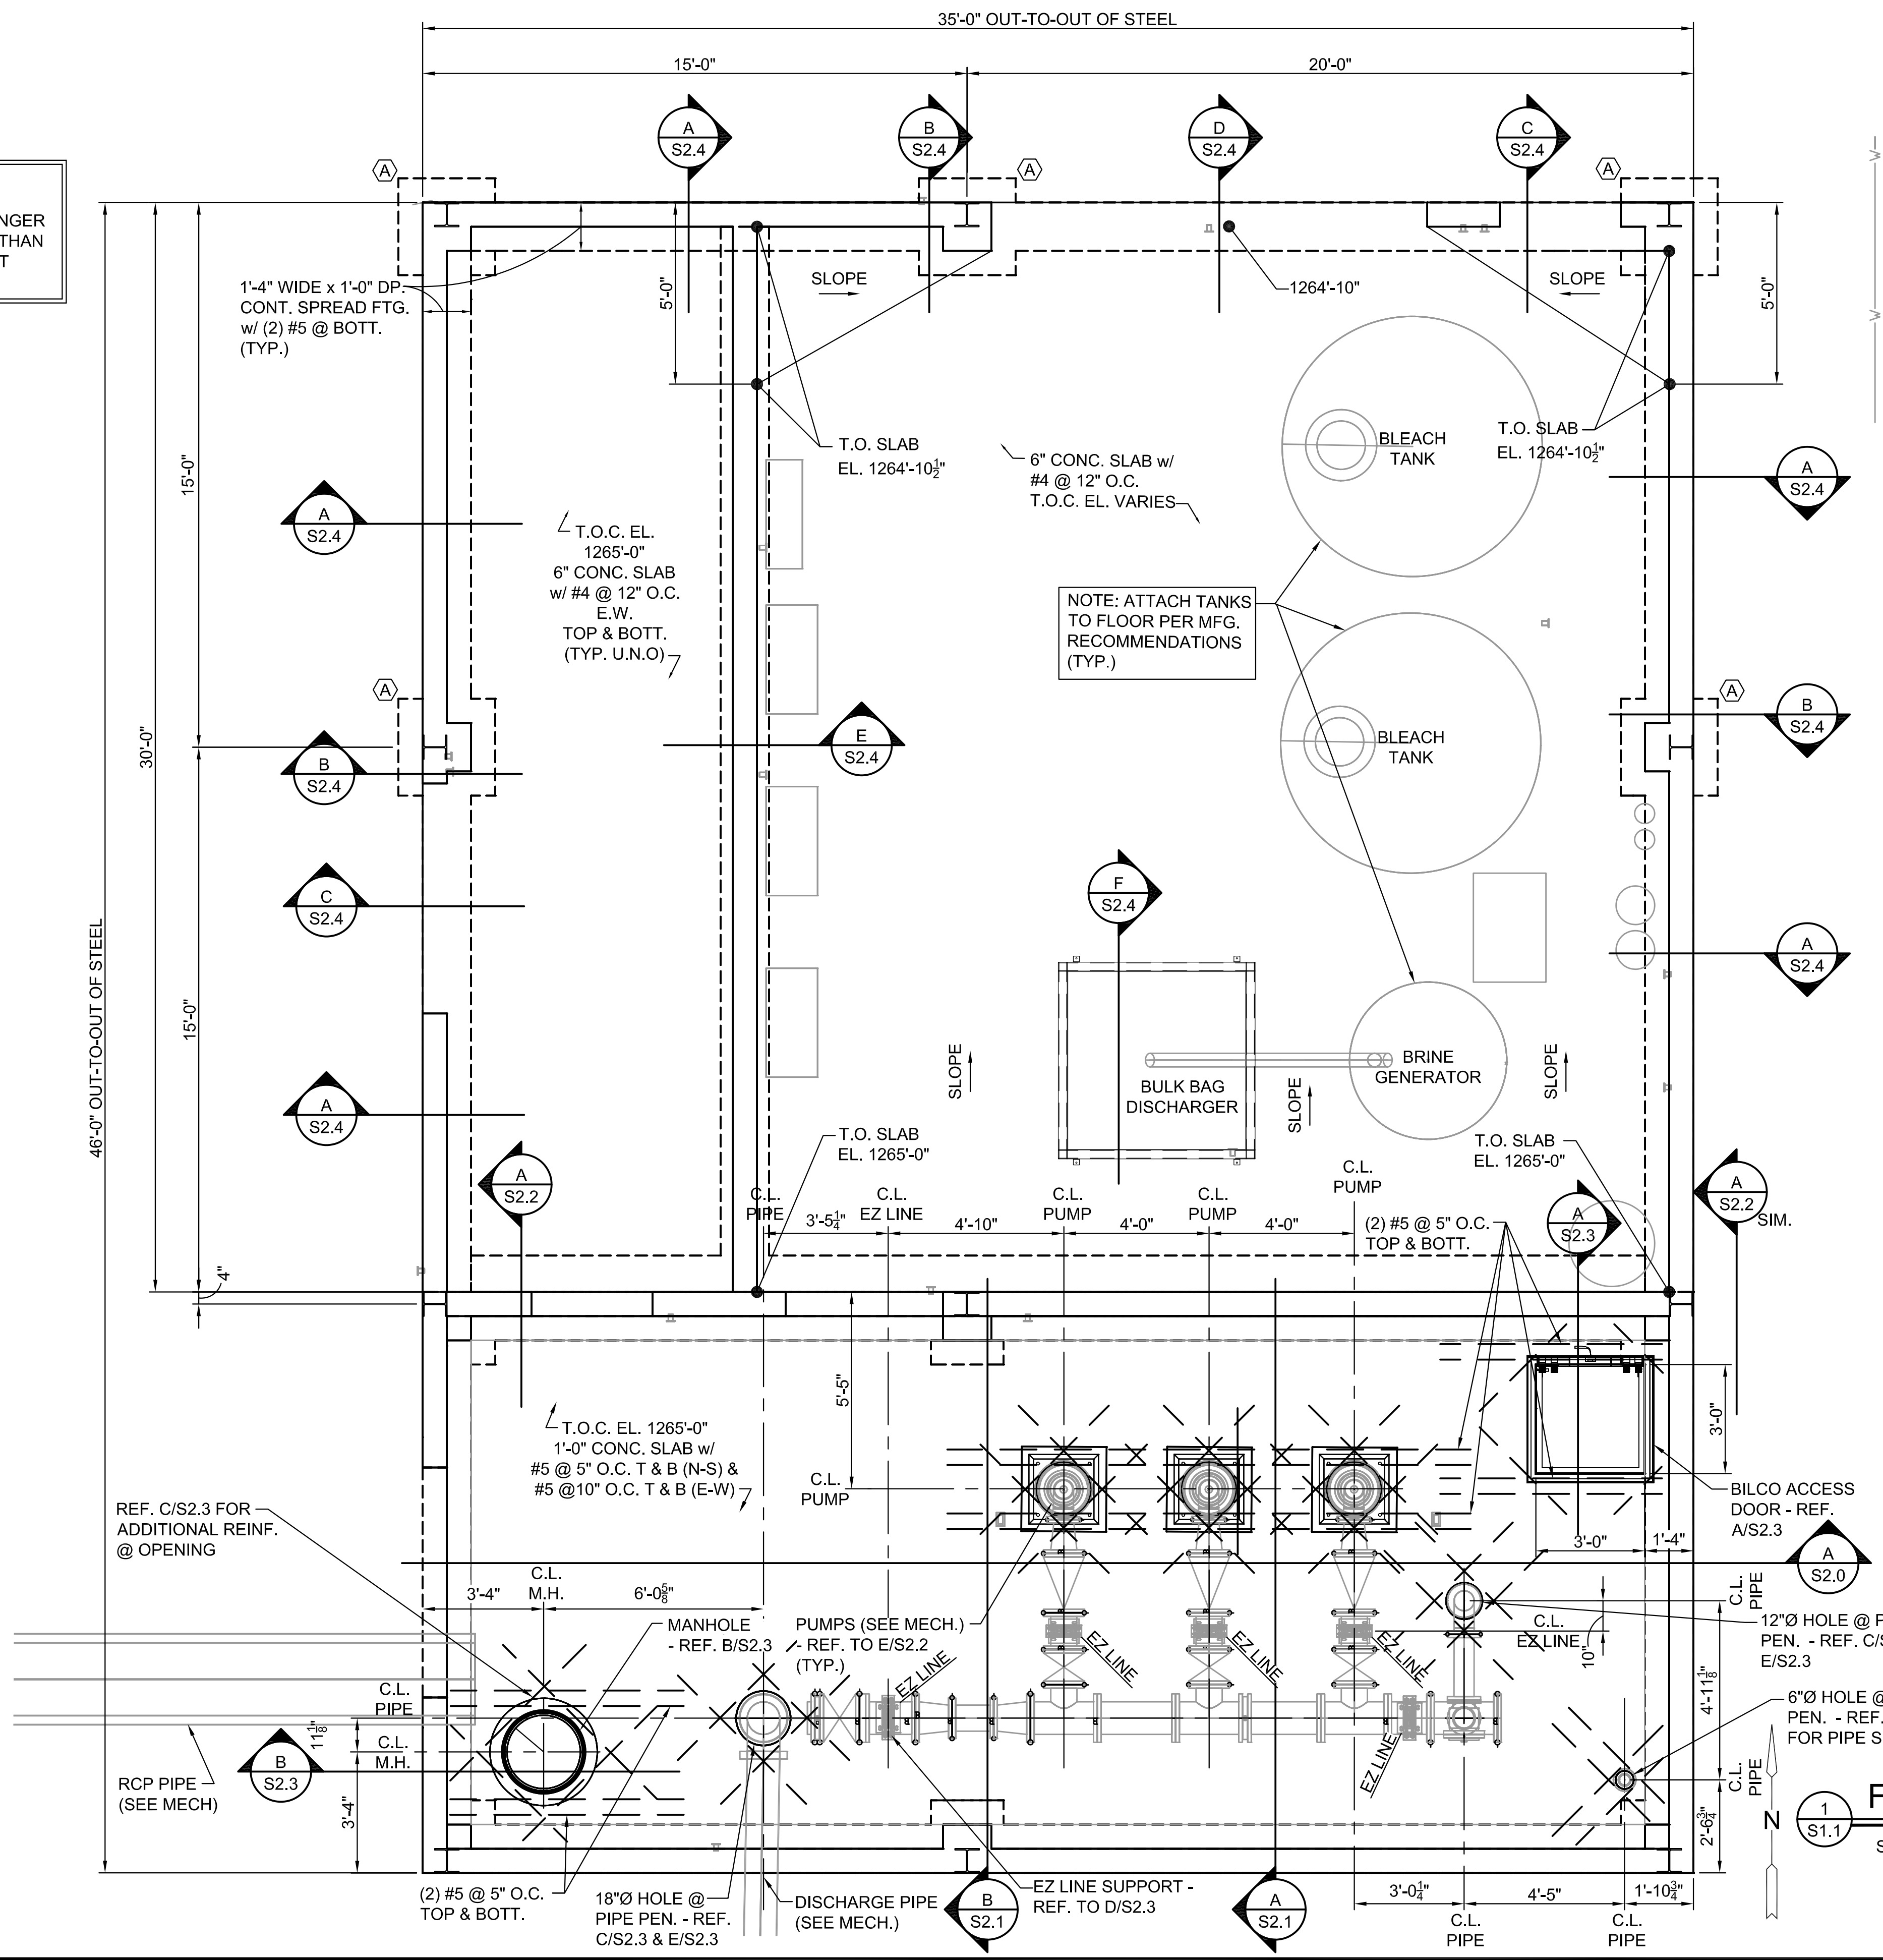

1 S1.1 FOUNDATION PLAN
SCALE: 3/8" = 1'-0"

J:\PROJECTS\2015\1501010623_COWI_REUSE_WATER_SUPPLY_SYSTEM_150623_CAD\SHOTS\06_STRUCT\DWGS\S1.1.DWG