
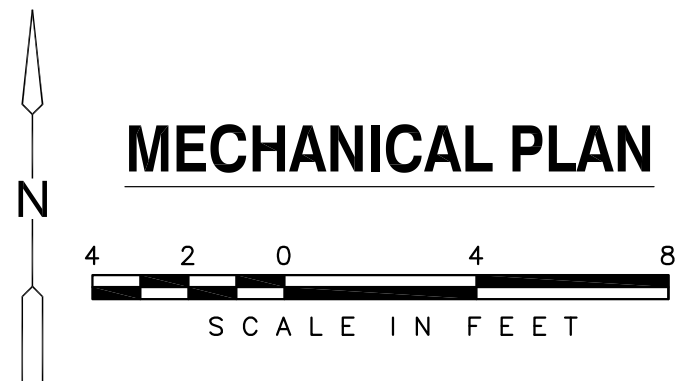



PLOTTED: Friday, April 22, 2016 @ 11:11AM

J:\PROJECTS\2015\15010\0623_COWI_REUSE_WATER_SUPPLY_SYSTEM\15_ISSUEDFOR CONSTRUCTION\DWG\02_DWG\020160418_MFC_PLANS\MECHANICAL\NOT SEALED\M5.01_MECHANICAL_PLAN.DWG

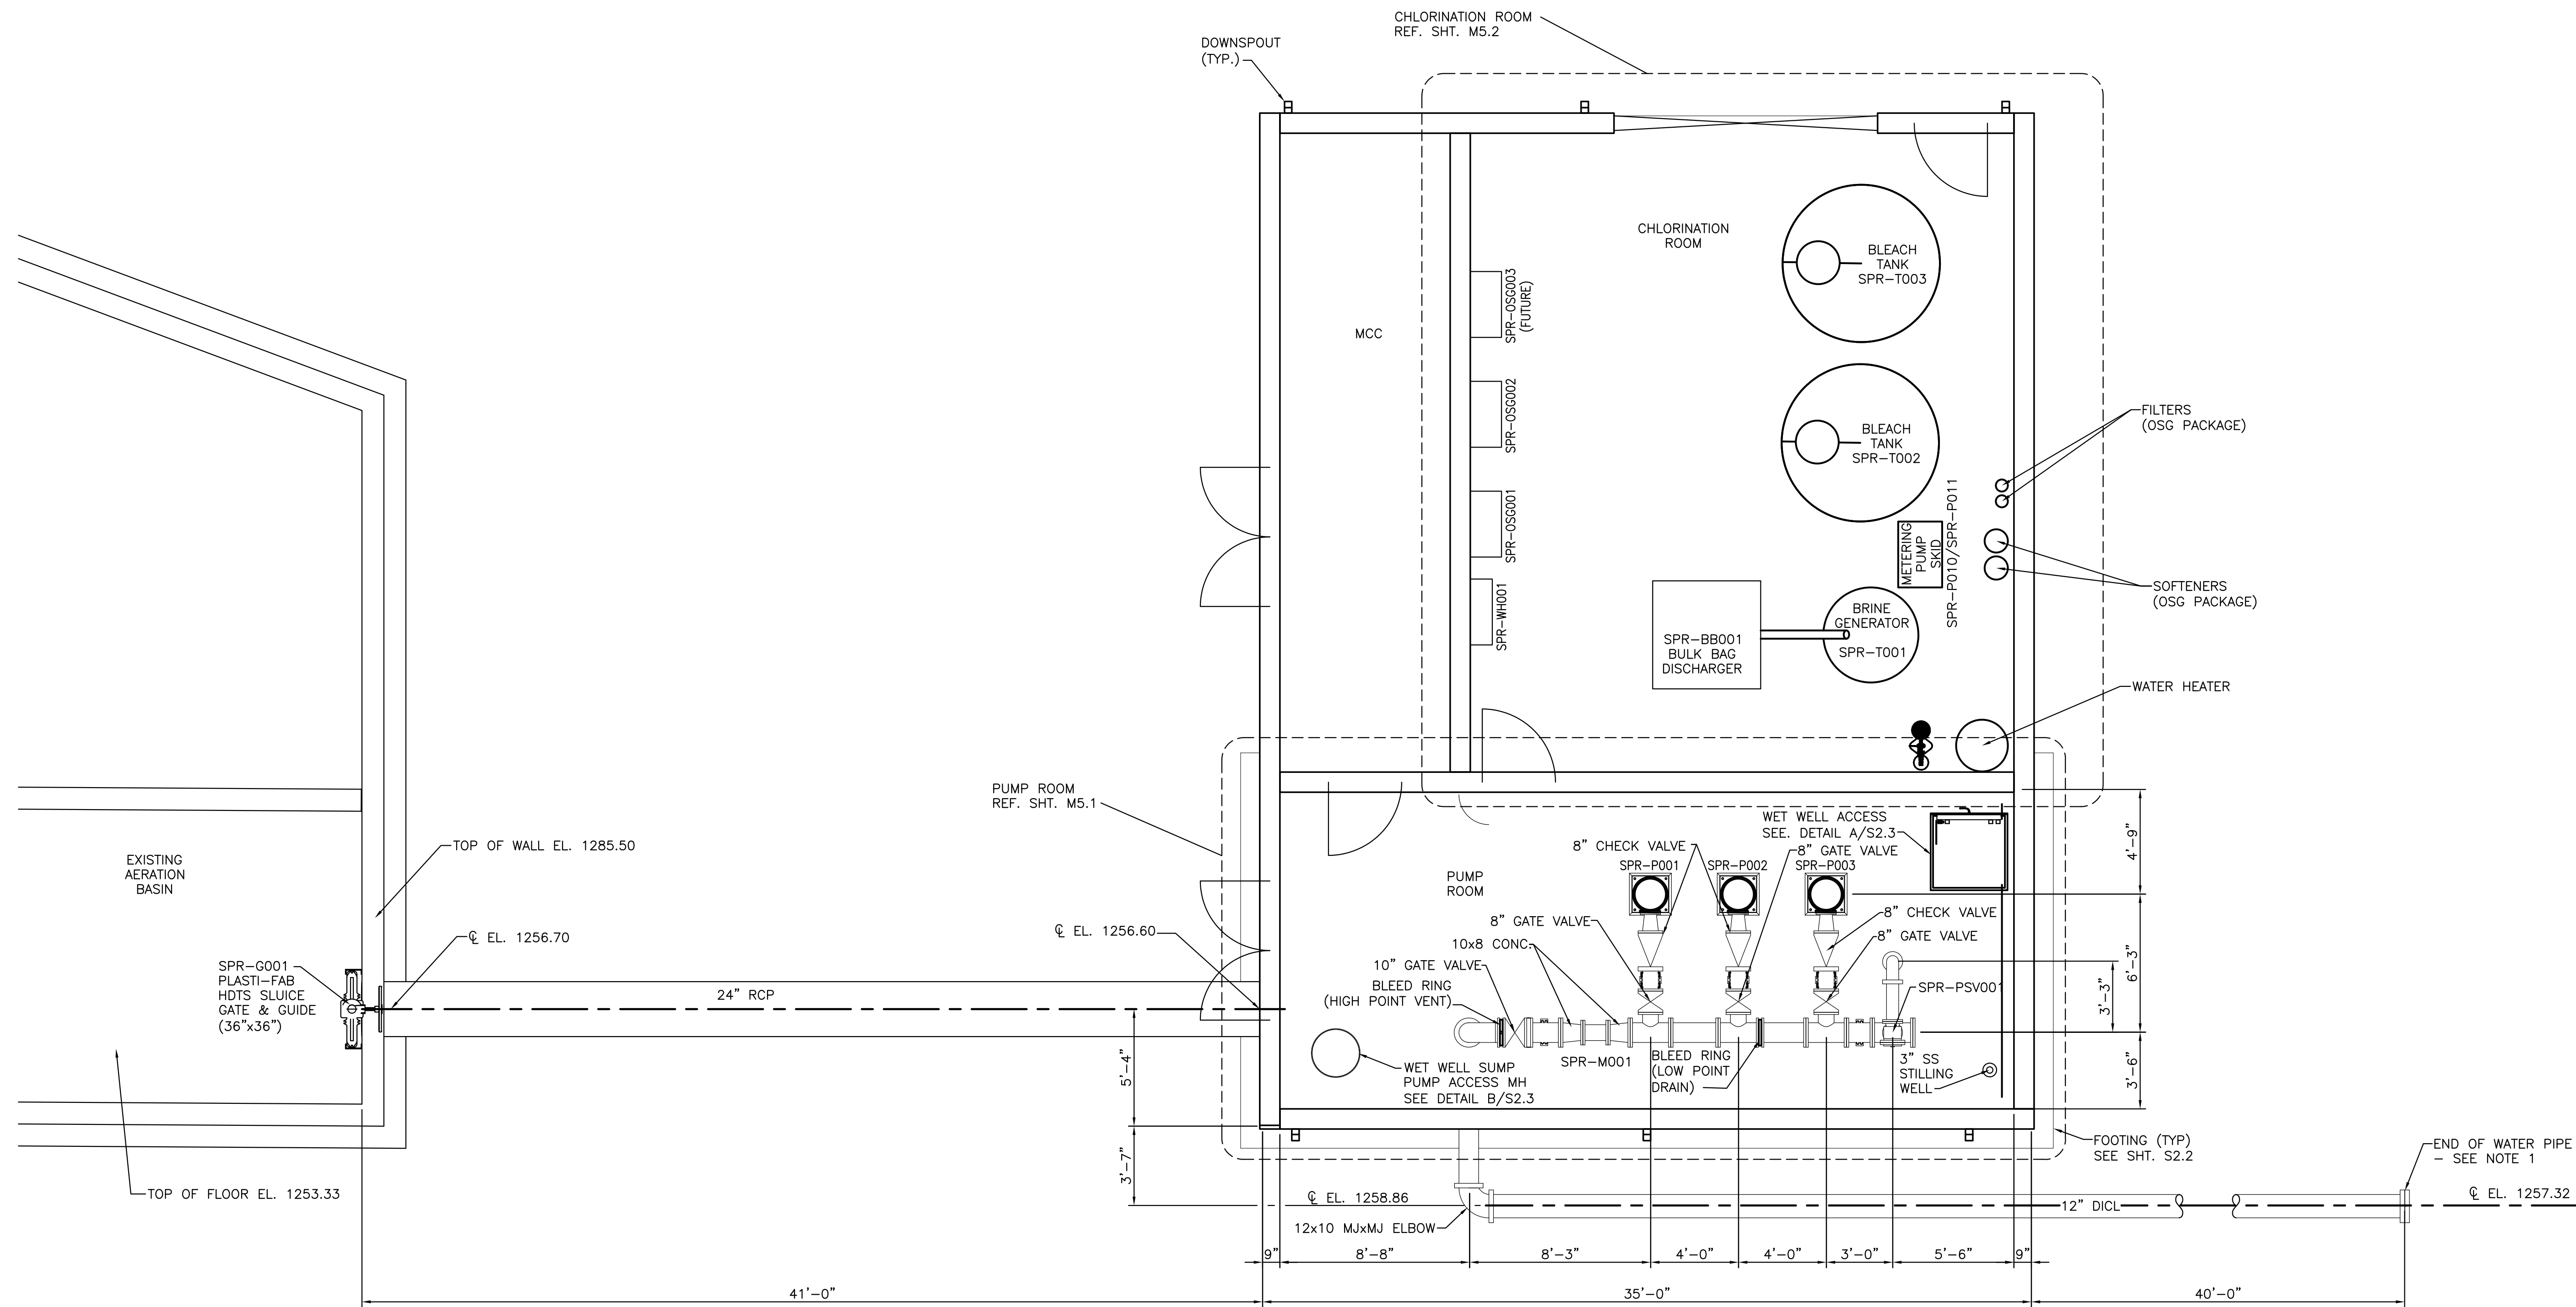

MECHANICAL PLAN

NOTES:
 1. CONTRACTOR TO INSTALL 12" DI BLIND FLANGE AT END OF PIPE AND SET A LATH AT THE SURFACE WITH THE FOLLOWING TEXT "END OF PIPE" SO THAT IT IS EASILY LOCATED BY THE PIPELINE CONTRACTOR.

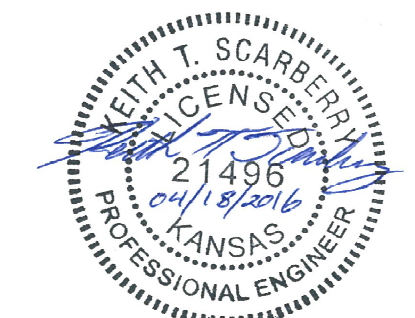

CITY OF WICHITA, KANSAS
RE-USE WATER PUMP STATION
 TO SERVE SPIRIT AEROSYSTEMS

©2016 MKEC Engineering All Rights Reserved
 www.mkec.com
 These drawings and their contents, including, but not limited to, all concepts, designs, & ideas are the exclusive property of MKEC Engineering (MKEC), and may not be used or reproduced in any way without the express consent of MKEC.

MECHANICAL PLAN

PROJECT NO.	468-85112	
DATE	04/18/16	
SCALE	AS NOTED	
DESIGNED	DRAWN	CHECKED
BWT	ALF	KTS

ISSUED FOR CONSTRUCTION	04/18/16	
NO.	REVISION	DATE

SHEET NO.
M5.0