
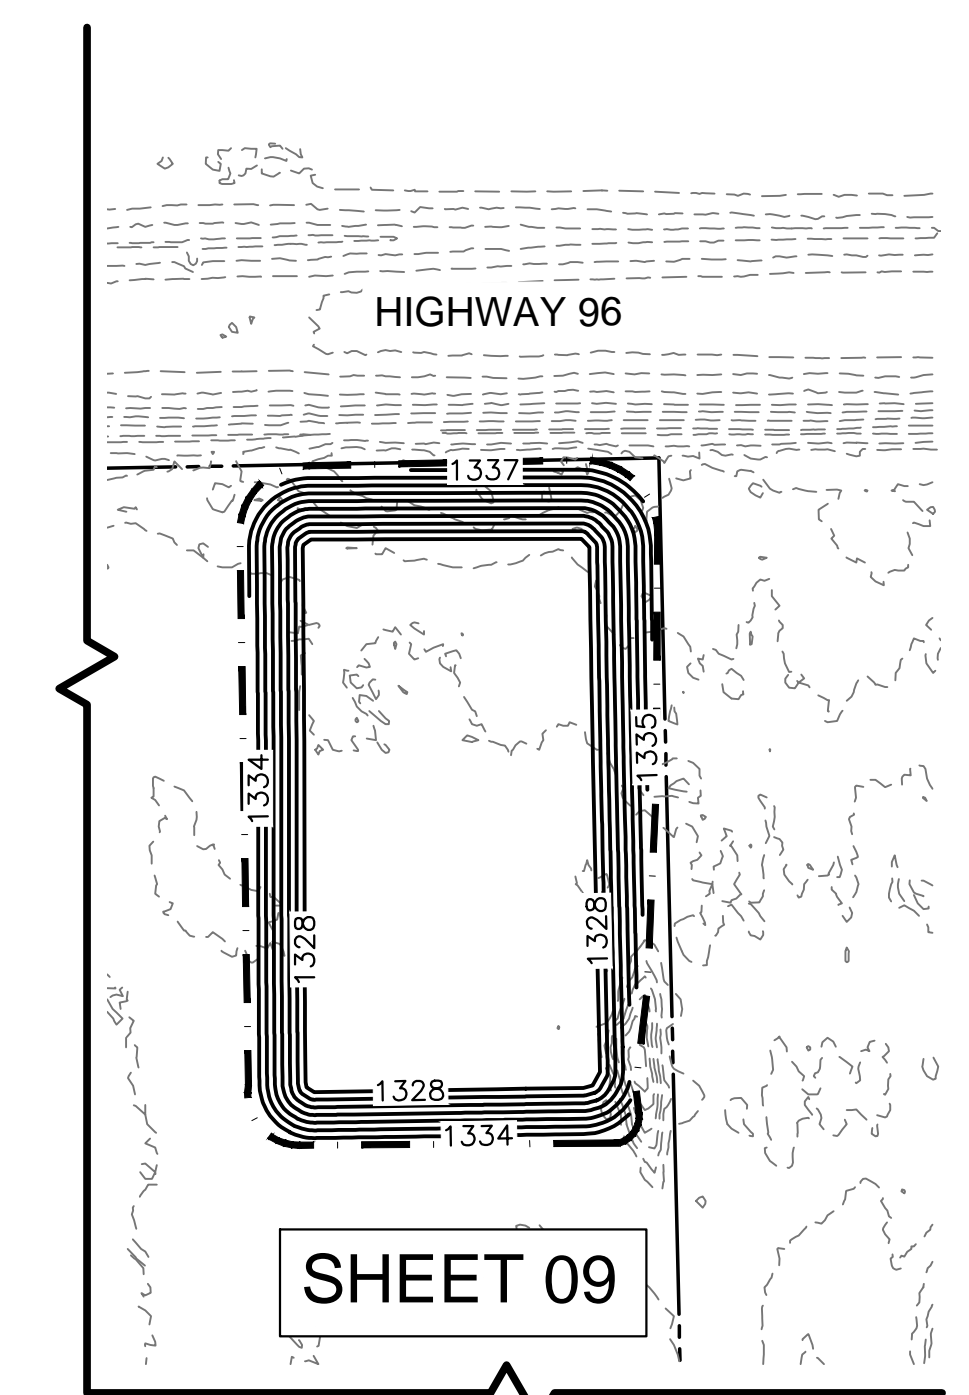


PLOTTED: Tuesday, July 18, 2017 @ 02:44PM


J:\PROJECTS\2017\1401010462 - PREMIER ESTANCIA\DWG\CAD\GRD\PH2\1462.GRD\_PLANS\_PHE.DWG

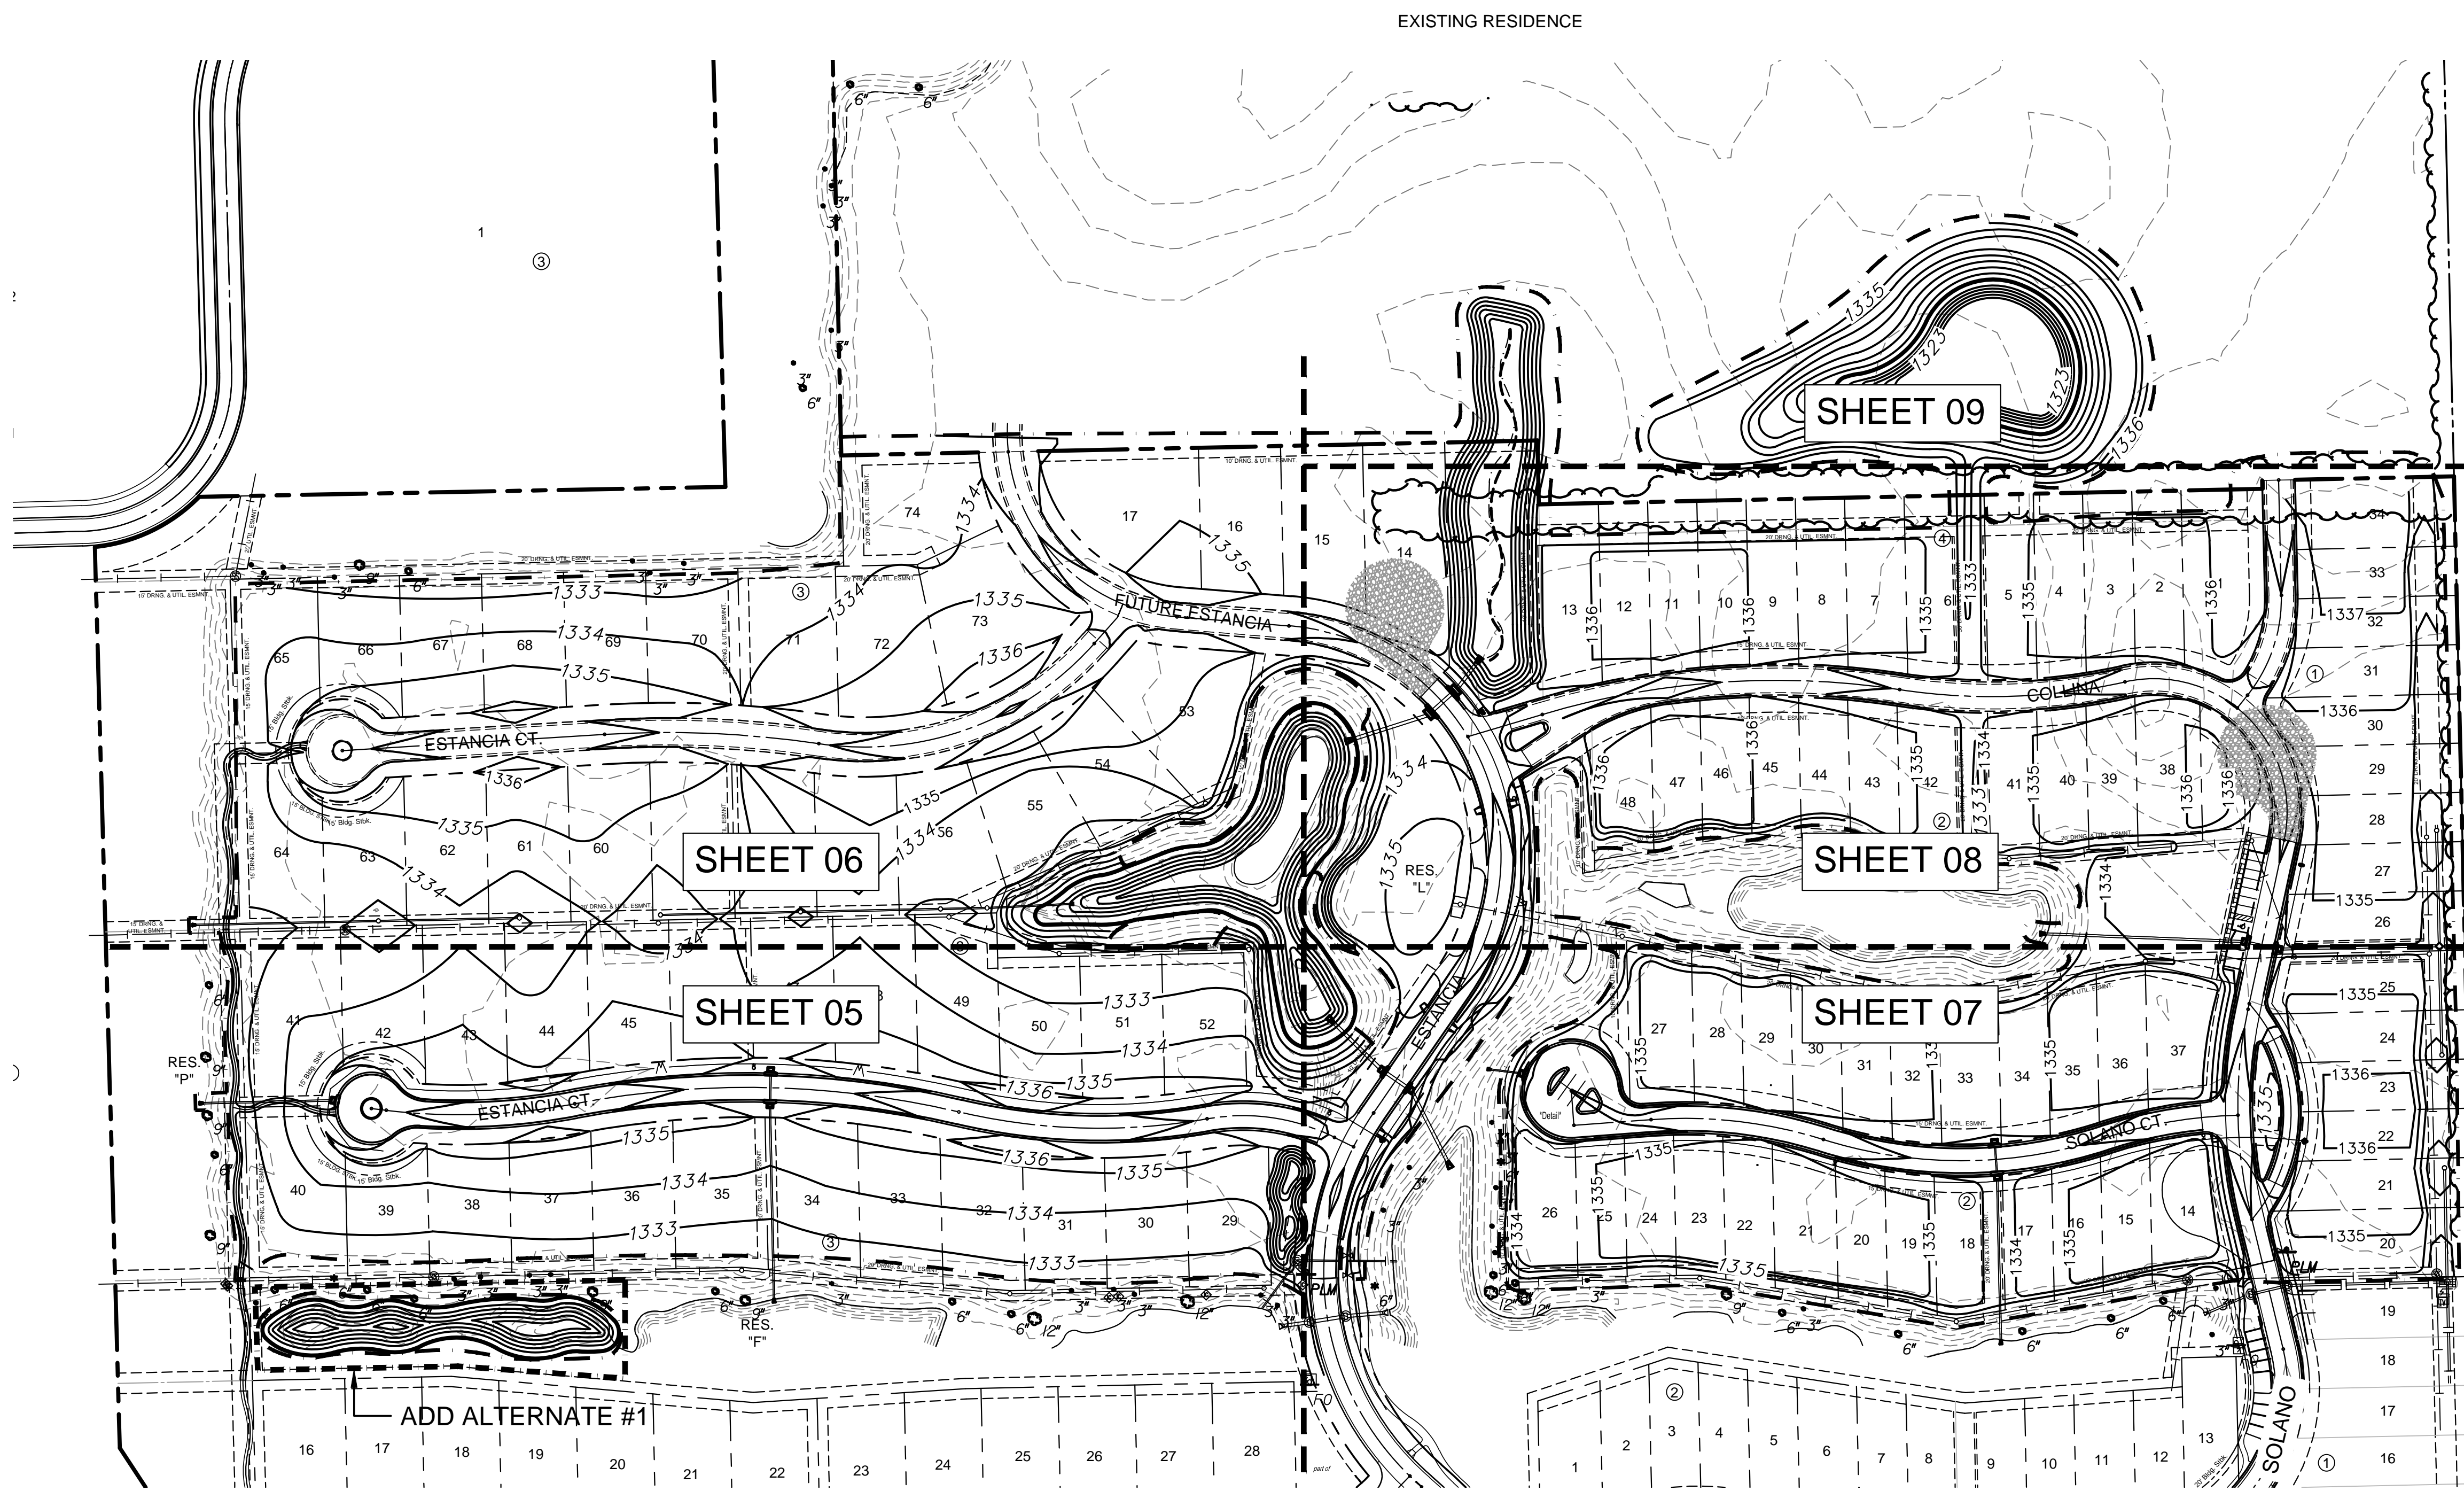

**BORROW AREA**

**LEGEND**

- 1250 - - - EXISTING CONTOUR
- 1250 - - - PROPOSED CONTOUR
- W - - - WATER LINE
- ○ - - - PROP. STORMWATER SEWER
- ○ - - - EXISTING SANITARY SEWER
- ○ - - - EXISTING STORMWATER SEWER
- UGT - - - EXISTING UNDERGROUND TELEPHONE
- UGE - - - EXISTING UNDERGROUND ELECTRICAL
- OHE - - - EXISTING OVERHEAD ELECTRICAL
- - - - - LIMITS OF GRADING

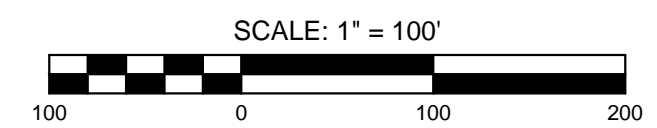

**STORMWATER DRAIN #406**  
**ESTANCIA ADDITION**  
**PHASE 2**

©2017 MKEC Engineering All Rights Reserved www.mkec.com  
 These drawings and their contents, including, but not limited to, all concepts, designs, & ideas are the exclusive property of MKEC Engineering (MKEC), and may not be used or reproduced in any way without the express consent of MKEC.

**OVERALL GRADING PLAN**

PROJECT NO.	468-85071	
DATE	JULY 2017	
SCALE	1" = 100'	
DESIGNED	DRAWN	CHECKED
MLP	MLP	GJA

NO.	REVISION	DATE

SHEET NO.