

WASTEWATER PLANT 2 INFLUENT FORCE MAIN - PHASE 2

IN
THE CITY OF WICHITA, KANSAS

CITY OF WICHITA PROJECT NO. 468-85202

OCA NO. 620860

GARY JANZEN, P.E. - CITY ENGINEER

INDEX OF SHEETS

CIVIL

SHEET NO. CA000	TITLE SHEET
SHEET NO. CA100	KEY MAP AND GENERAL NOTES
SHEET NO. CA101	FORCE MAIN BUBBLE MAP
SHEET NO. CA102	HORIZONTAL AND VERTICAL CONTROL
SHEET NO. CA103	FORCE MAIN COORDINATES
SHEET NO. CA300-CA316	FORCE MAIN LINE NO. 1
SHEET NO. CA317	PLANT NO. 2 SITE DETAIL AND EXISTING UTILITIES
SHEET NO. CA318	CONTROL VALVE ASSEMBLY DETAIL
SHEET NO. CA319	WATERLINE RELOCATION
SHEET NO. CA320	AIR RELIEF VALVE PLAN AND DETAILS
SHEET NO. CA321	LINE VALVE VAULT DETAIL
SHEET NO. CA322	CONTROL VALVE VAULT DETAIL
SHEET NO. CA323	TRACER WIRE & WARNING SIGN FOR SANITARY SEWER FORCE MAIN
SHEET NO. CA324	MISCELLANEOUS DETAILS
SHEET NO. CA325	STANDARD WATER ASSEMBLY DETAIL
SHEET NO. CA326	SWS LINE NOS. 1, 2, & 3
SHEET NO. CA327	48" AND 42" HEADWALL DETAILS
SHEET NO. CA328	CHAPIN PARK ACCESS PLAN
SHEET NO. CA329	BUTTERFLY VALVE REMOVAL 1
SHEET NO. CA330	BUTTERFLY VALVE REMOVAL 2
SHEET NO. CA331	TRAFFIC CONTROL 1
SHEET NO. CA332	TRAFFIC CONTROL 2
SHEET NO. CA333-CA337	TRAFFIC CONTROL DETAILS
SHEET NO. CA400-CA402	SOIL EROSION BMP'S

STRUCTURAL


SHEET NO. SA001	STRUCTURAL GENERAL NOTES - 1
SHEET NO. SA002	STRUCTURAL GENERAL NOTES - 2
SHEET NO. SA003	STRUCTURAL STANDARD DETAILS - 1
SHEET NO. SA101	METER VAULT-STRUCTURAL PLANS
SHEET NO. SA102	METER VAULT-STRUCTURAL SECTIONS
SHEET NO. SA300	STRUCTURAL GENERAL NOTES-VALVE VAULTS
SHEET NO. SA301	STRUCTURAL PLANS AND DETAILS AIR RELIEF VALVE VAULT
SHEET NO. SA302	STRUCTURAL PLANS AND DETAILS LINE VALVE VAULT
SHEET NO. SA303	STRUCTURAL PLANS AND DETAILS CONTROL VALVE VAULT

MECHANICAL

SHEET NO. MA101	METER VAULT PLANS AND SECTIONS
-----------------	--------------------------------

ELECTRICAL

SHEET NO. EA001	ELECTRICAL LEAD SHEET
SHEET NO. EA002	CONTROL SCHEDULE
SHEET NO. EA101	ELECTRICAL DETAILS
SHEET NO. EA201	ELECTRICAL SITE PLAN

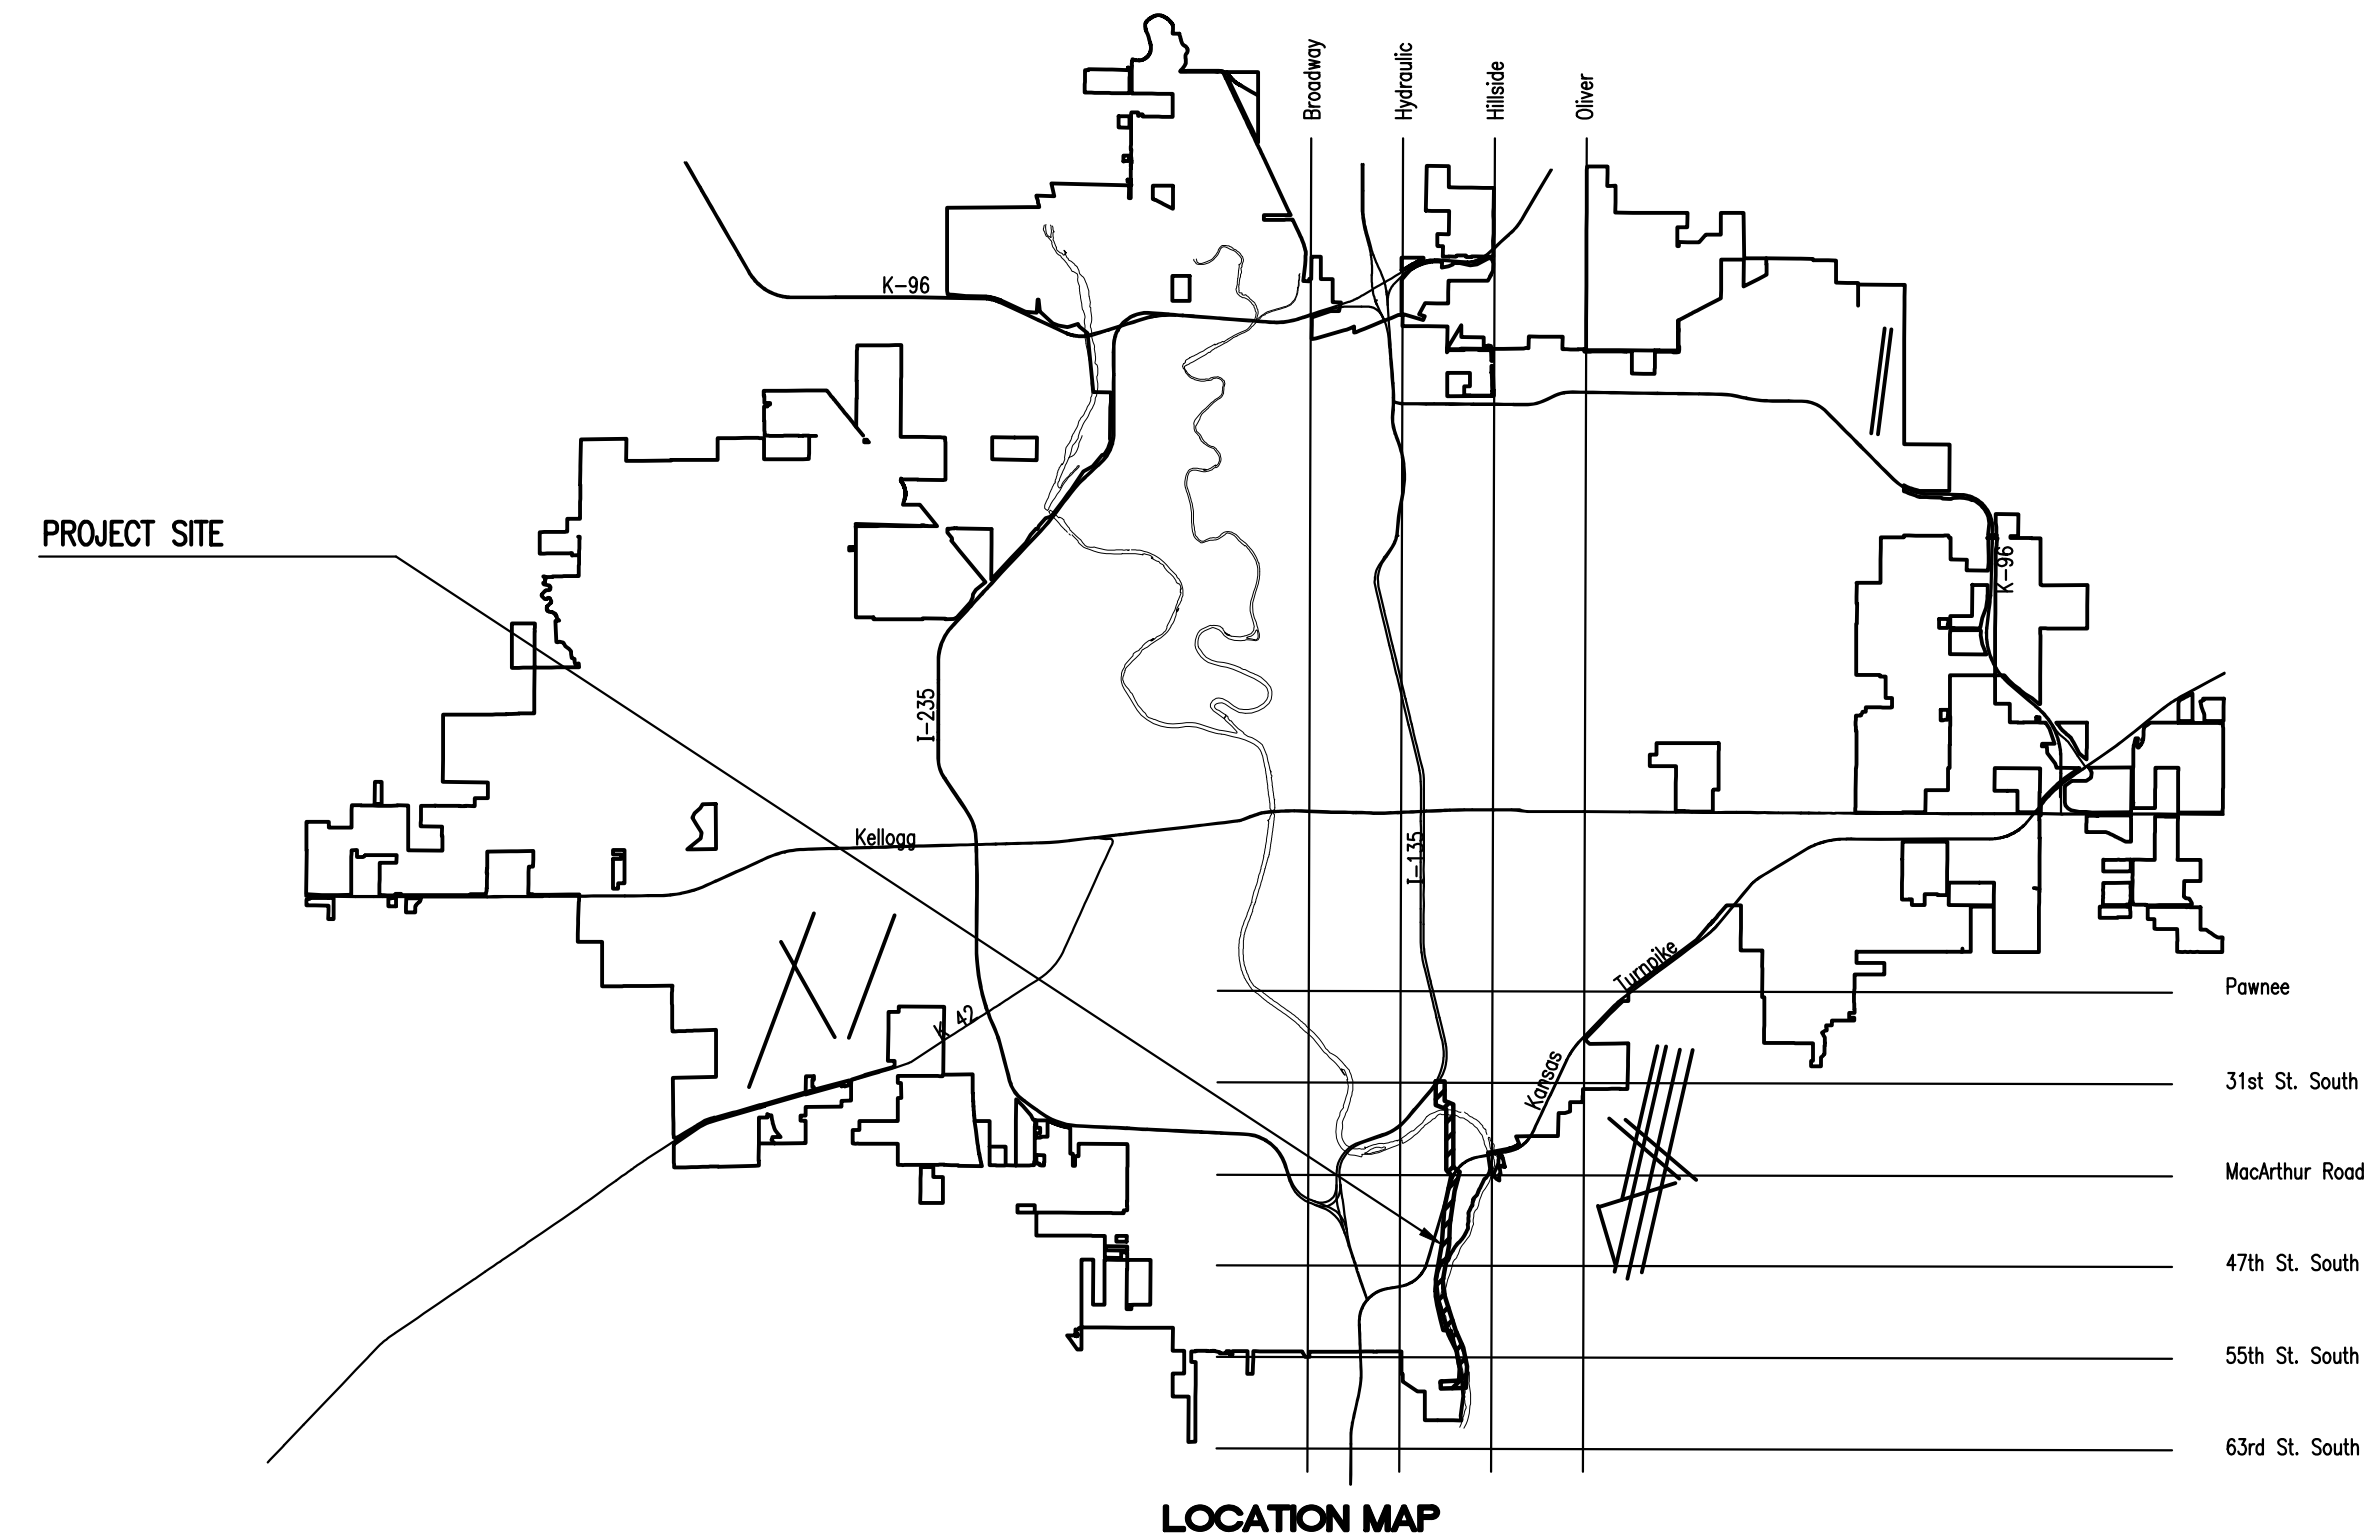

JULY 2017

PLANS PREPARED BY
PROFESSIONAL ENGINEERING CONSULTANTS, P.A.
ENGINEERS
WICHITA, KANSAS

