
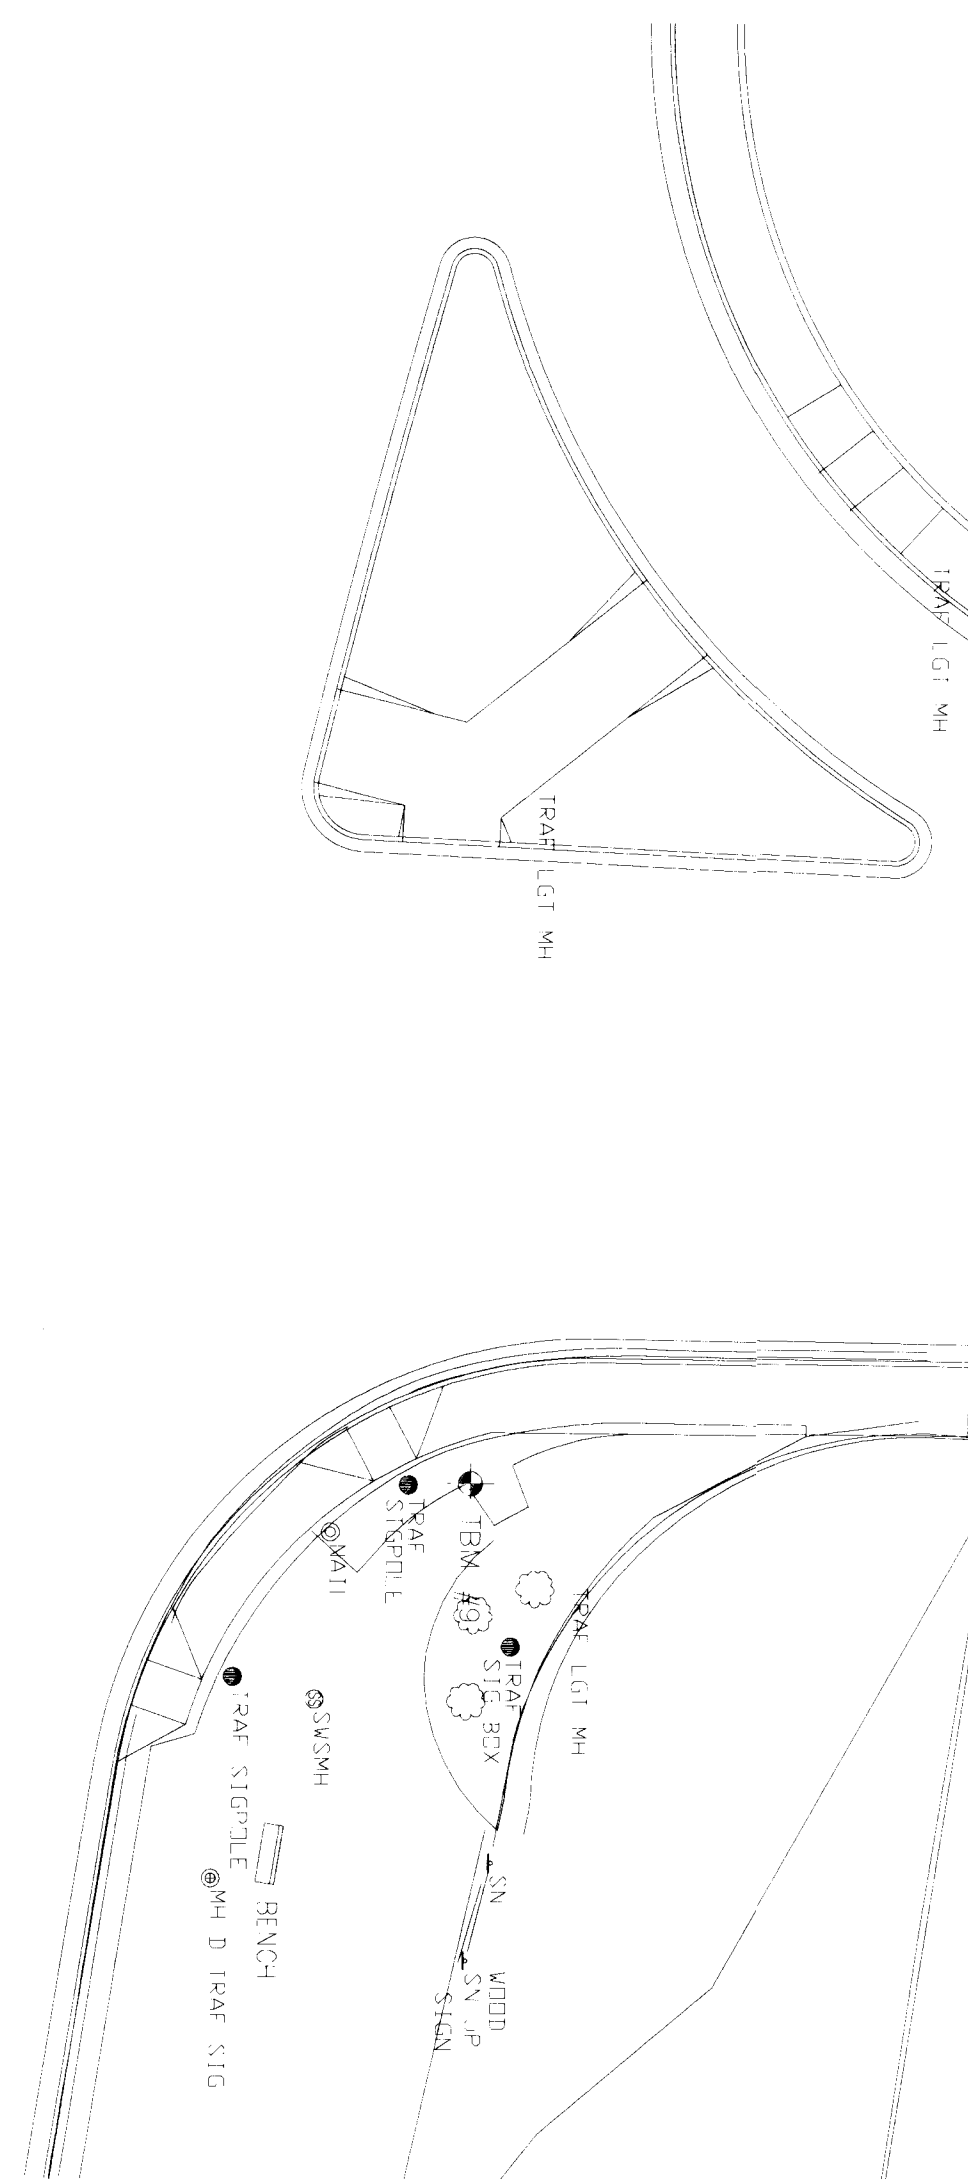
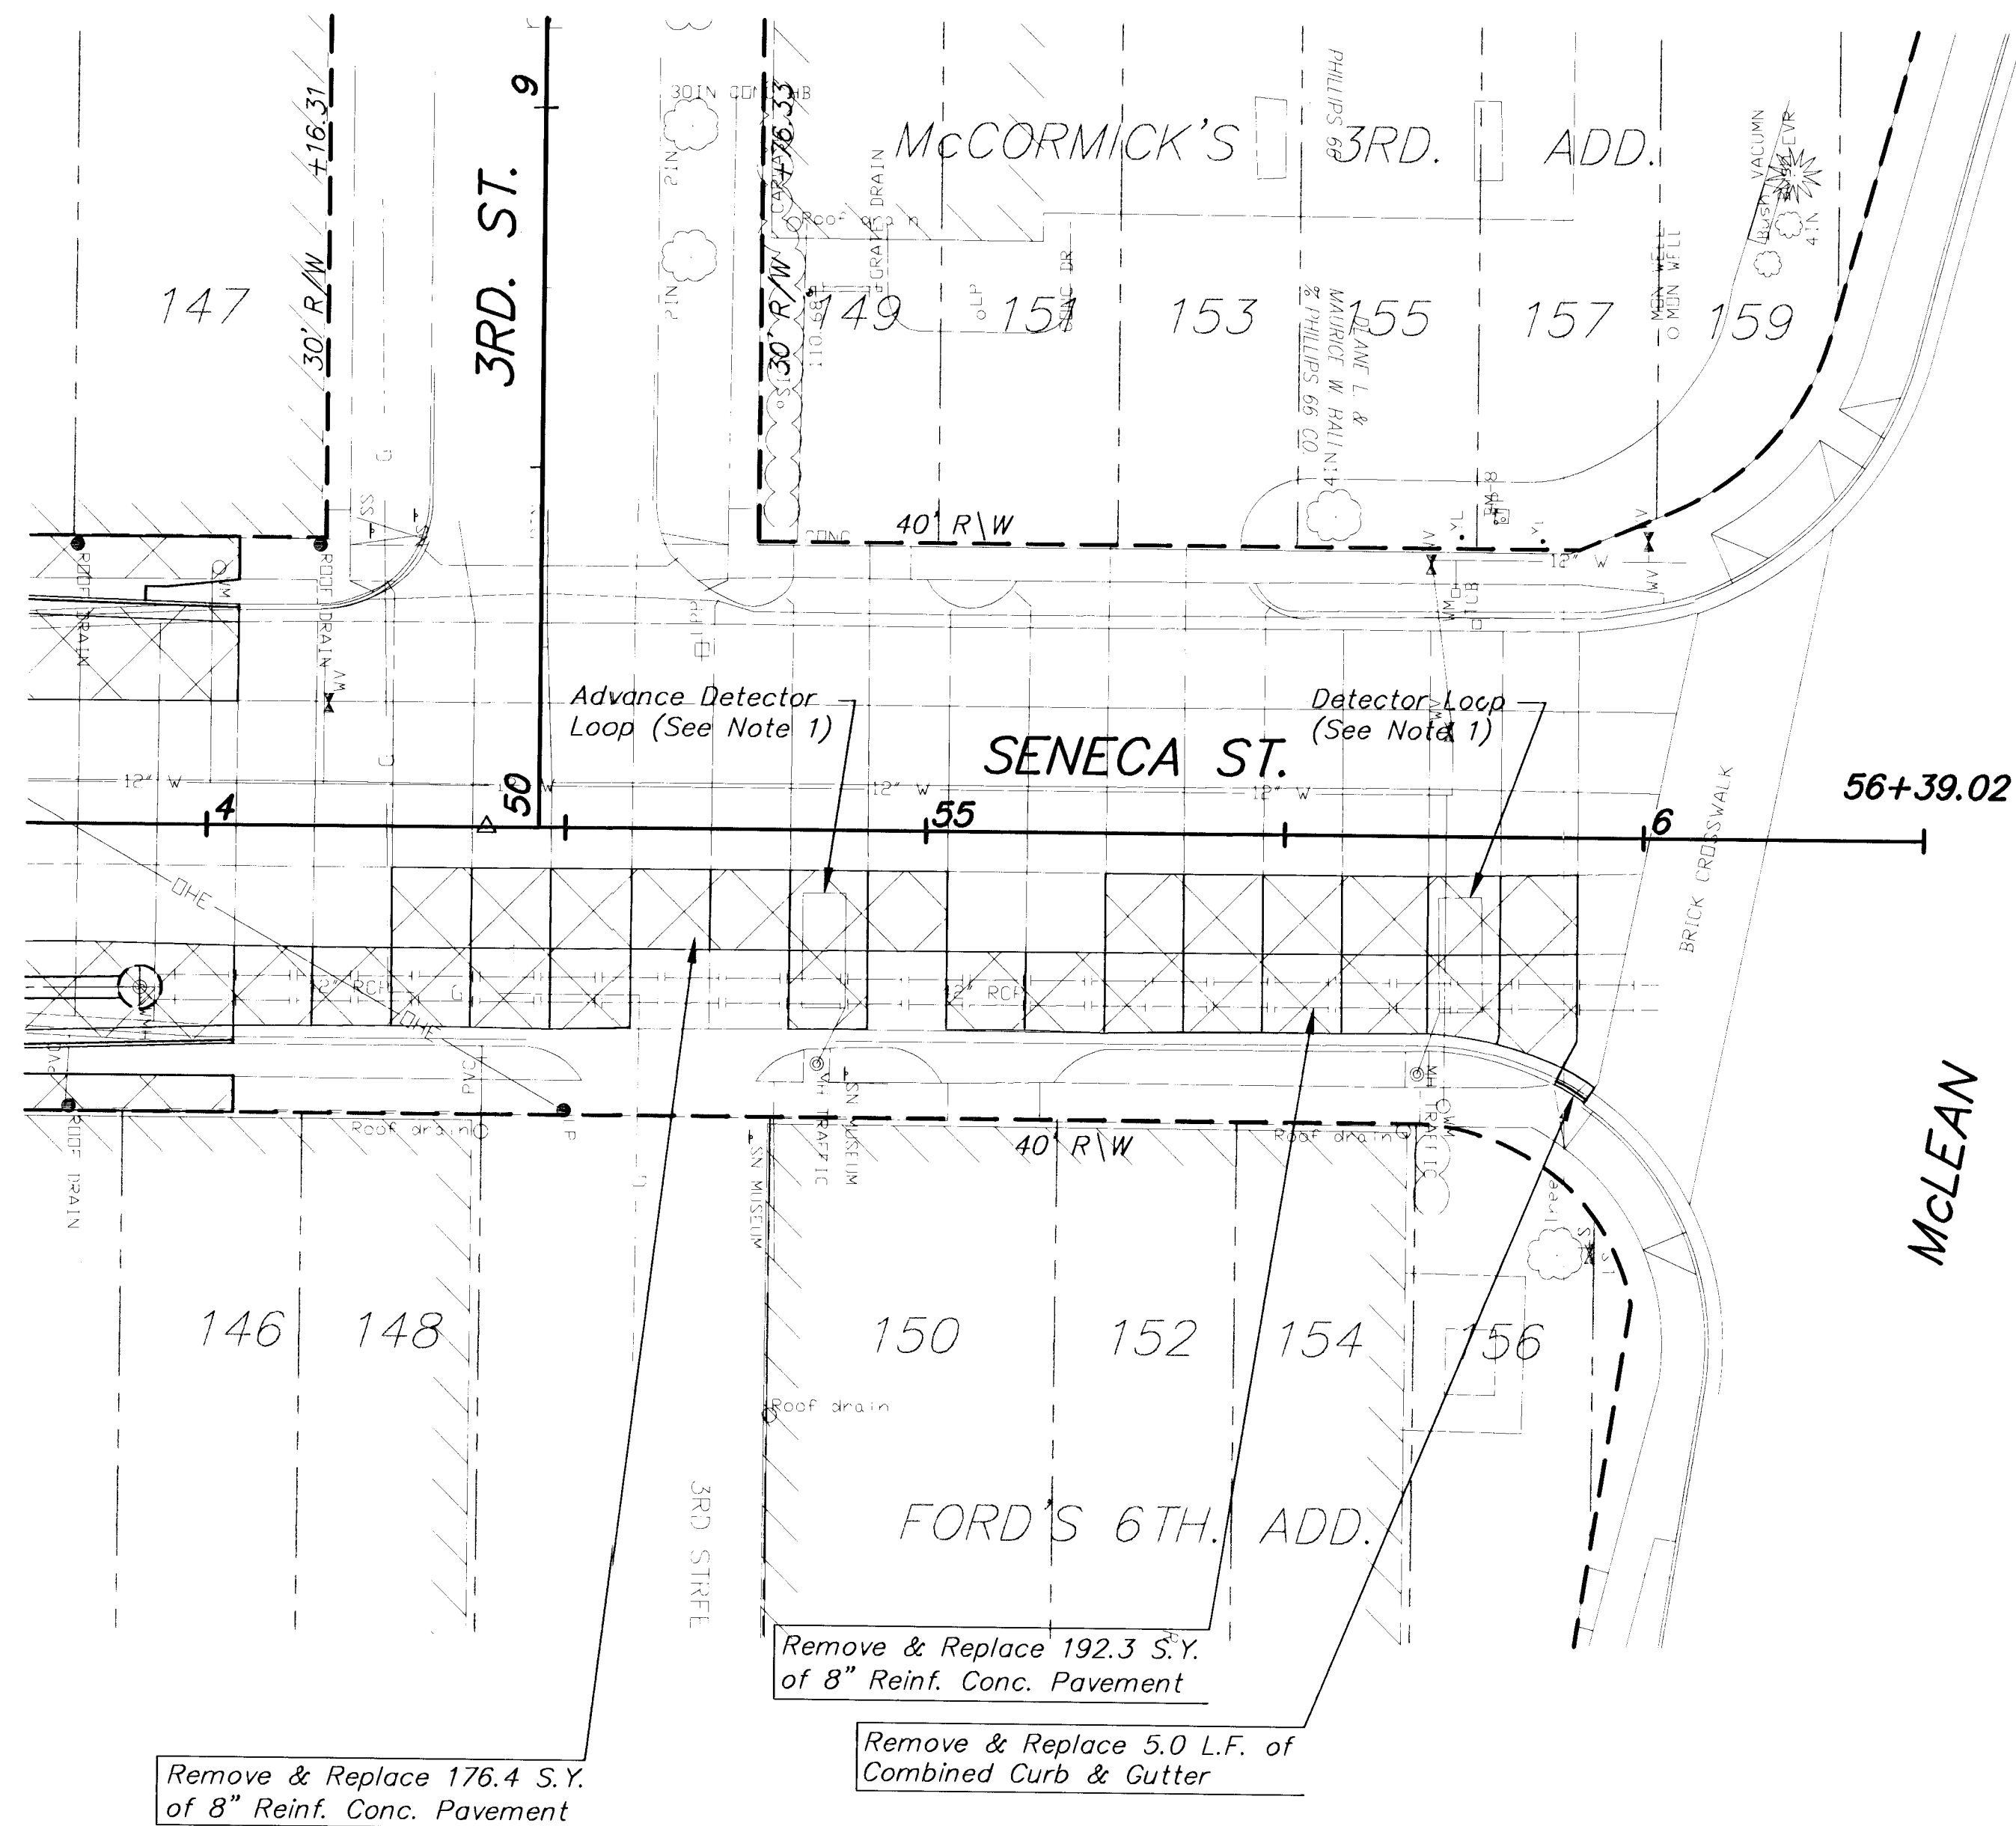


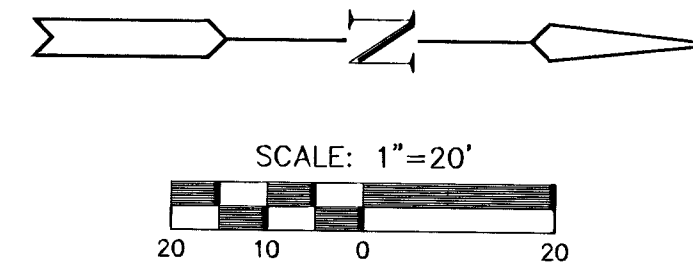

- Notes;
1. Replace detector loop, junction Box, conduit, wiring, and appurtenances in like kind. A continuous run of 2/c #14 shall be provided from junction box to McLean signal controller. Notify Jim Parks, Signal Supervisor, 268-4033, 48 hours prior to disconnecting from circuits and when reconnecting.
 2. Contractor to recompact subgrade where panels are removed and replaced. Compaction shall be subsidiary to 8" concrete pavement.

LEGEND

Drive, Pavement and/or Sidewalk Removal

MKEC
ENGINEERING CONSULTANTS
411 N. WEBB ROAD
WICHITA, KS. 67208
316-684-9600

SENECA STREET
PROJECT NAME

PAVING PLANS
SHEET TITLE

DCH DESIGN BY:	WNJ DRAWN BY:	GJA CHECKED BY:
OCT. 2001 DATE	98092_E7 DRAWING NAME	16 / 87 SHEET / OF