


LAYOUT PLAN

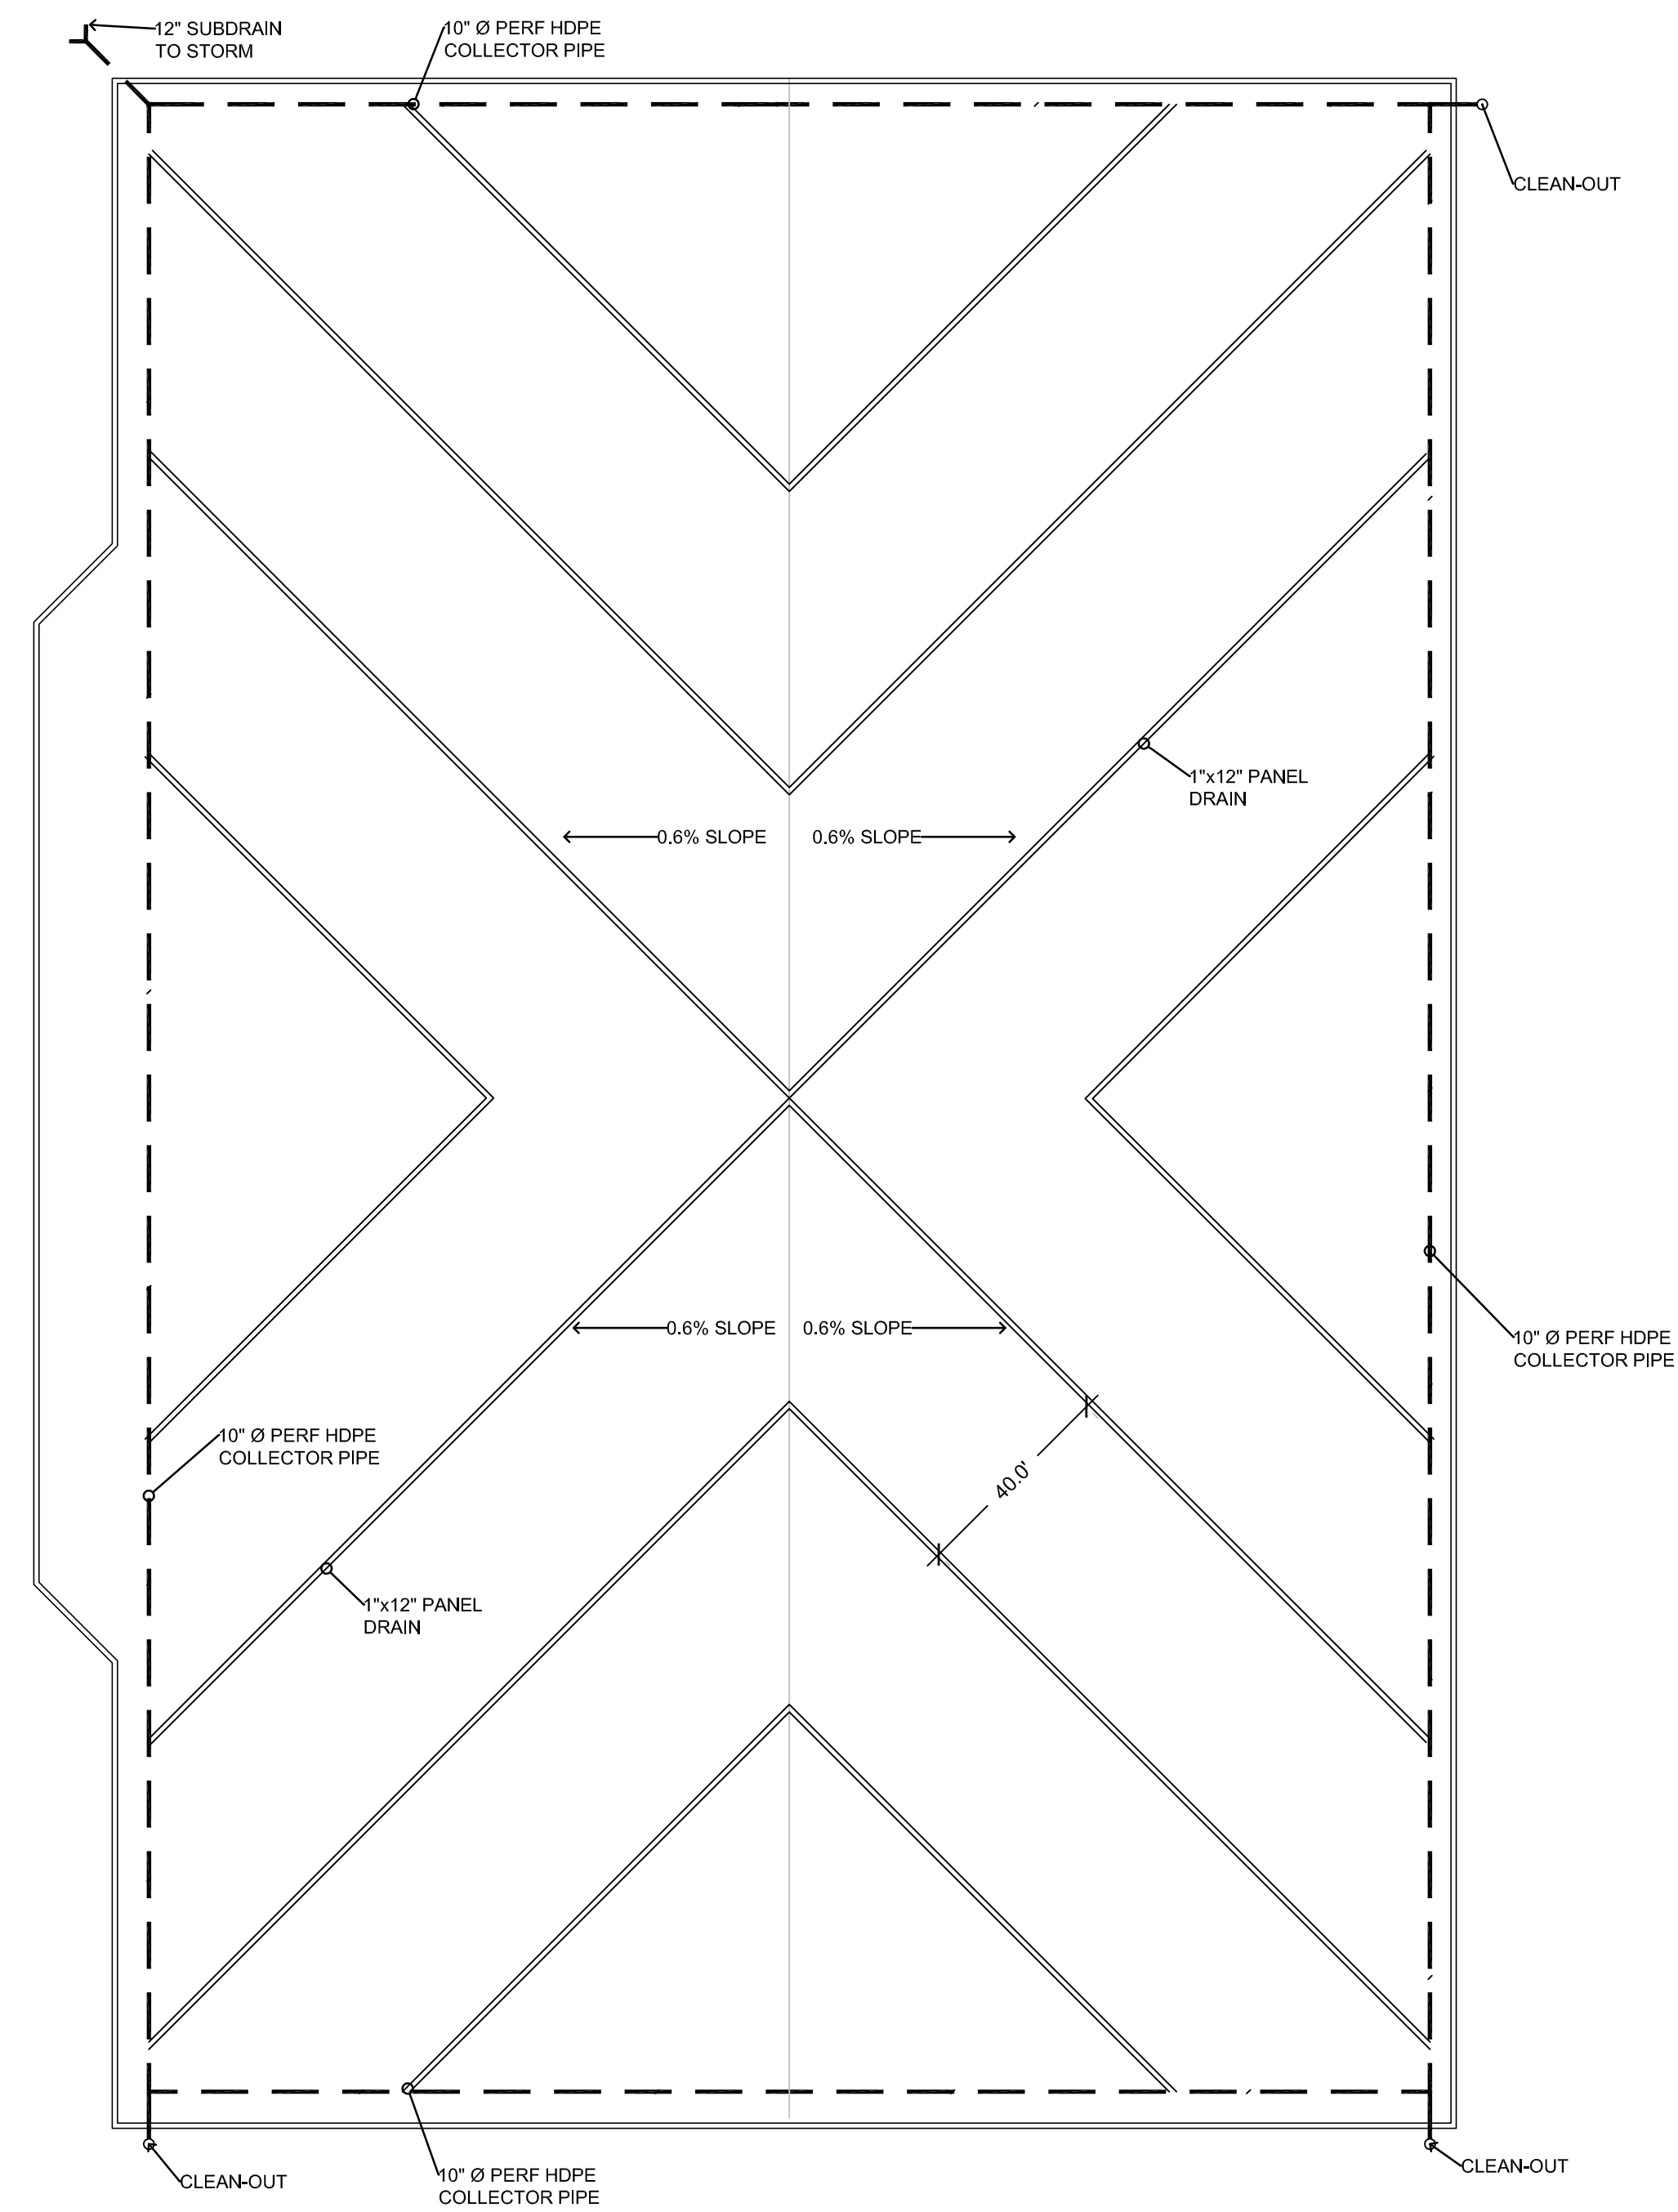

DRAINAGE PLAN

PLOTTED: Wednesday, November 01, 2017 @ 08:14PM

M:\PROJECTS\2017\1701010567\CITY OF WICHITA\STRYKER SPORTS COMPLEX\GRAPHICS\CAD\PLANS.DWG

HLXON CHAMPIONSHIP FIELD LAYOUT

©2017
 MKEC Engineering
 All Rights Reserved
 www.mkec.com
 These drawings and their contents, including, but not limited to, all concepts, designs, & ideas are the exclusive property of MKEC Engineering (MKEC), and may not be used or reproduced in any way without the express consent of MKEC.

CHAMPIONSHIP
 FIELD LAYOUT

PROJECT NO.	1701010567
DATE	11-01-17
SCALE	1"=30'
DESIGNED	JLE
DRAWN	JLE
CHECKED	JLE

NO.	REVISION	DATE
0	TURF PROC. - IFC	11-01-17

SHEET NO.
 LA1.001