


©2017
 MKEC Engineering
 All Rights Reserved
 www.mkec.com
 These drawings and their contents, including, but not limited to, all concepts, designs, & ideas are the exclusive property of MKEC Engineering (MKEC), and may not be used or reproduced in any way without the express consent of MKEC.

**REGULAR
 FIELD LAYOUT**


PROJECT NO.	1701010567	
DATE	11-01-17	
SCALE	1"=30'	
DESIGNED	DRAWN	CHECKED
JLE	JLE	JLE

NO.	REVISION	DATE
0	TURF PROC. - IFC	11-01-17

SHEET NO.
 LA1.002

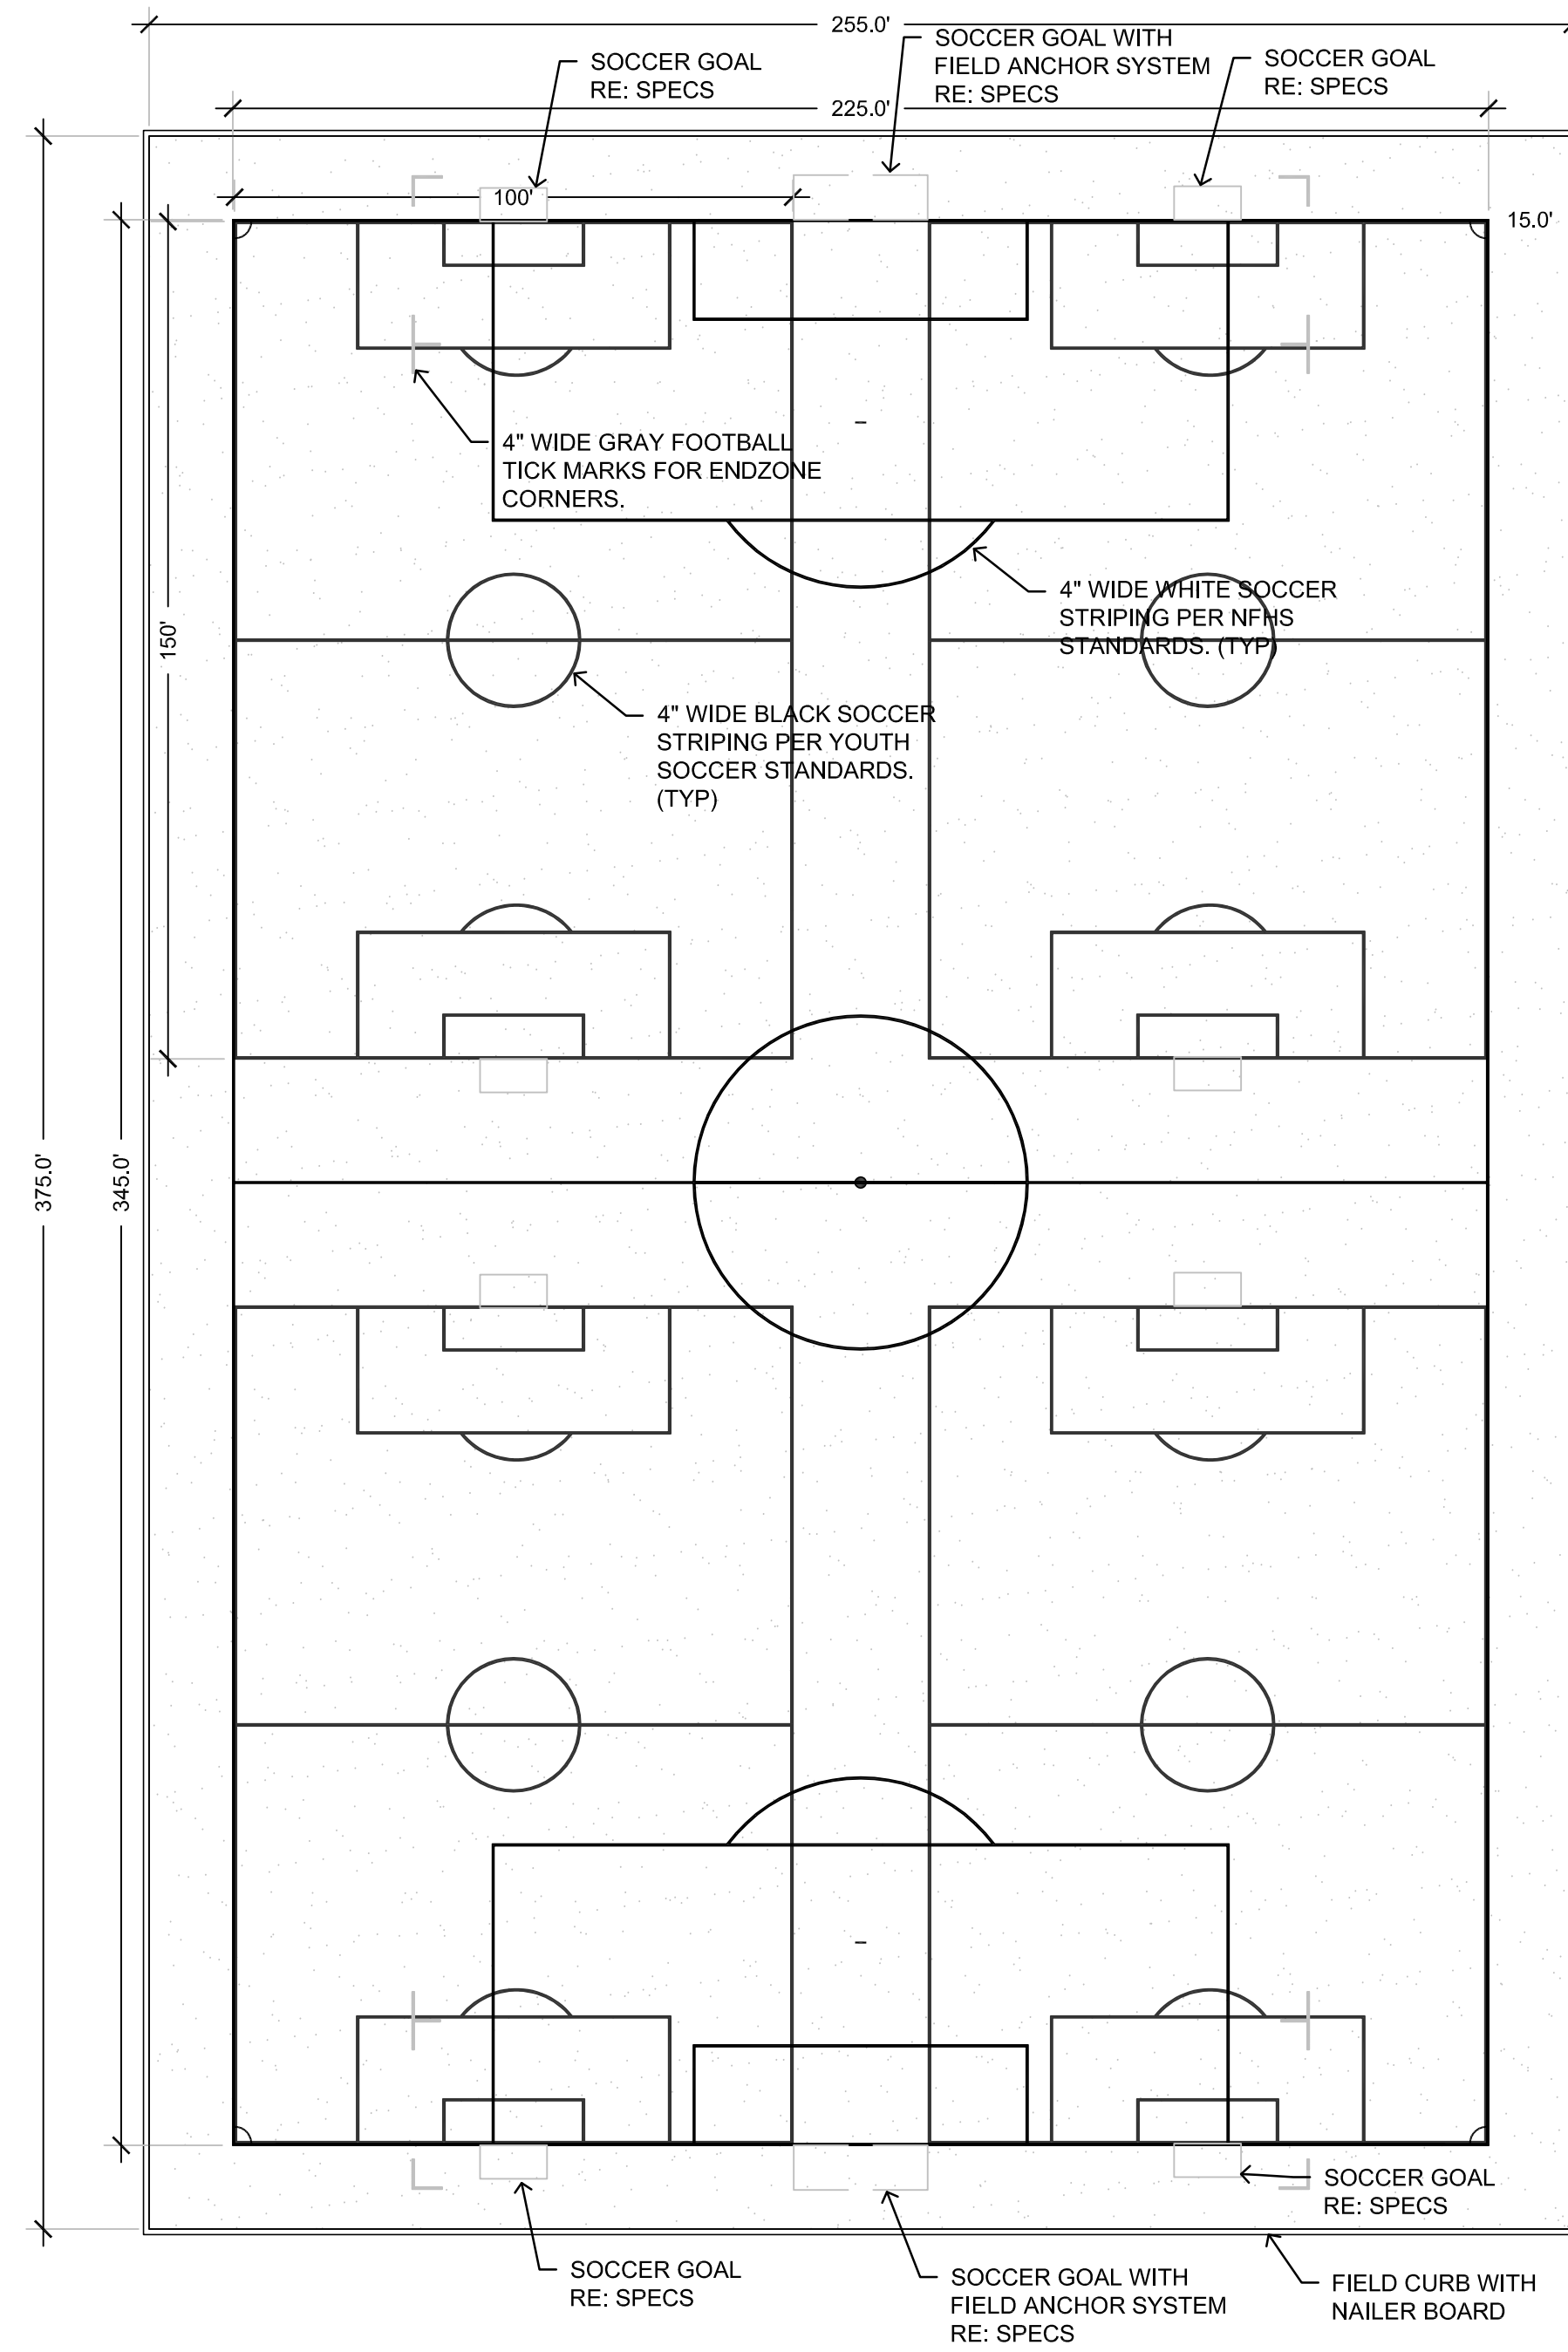

LAYOUT PLAN

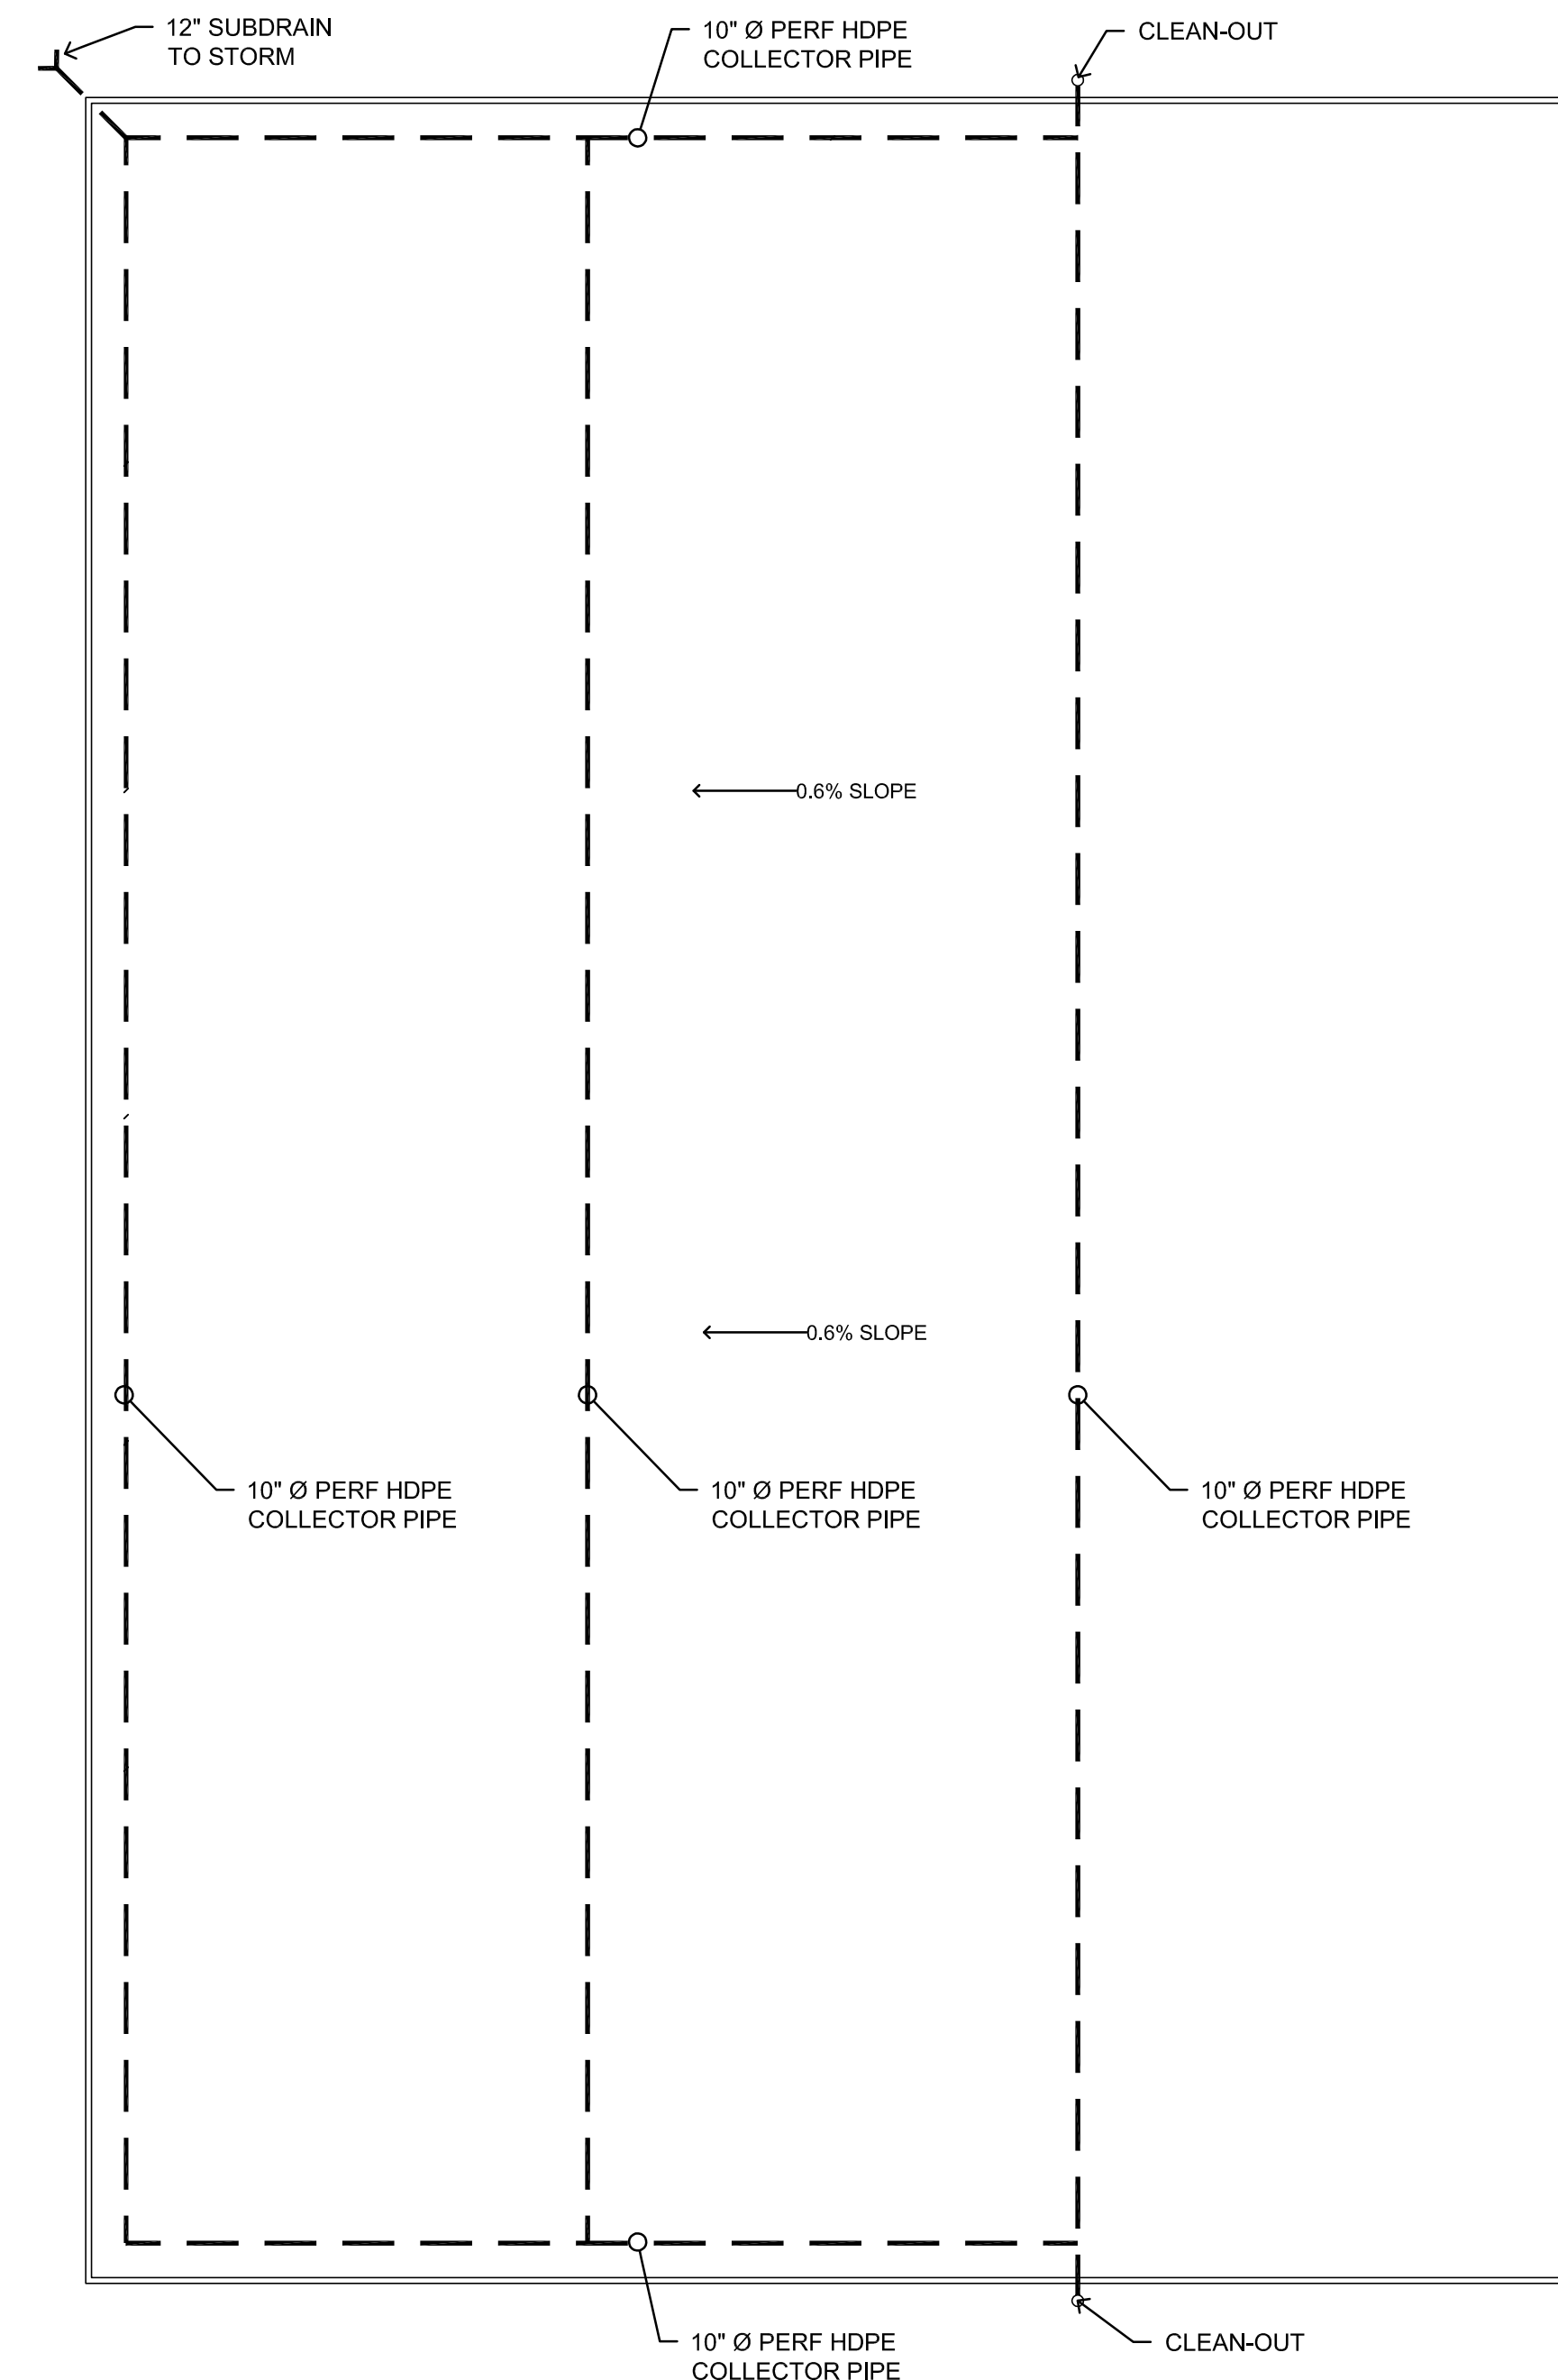

DRAINAGE PLAN

PLOTTED: Wednesday, November 01, 2017 @ 08:18PM
 M:\PROJECTS\2017\1701010567\CITY OF WICHITA\STRYKER SPORTS COMPLEX\GRAPHICS\CAD\TODAYS

REGULAR FIELD LAYOUT