



J:\PROJECTS\2017\1601010317 - PERFECTION COURTYARDS AT BROOKFIELD, 16317 CADSHS06 CIVIL\GRD\16317-GD-01-04.DWG
 PLOTTED: Wednesday, December 13, 2017 @ 09:29AM

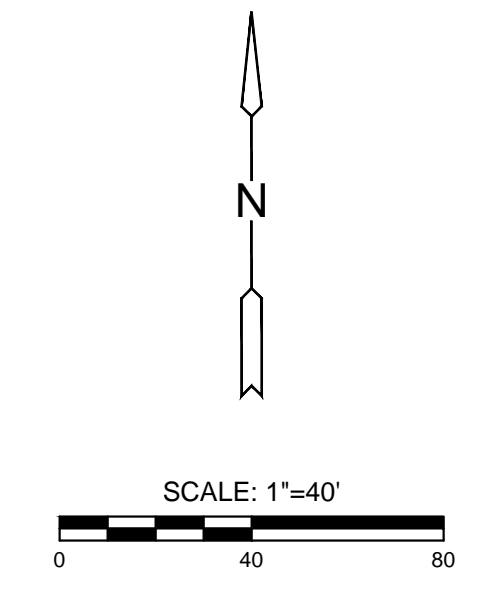

GRADING PLANS FOR
COURTYARDS AT BROOKFIELD ADD.

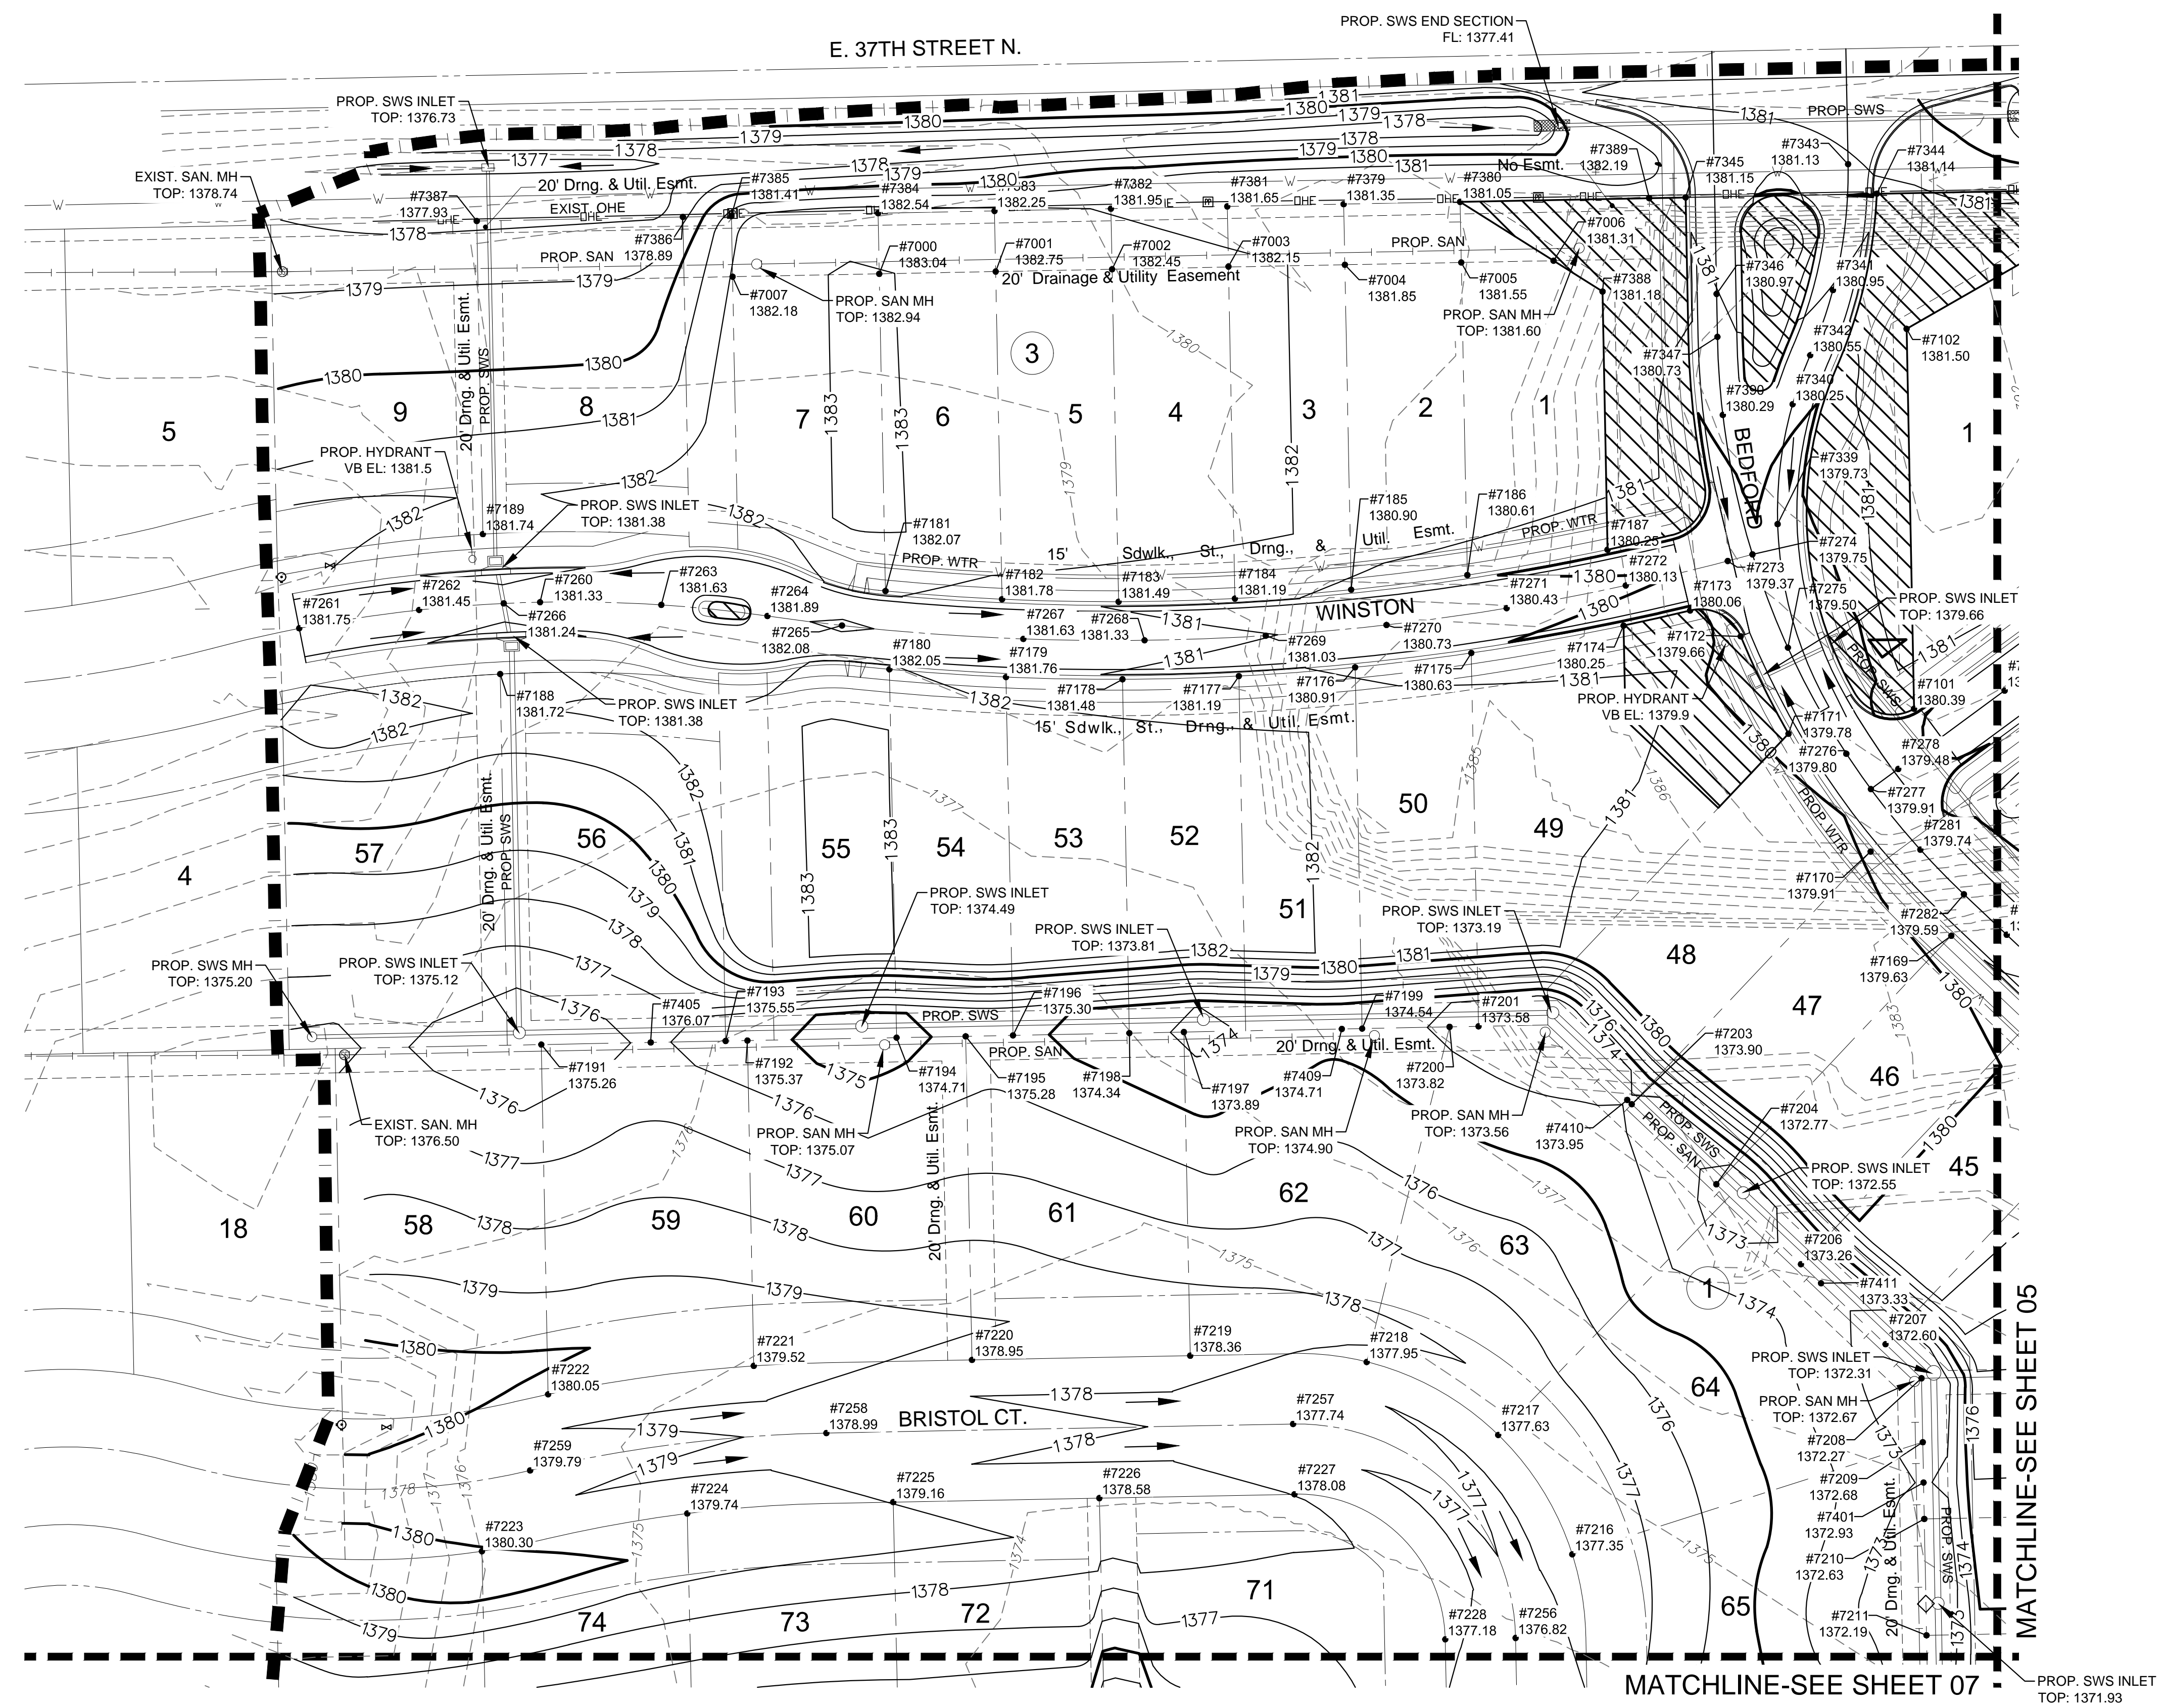

LEGEND

	1250	EXISTING CONTOUR
	1250	PROPOSED CONTOUR
	W	WATER LINE
		STORM WATER SEWER
		SANITARY SEWER
		EXISTING STORMWATER SEWER
	UGT	EXISTING UNDERGROUND TELEPHONE
	UGE	EXISTING UNDERGROUND ELECTRICAL
	OHE	EXISTING OVERHEAD ELECTRICAL
		LIMITS OF GRADING
	#xxxx 1372.27	COORDINATE POINT & SPOT ELEVATION (SEE SHEETS 11-## FOR COORDINATE TABLES)
		12" TOPSOIL (SEE DETAIL 2, SHEET 02) COST SUBSIDIARY TO PROJECT

NOTE: ONLY REMOVE TREES WHEN NECESSARY. REFER TO TREE TRIMMING DETAILS ON SHEET 02.

©2017 MKEC Engineering All Rights Reserved www.mkec.com
 These drawings and their contents, including, but not limited to, all concepts, designs, & ideas are the exclusive property of MKEC Engineering (MKEC), and may not be used or reproduced in any way without the express consent of MKEC.

GRADING PLAN 01		
PROJECT NO.	468-85265	
DATE	DEC. 2017	
SCALE	1"=40'	
DESIGNED	DRAWN	CHECKED
DFL	JWC	GJA
NO.	REVISION	DATE
SHEET NO. 04 OF 18		