



PLOTTED: Tuesday, December 12, 2017 @ 02:57PM

EVERY ATTEMPT HAS BEEN MADE TO INSURE ALL COORDINATE VALUES SHOWN ARE AN ACCURATE AND TRUE REPRESENTATION OF THE CURRENT PLANS. ALL VALUES ARE TO BE CONFIRMED WITH THE FINAL SIGNED PLAN SET BEFORE USE.

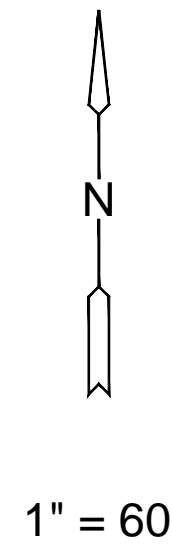

GRADING PLANS FOR COURTYARDS AT BROOKFIELD ADD.

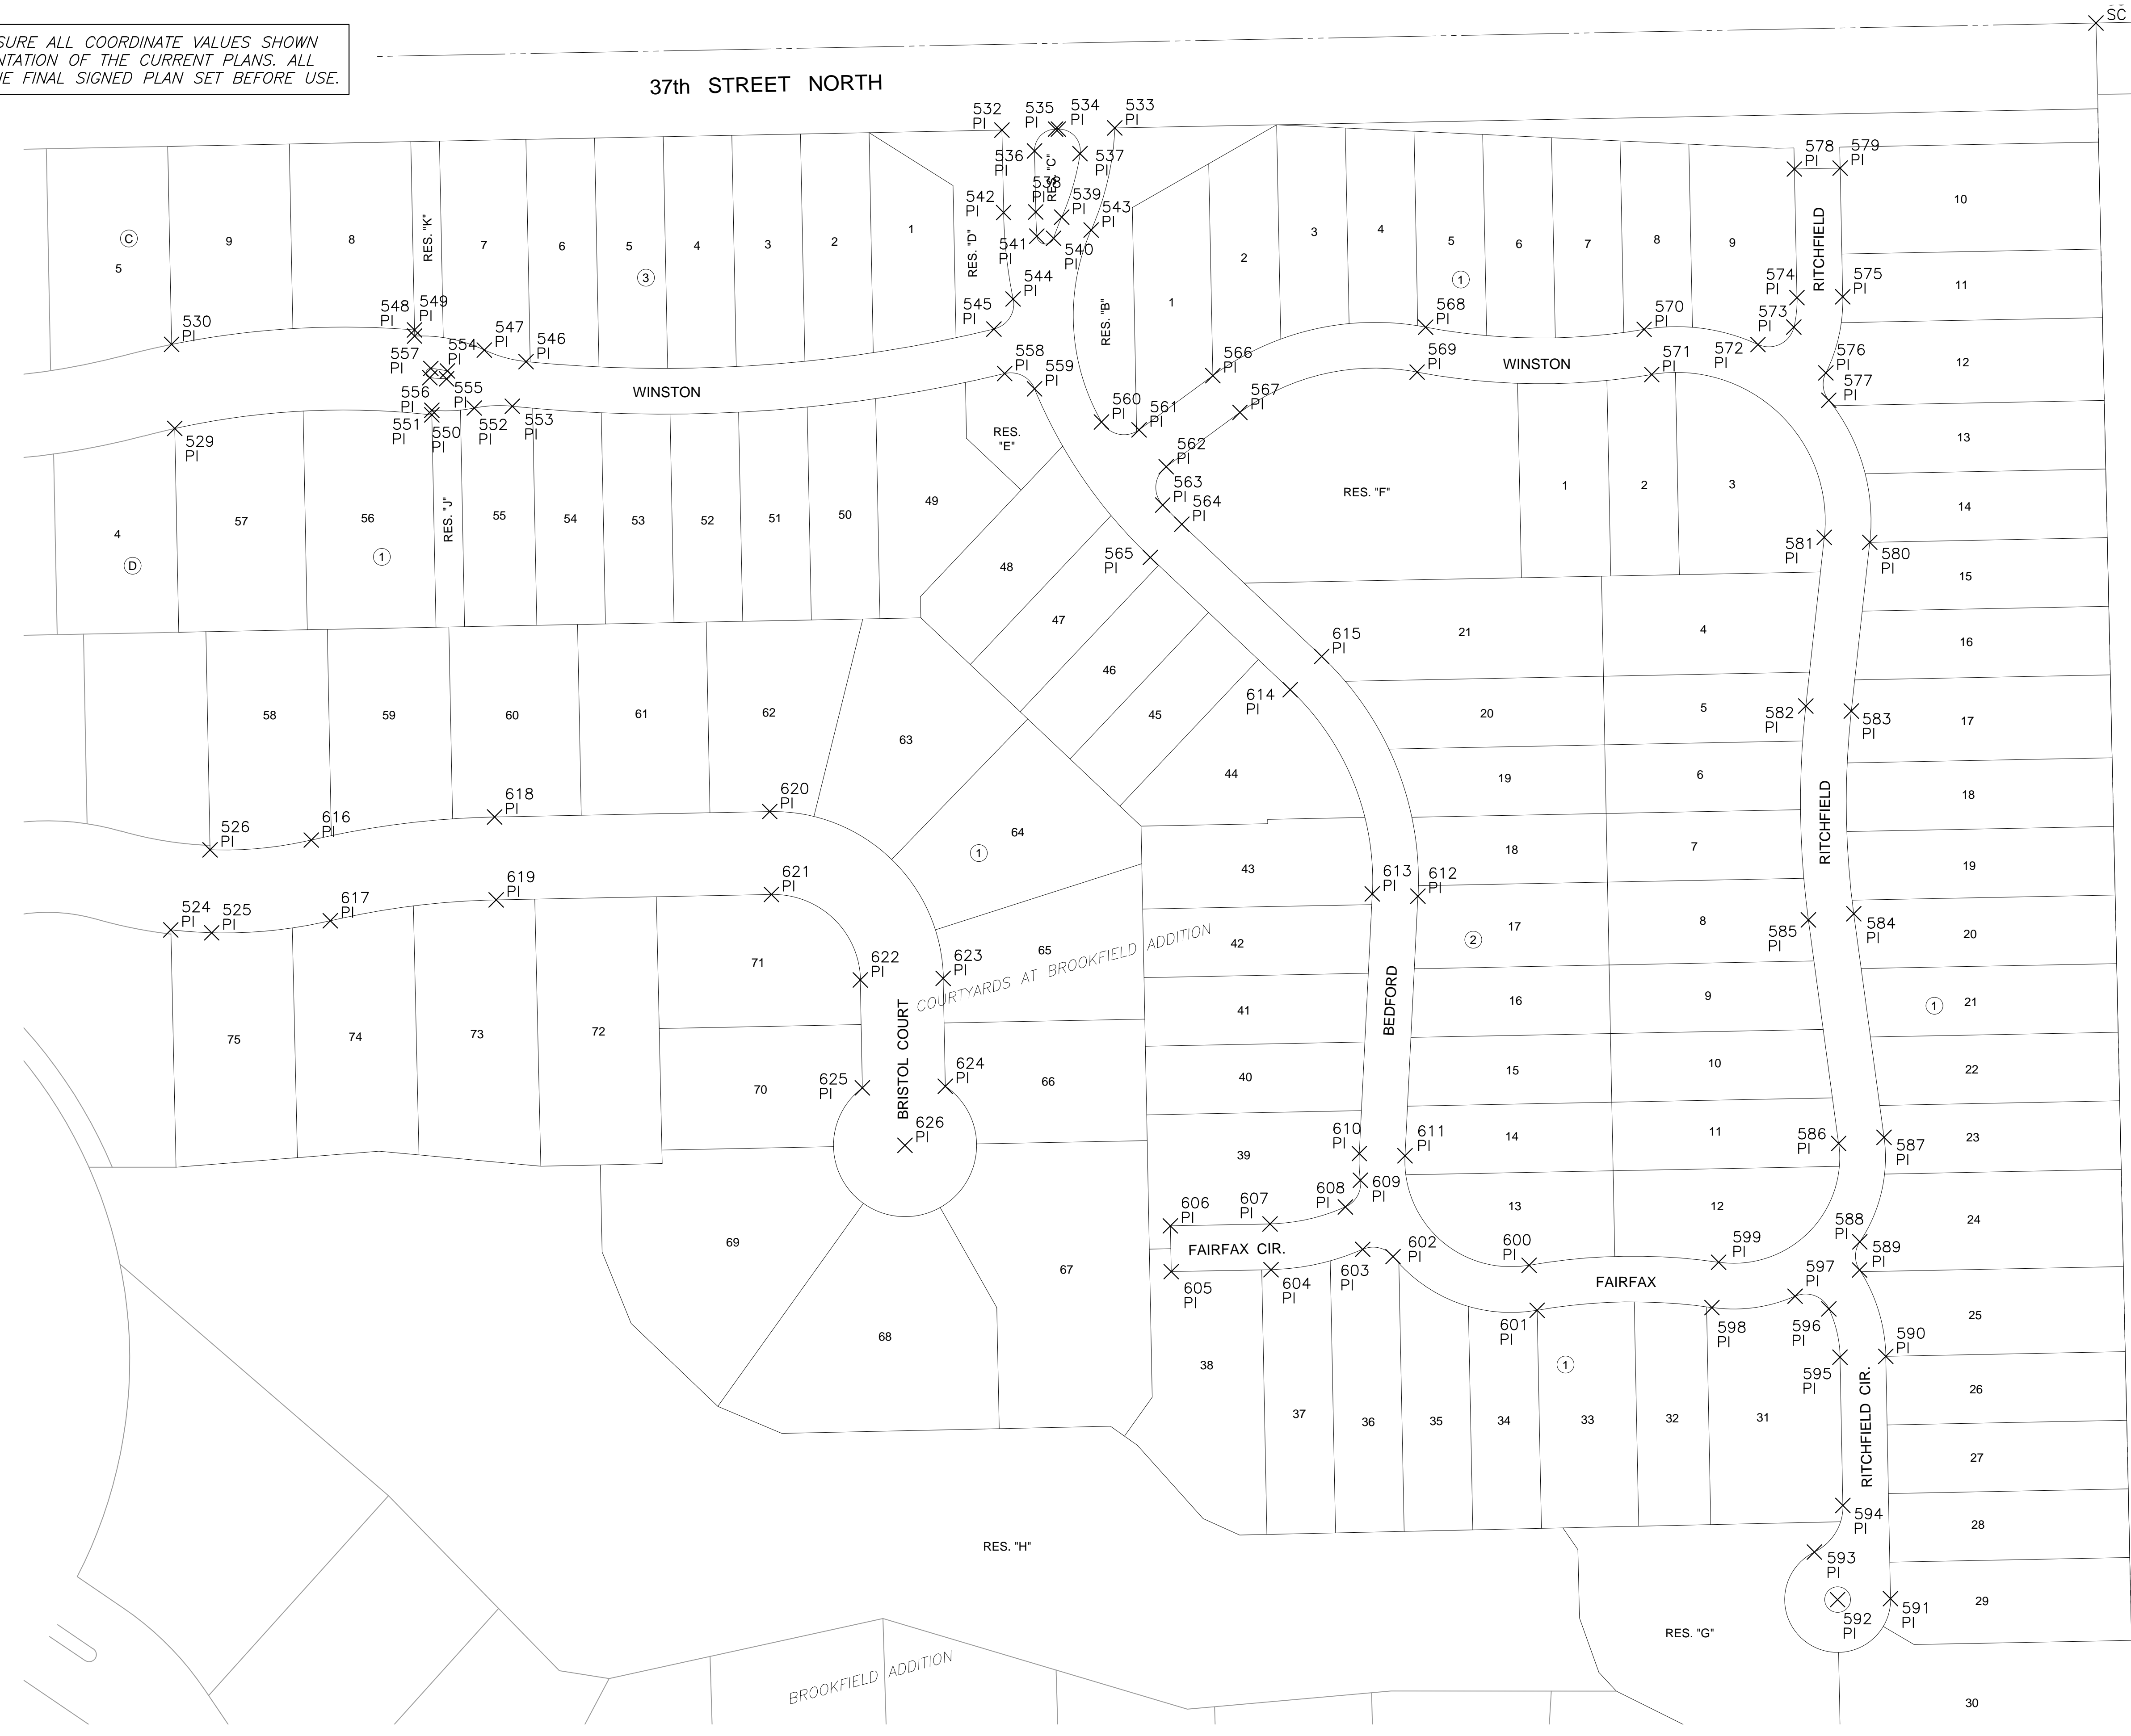

J:\PROJECTS\2017\1601010317_PERFECTION_COURTYARDS AT BROOKFIELD, 16317 CAD\SHS\06 CIVIL\GRD\16317-GB-01.DWG

©2017 MKEC Engineering All Rights Reserved
www.mkec.com
These drawings and their contents, including, but not limited to, all concepts, designs, & ideas are the exclusive property of MKEC Engineering (MKEC), and may not be used or reproduced in any way without the express consent of MKEC.

BUBBLE MAP

PROJECT NO.	468-85265				
DATE	DEC. 2017				
SCALE	1" = 60'				
DESIGNED	DFL	DRAWN	JWC	CHECKED	GJA

NO.	REVISION	DATE

SHEET NO.
10 OF 18