

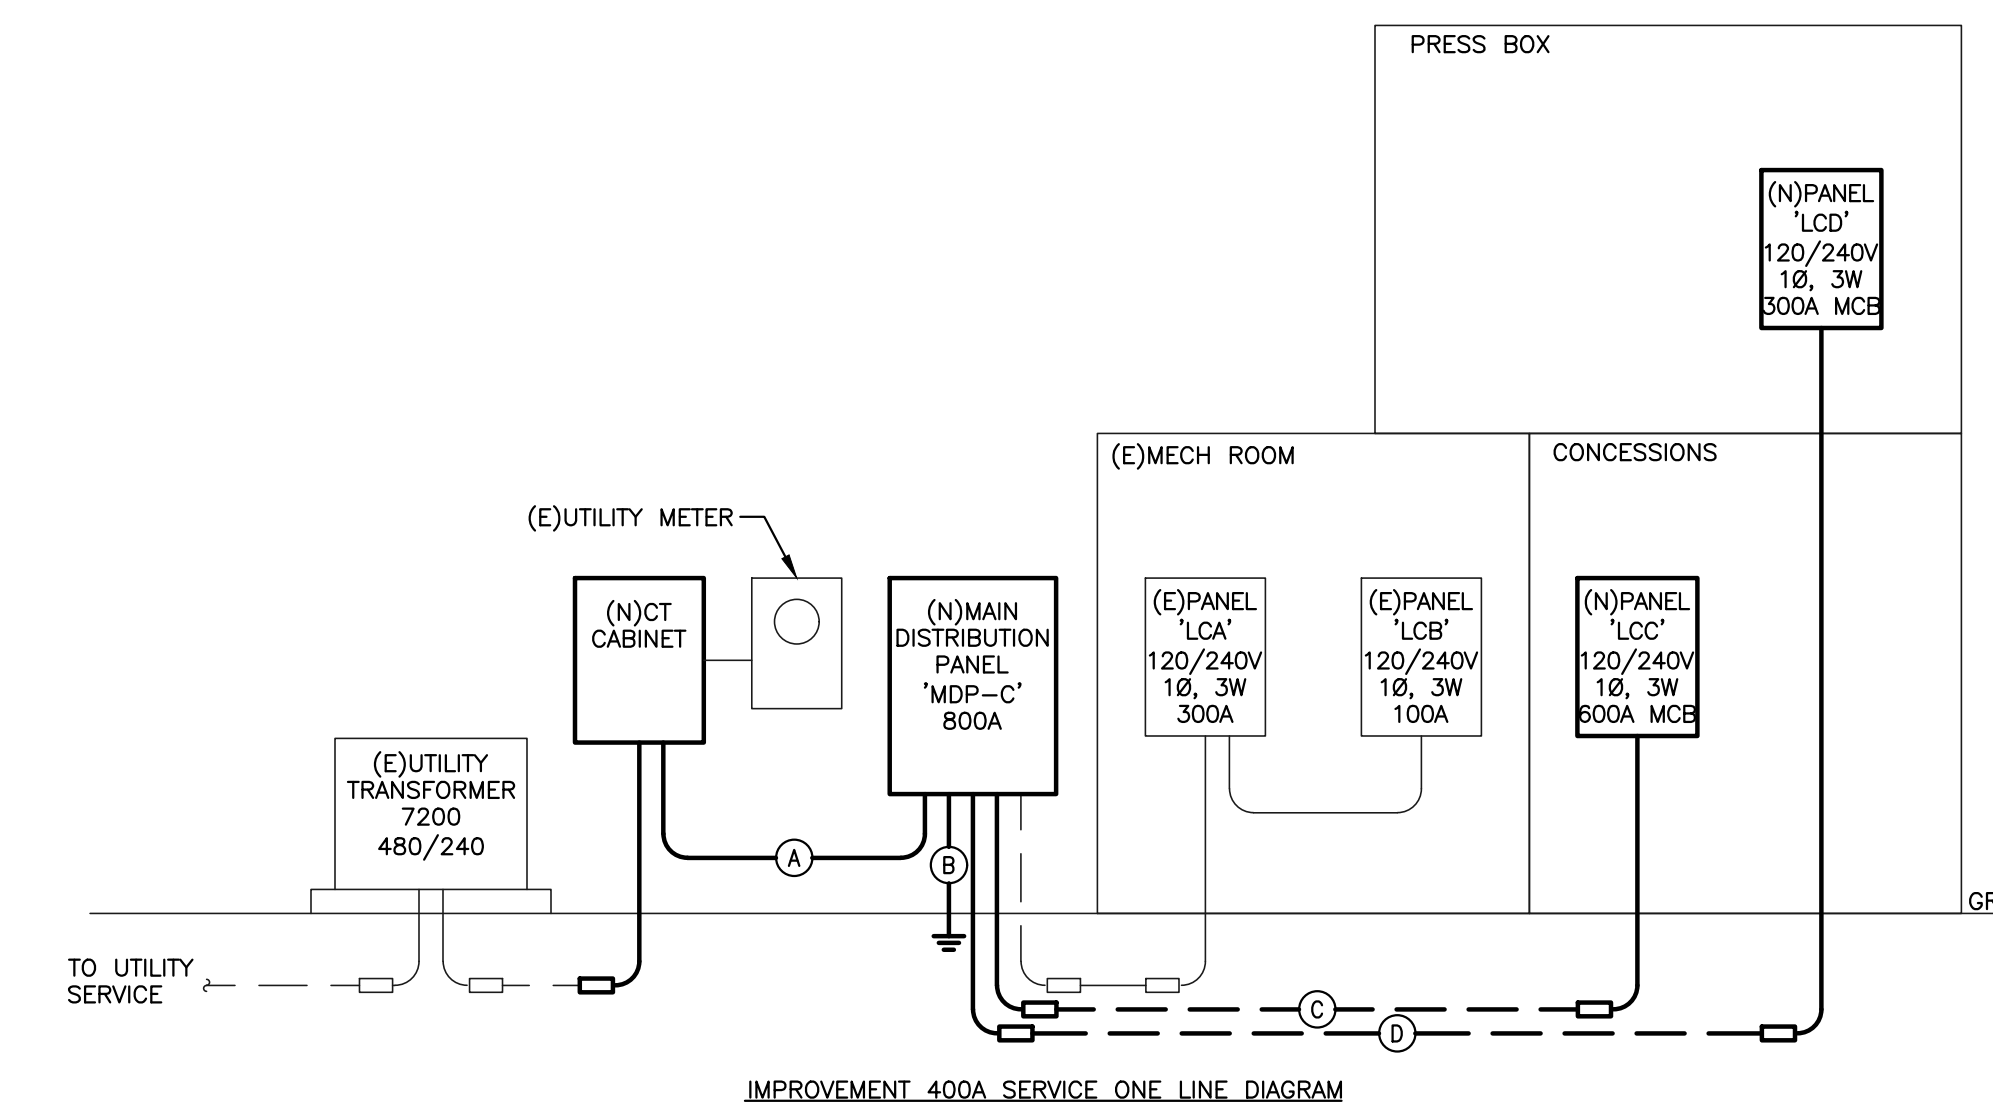
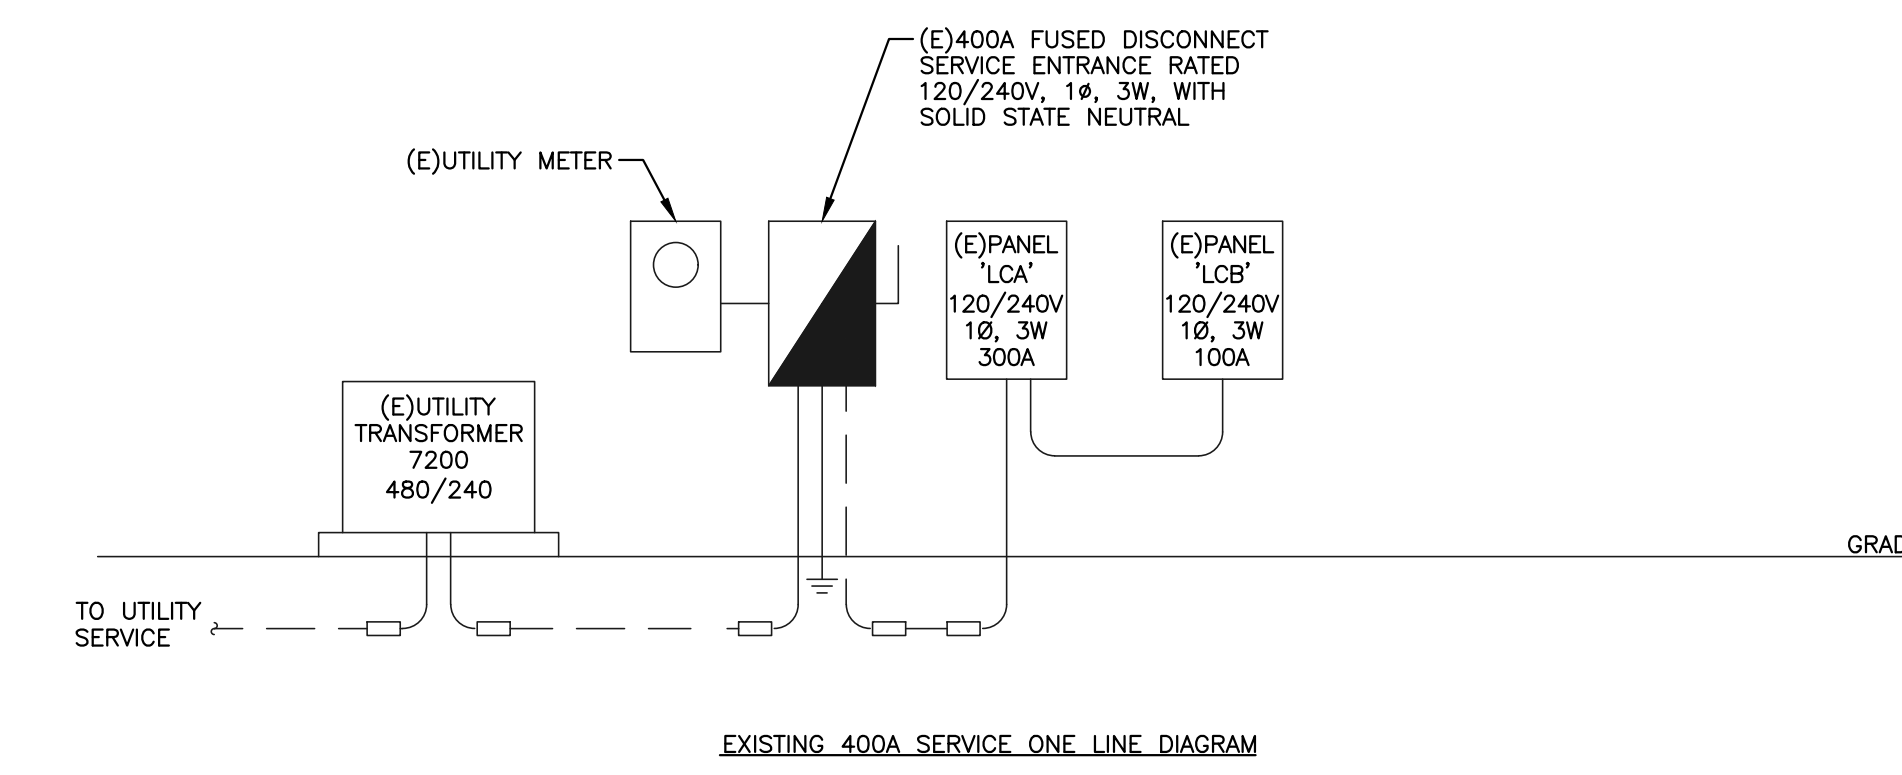


1 SYSTEM GROUNDING DETAIL
NO SCALE

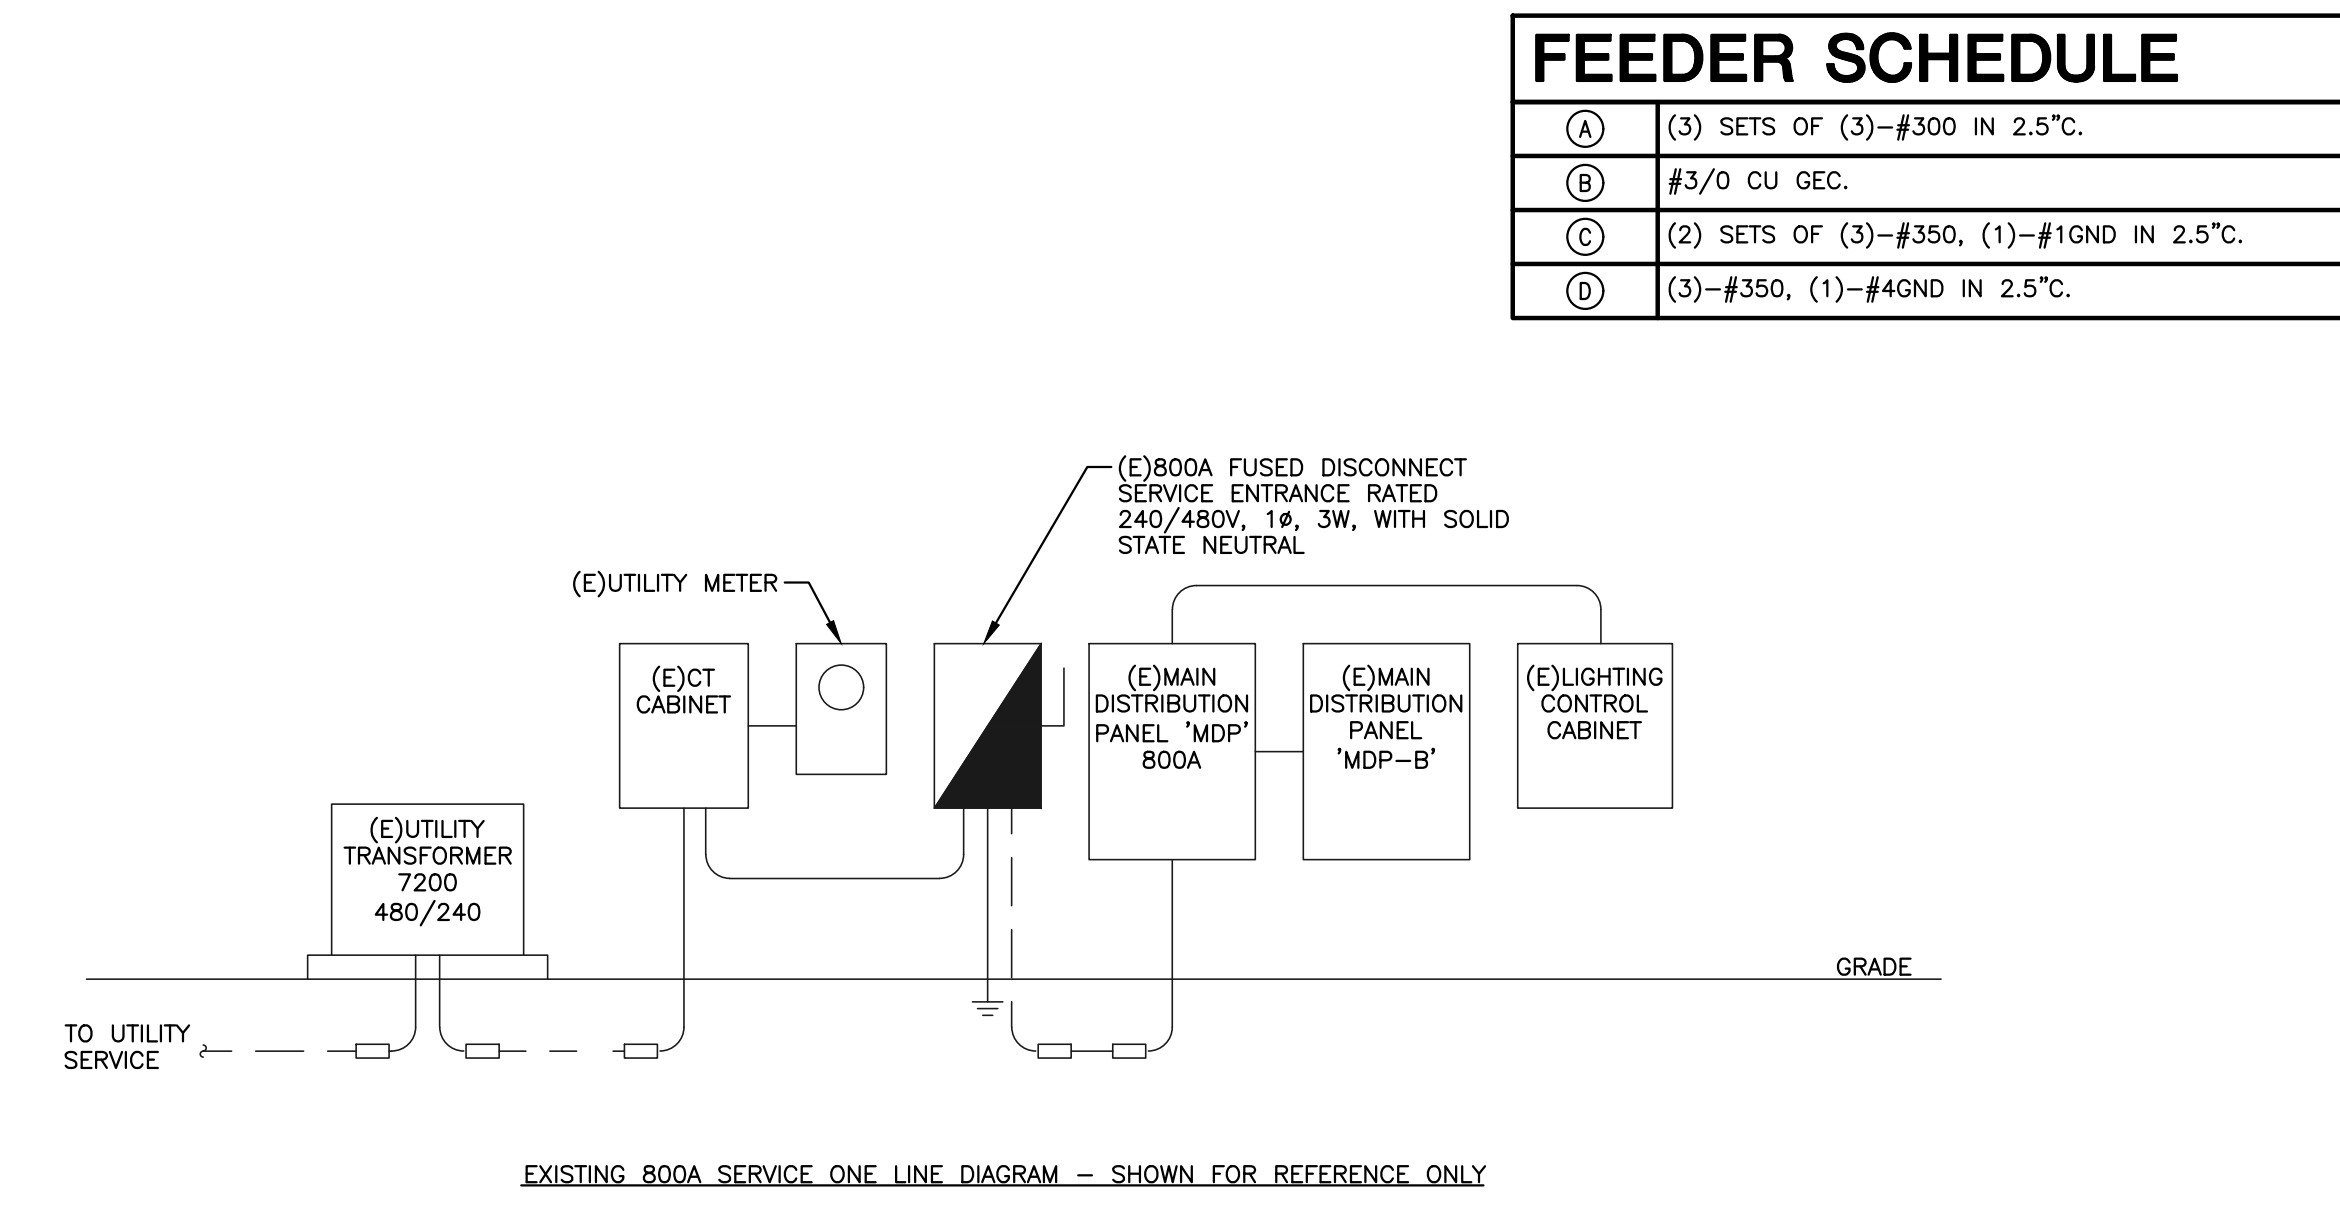

2 ONE-LINE DIAGRAMS
NO SCALE

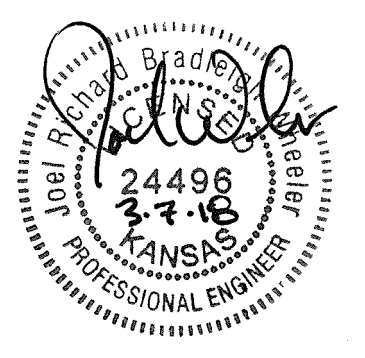

©2018 MKEC Engineering All Rights Reserved. These drawings and their contents, including but not limited to, all concepts, designs, & ideas are the exclusive property of MKEC Engineering (MKEC), and may not be used or reproduced in any way without the express consent of MKEC.

ELECTRICAL DETAILS

PROJECT NO.	1701010567	
DATE	03-07-18	
SCALE	AS NOTED	
DESIGNED	DRAWN	CHECKED
CNG	CV	JRBW

NO.	REVISION	DATE
0	ISSUE FOR CONSTRUCTION	03-07-18

SHEET NO.