




PLOTTED: Monday, June 04, 2018 @ 11:33AM

J:\PROJECTS\2018\1601010221 - PERFECTON, AUBURN LAKES - 16221 CAD\SS\1505 CIVIL\SS\16221-05-2201.DWG

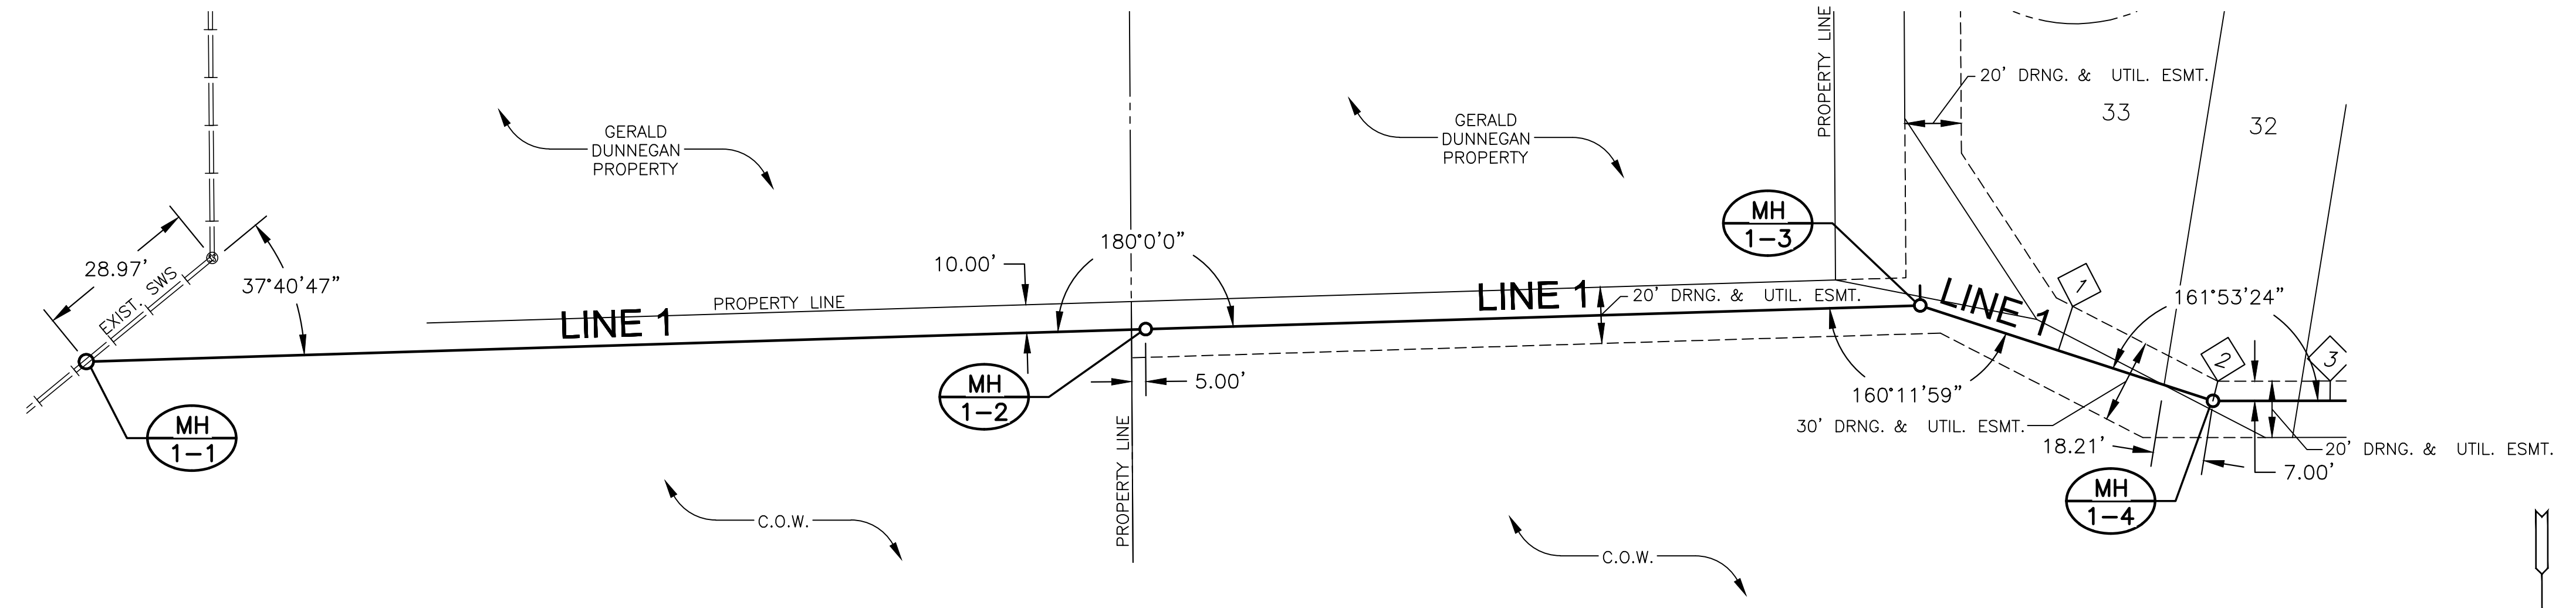


SEWER SERVICE TABLE						
NO.	TYPE	LOCATION			FOR INFORMATION ONLY	
		LOT NO.	BLOCK	LINE NO.	STATION/DIRECTION	APPROX. LENGTH 4" PIPE VERTICAL HORIZONTAL
1	TEE SERVICE CONNECTION	33	1	1	16+59.04/LT	10' 16.5'
2	MH CONNECTION	32	1	1	17+16.80/LT	11' 7.2'

NOTES:
 1. CONTRACTOR TO VERIFY THE DEPTH AND LOCATION OF EXISTING UTILITIES PRIOR TO CONSTRUCTION.
 2. SEE GRADING PLANS FOR TREE REMOVAL.

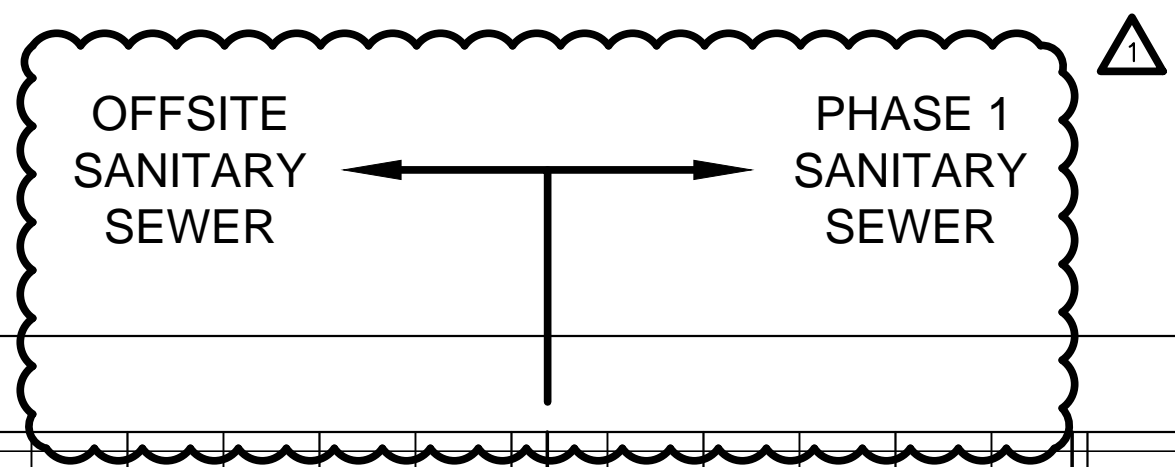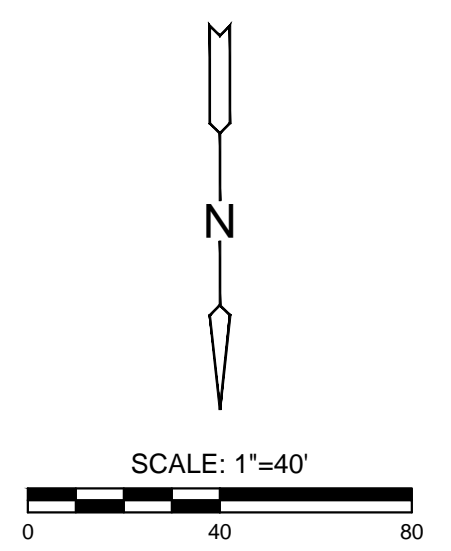

PLAN SS LINE 1 PH 1
PROFILE SS LINE 1 PH 1

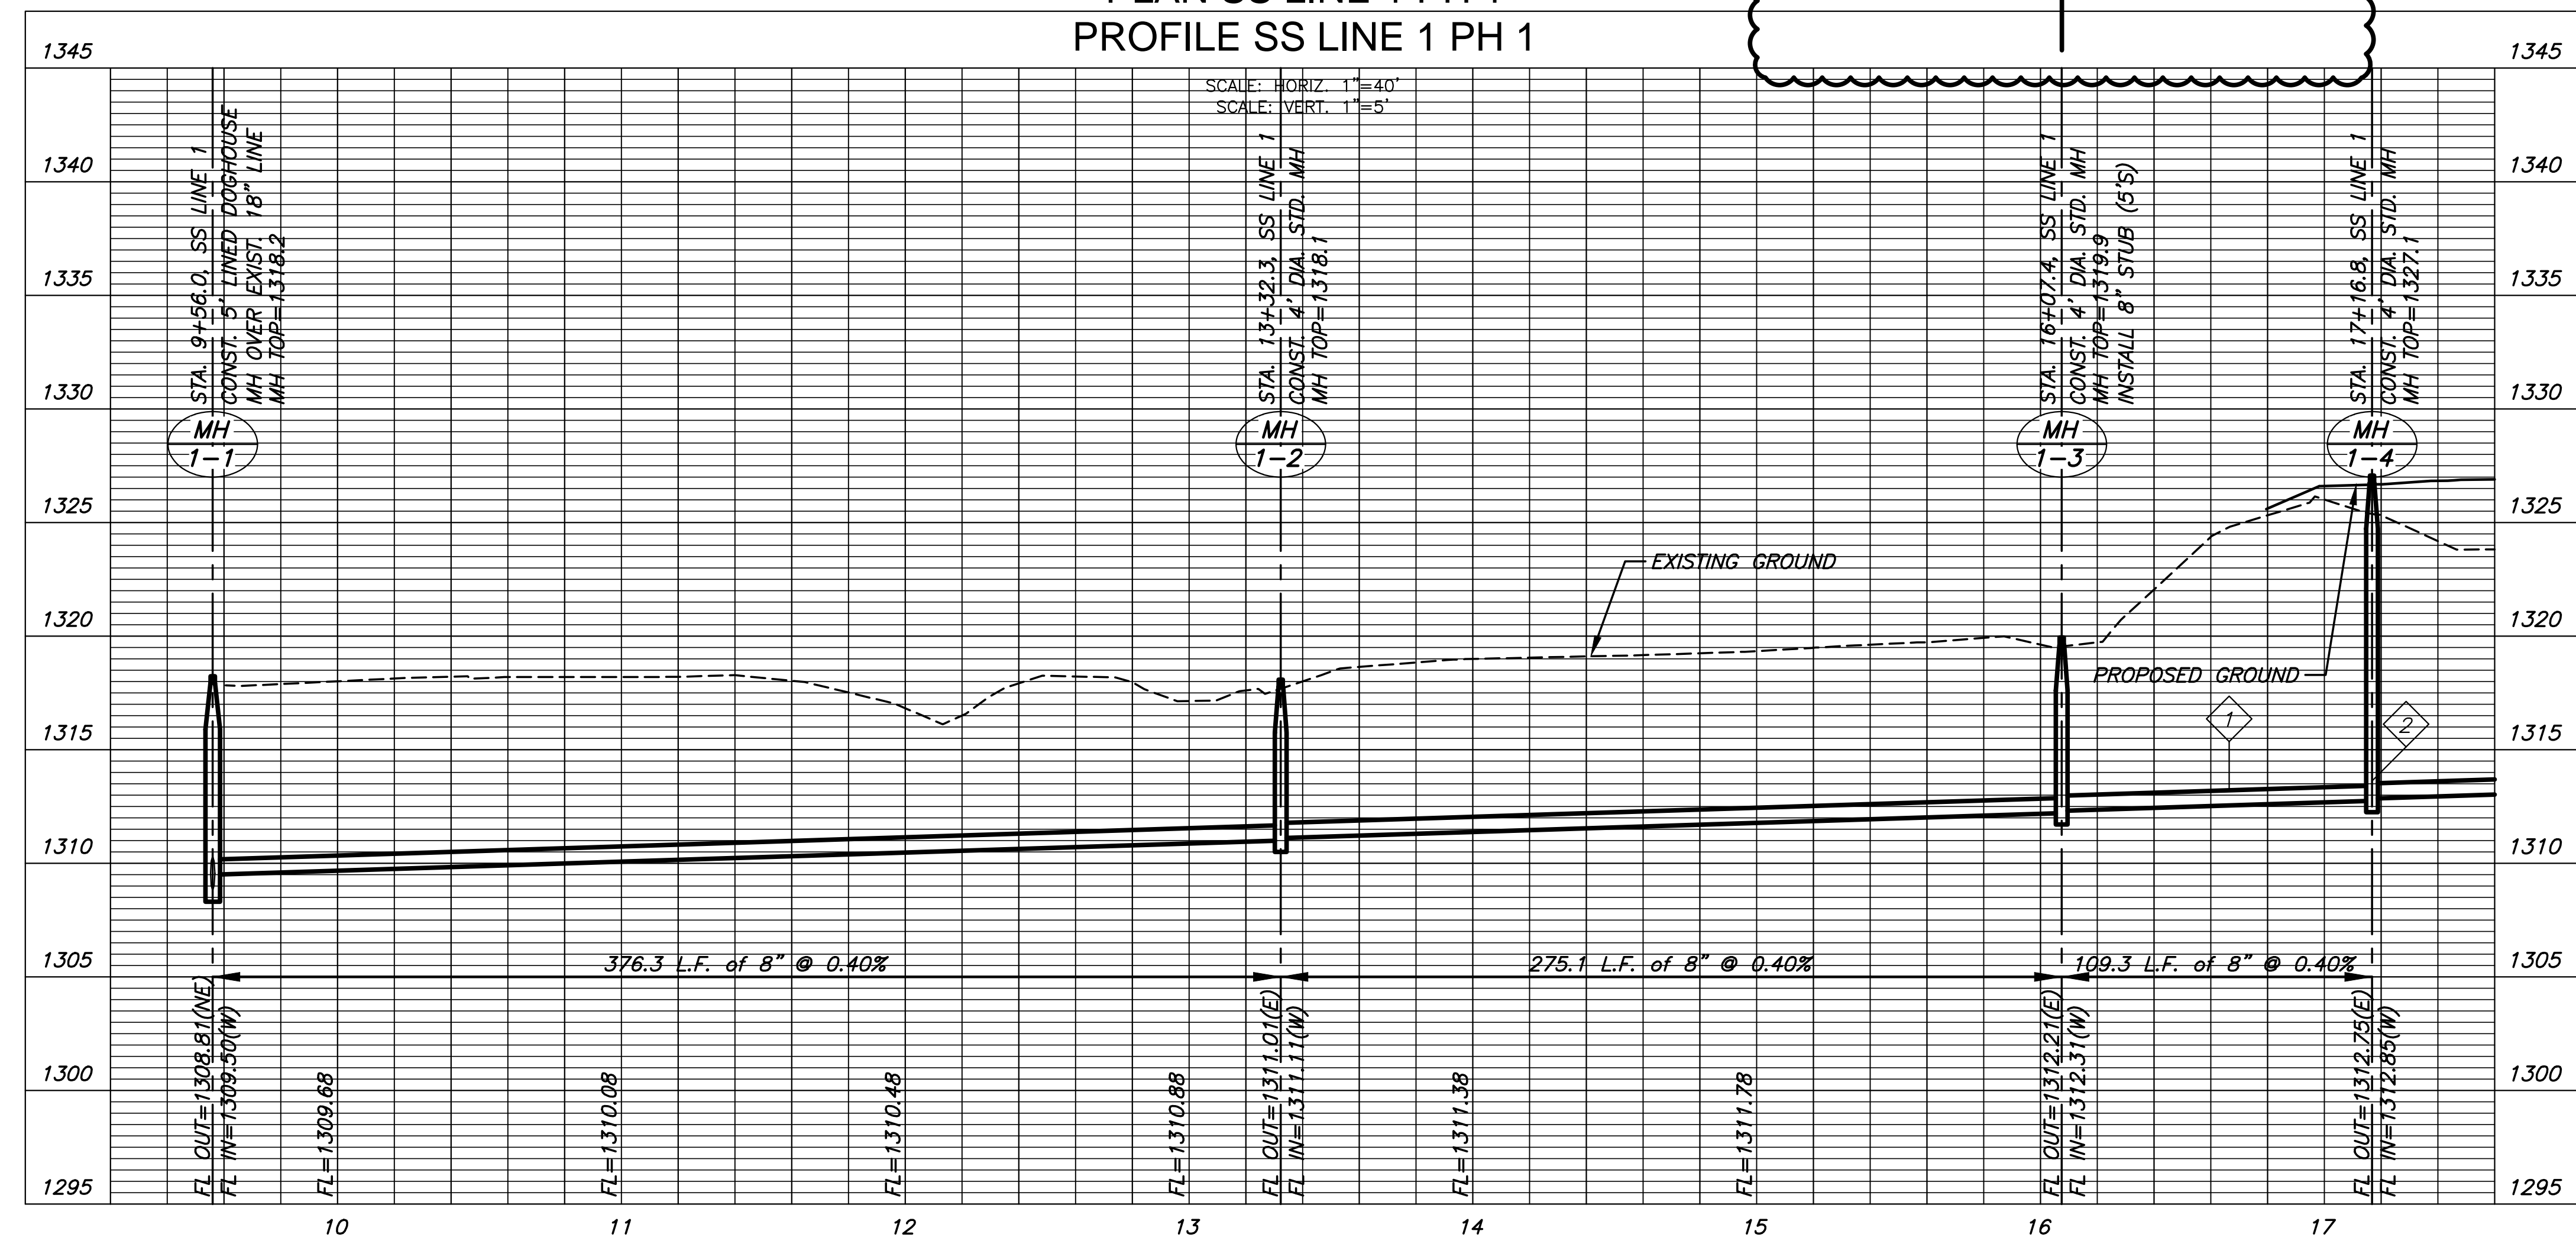

©2018 MKEC Engineering All Rights Reserved
 These drawings and their contents, including, but not limited to, all concepts, designs, & ideas are the exclusive property of MKEC Engineering (MKEC), and may not be used or reproduced in any way without the express consent of MKEC.

LINE 1	
PROJECT NO.	468-85304
DATE	APRIL 2018
SCALE	1" = 40'
DESIGNED	DRAWN
DFL	RWB
CHECKED	GJA
NO.	REVISION
1	OFF-SITE PETITION
	DATE
	06/04/18
SHEET NO.	
05 OF 24	