
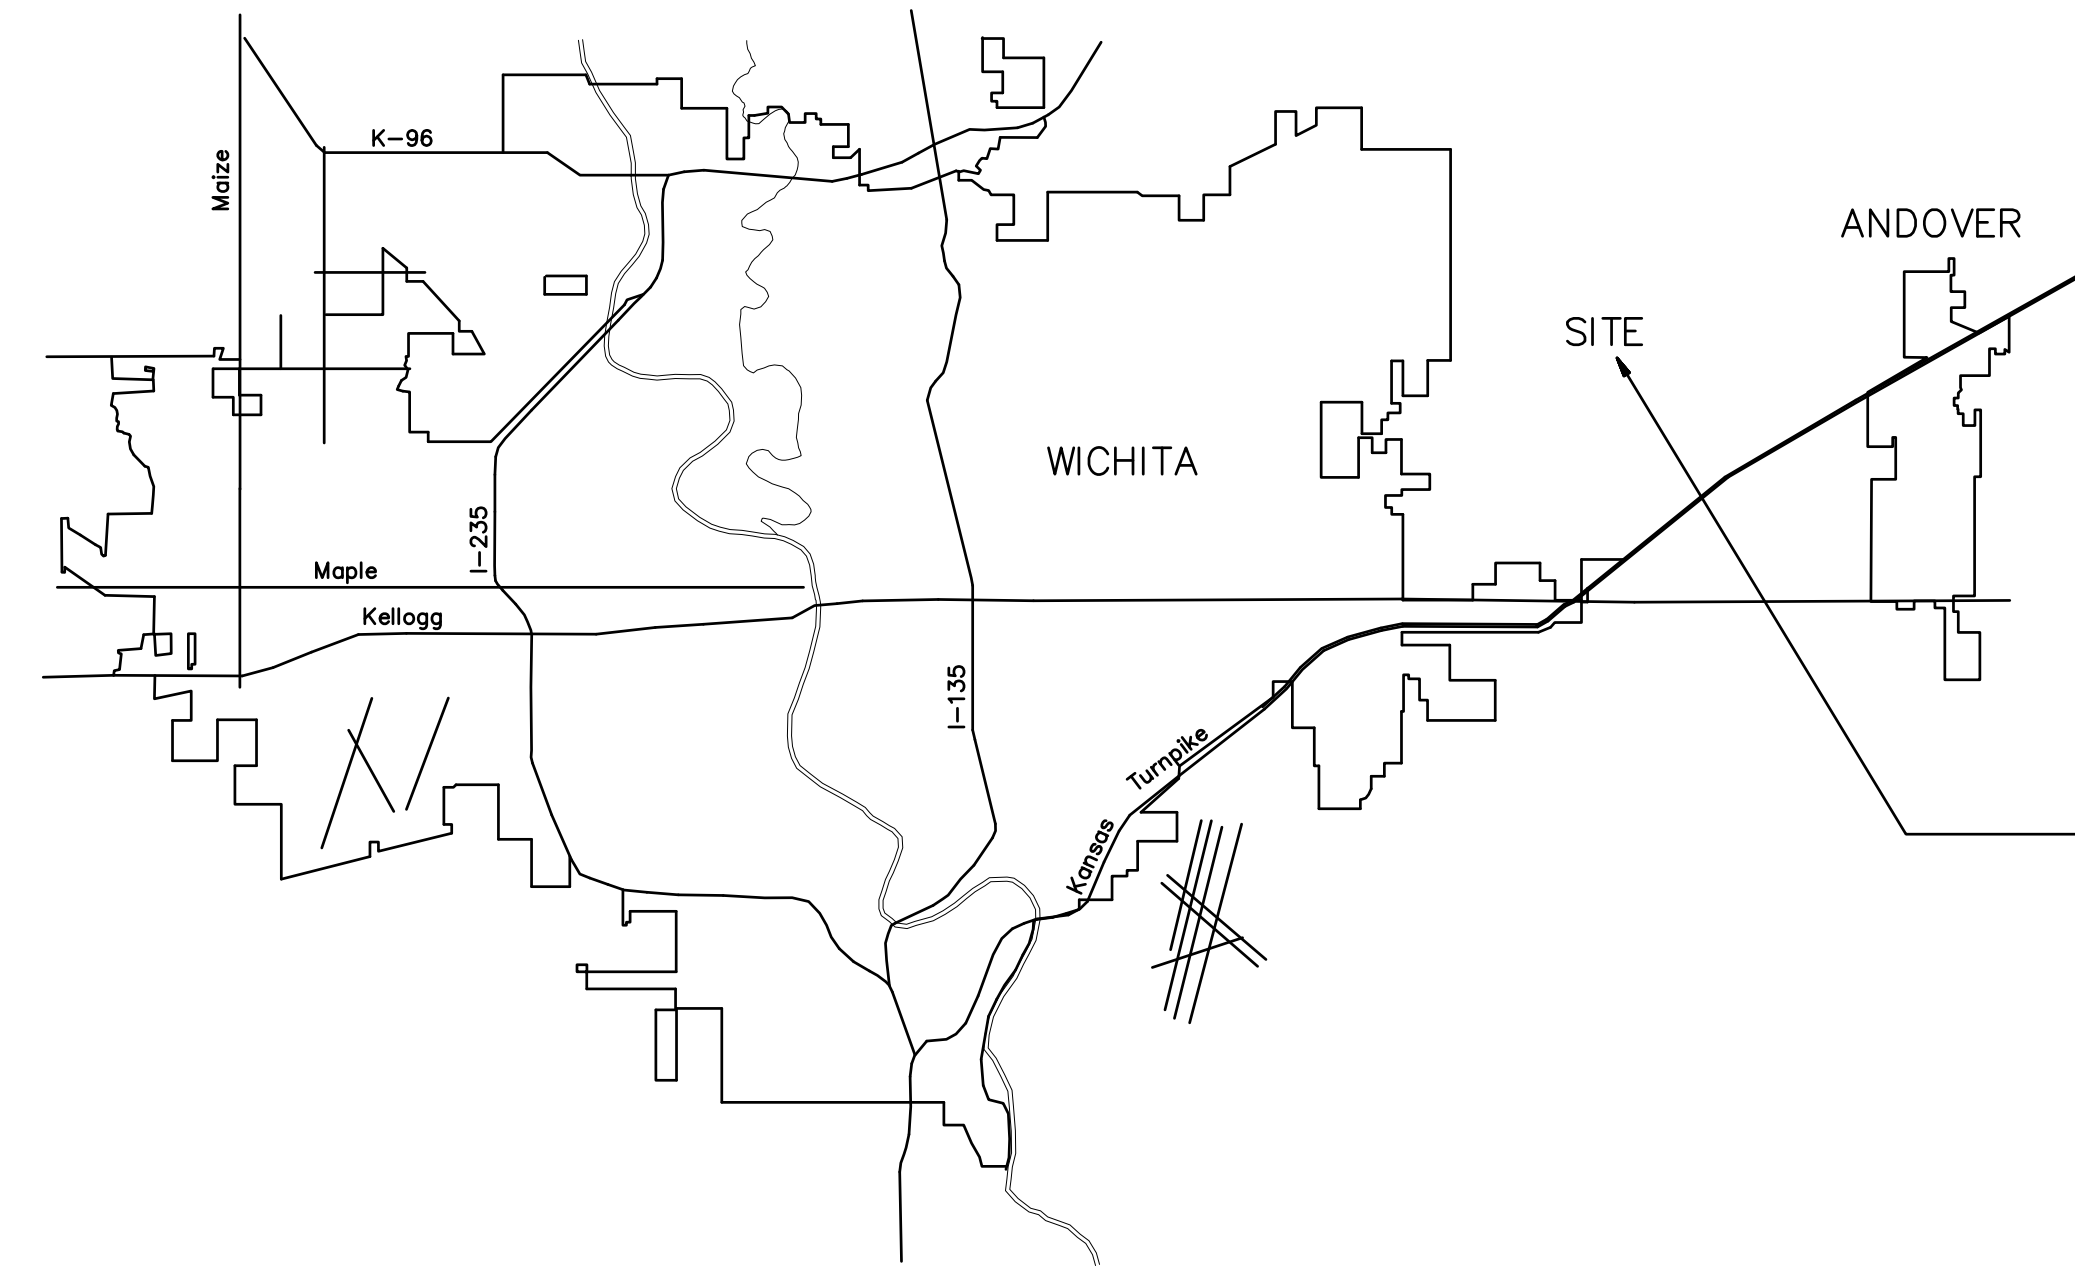


CONSTRUCTION PLANS FOR WATER DISTRIBUTION SYSTEM IMPROVEMENTS

CITY OF WICHITA PROJECT NO. 448-90805
OCA NO. 637401

THE CITY OF WICHITA
SEDGWICK COUNTY, KANSAS
Gary Janzen, P.E., City Engineer


No.	Date	By	Approved	Revision

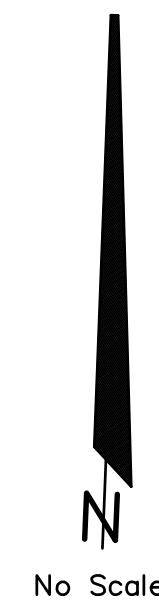


LOCATION MAP

INDEX OF SHEETS

SHEET NO. 1	TITLE SHEET
SHEET NO. 2	KEY MAP
SHEET NO. 3-5	STANDARD DETAILS
SHEET NO. 6-7	PLAN PROFILE
SHEET NO. 8-12	BMP'S
SHEET NO. 13	COORDINATE POINTS LIST
SHEET NO. 14-15	PLAT

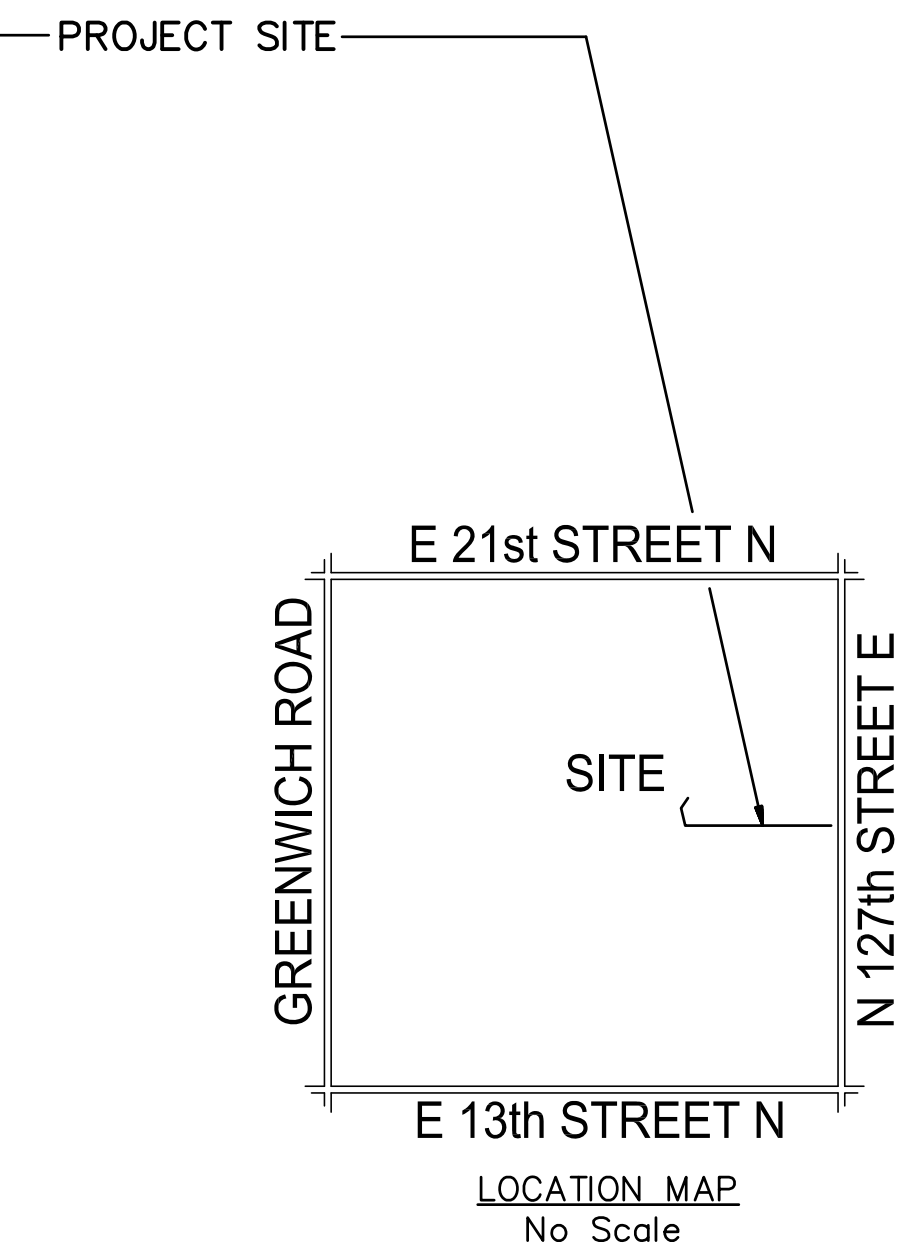

LOCATION MAP
No Scale

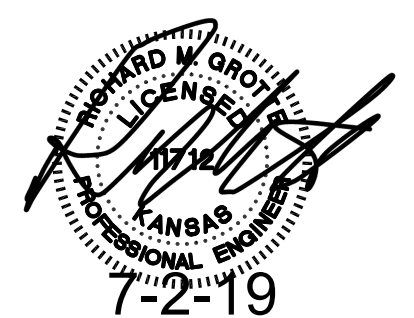

DECEMBER 2018
PLANS PREPARED BY

POE & ASSOCIATES, INC.
CONSULTING ENGINEERS
544 W. Douglas ■ Wichita, KS 67203
Phone 316/685-4114 ■ FAX 316/685-4444