
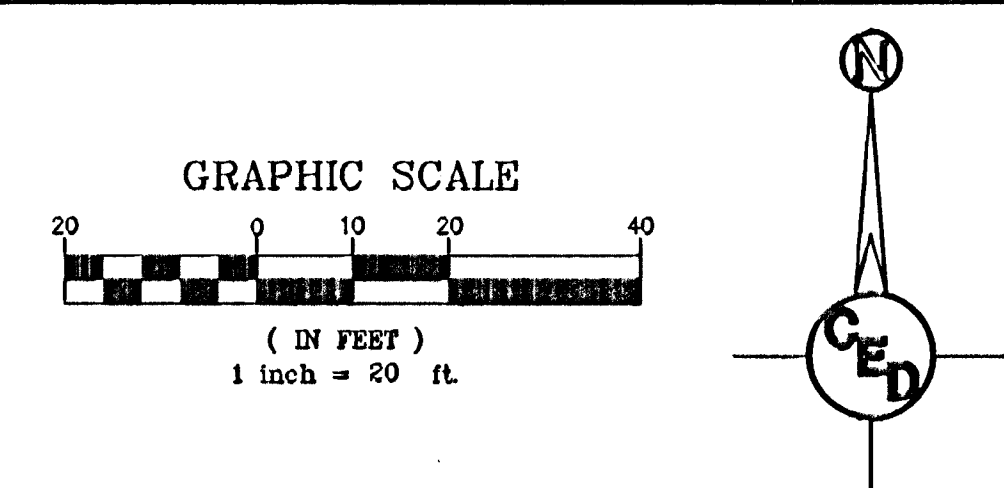


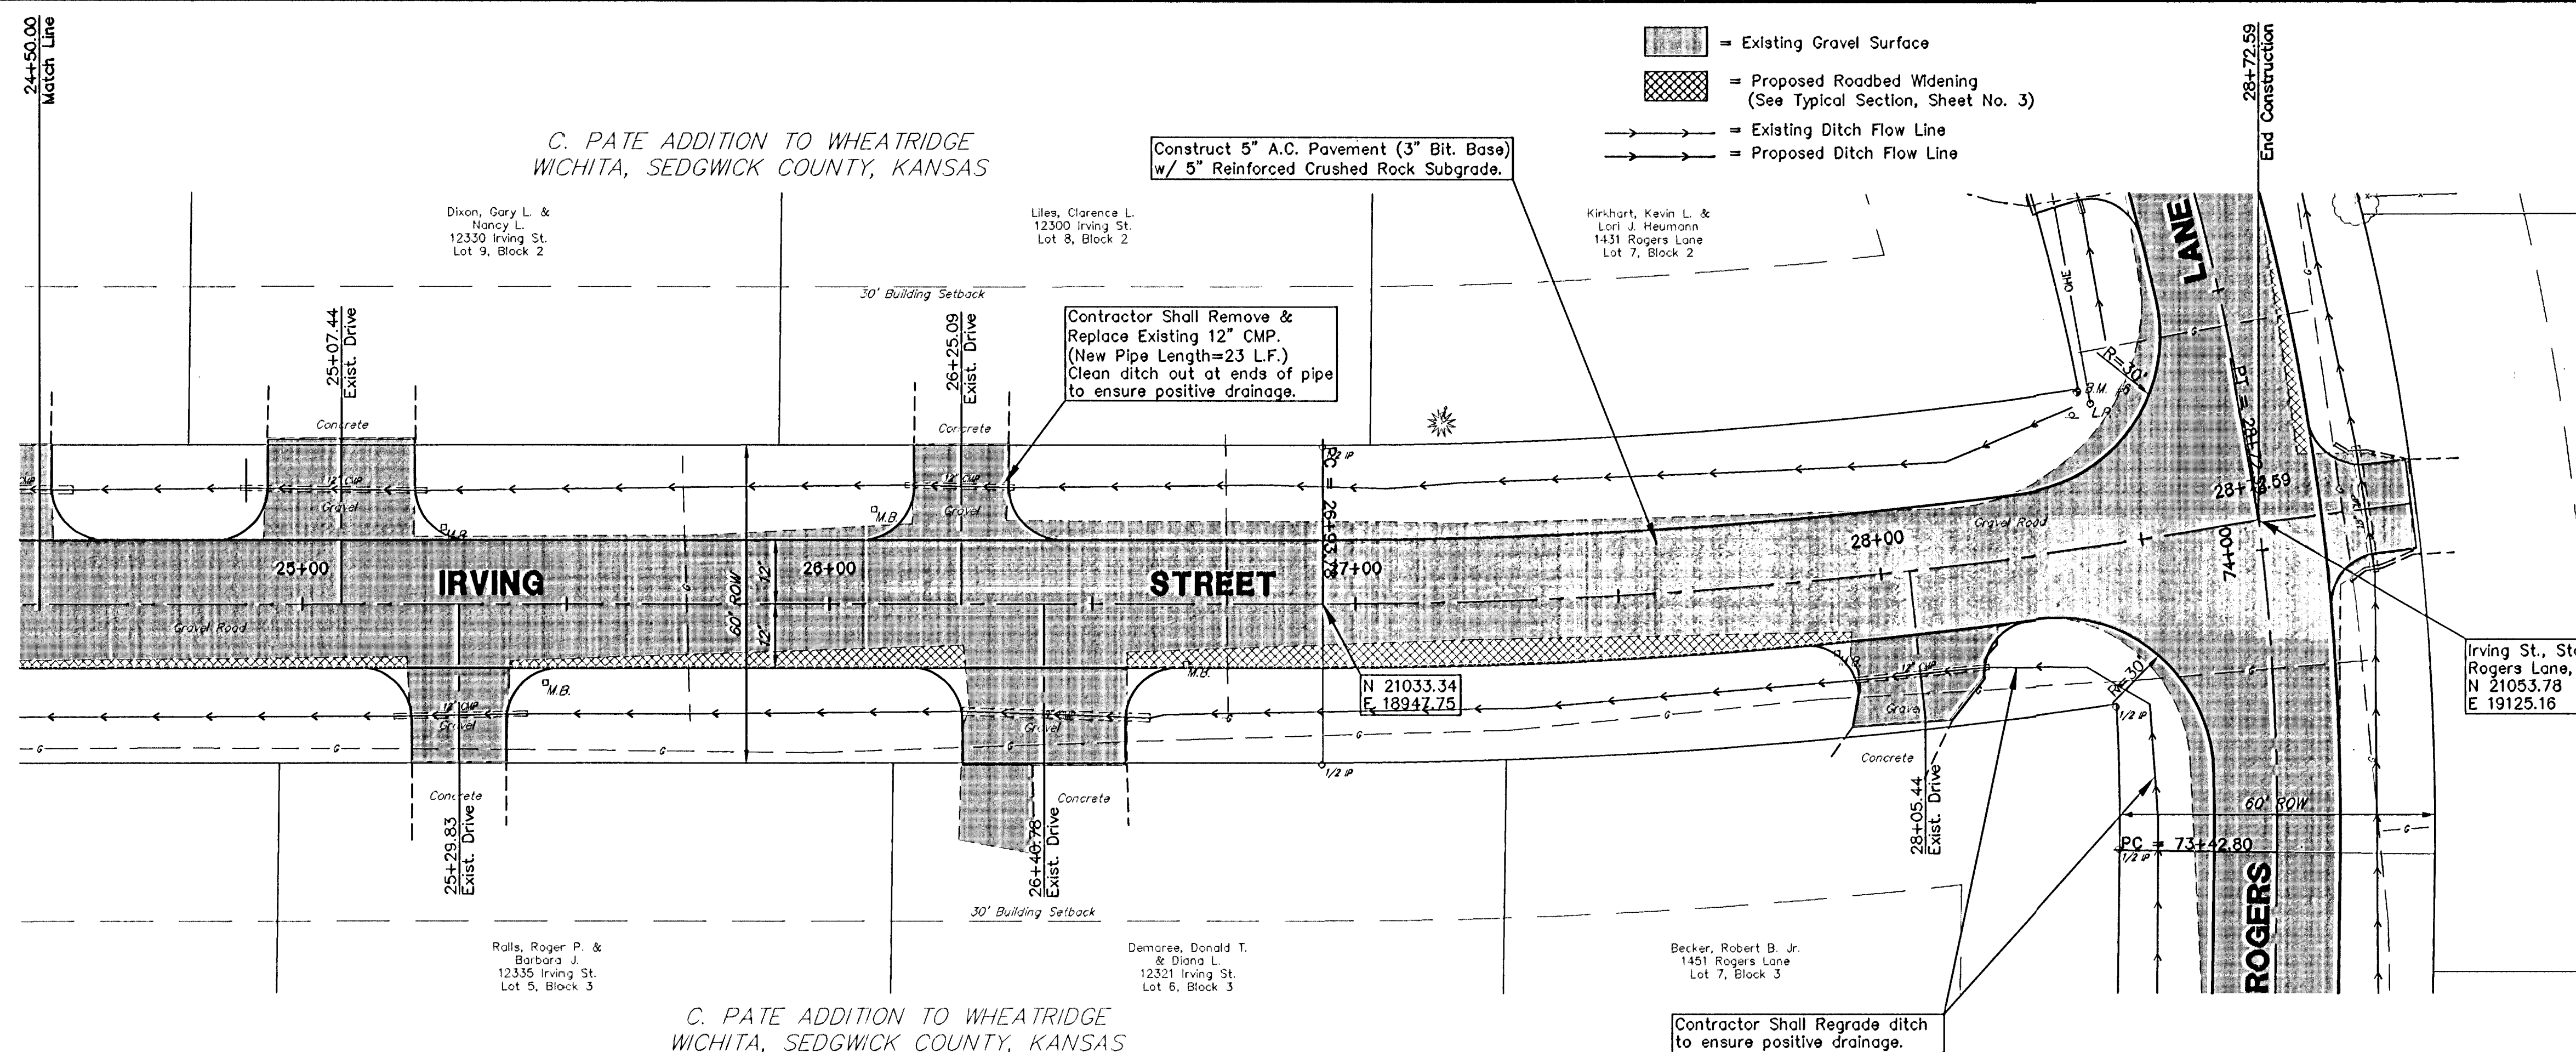


- LEGEND**
- G = GAS MAIN
 - W = WATER MAIN
 - SS = SANITARY SEWER
 - SWS = STORM WATER SEWER
 - USE = UNDER GROUND ELECTRIC
 - UT = UNDER GROUND TELEPHONE
 - B.M. = BENCH MARK
 - TELE. PED. = TELEPHONE PEDESTAL
 - F.H. = FIRE HYDRANT
 - C.A. = CUY. ANCHOR
 - G.P. = GUARD POST
 - H.L.P. = HIGH LINE POLE
 - L.P. = LIGHT POLE
 - M.B. = MAIL BOX
 - P.P. = POWER POLE
 - S.H. = SPRINKLER HEAD
 - S.I. = SIGN
 - WELL. = WATER WELL
 - W.V. = WATER VALVE
 - SS M.H. = SANITARY SEWER MANHOLE

UTILITIES SHOWN REPRESENT THE BEST INFORMATION AVAILABLE FOR DESIGN. ADDITIONAL UTILITIES MAY BE PRESENT ON THIS PROJECT. THE CONTRACTOR SHALL BE RESPONSIBLE FOR DETERMINING THE EXACT LOCATION, DEPTH AND SIZE OF ALL UNDERGROUND UTILITIES PRIOR TO CONSTRUCTION. THE CONTRACTOR SHALL BE LIABLE FOR ANY DAMAGE CAUSED BY THE FAILURE TO DO SO.

SURVEY DISCLAIMER:
TOPOGRAPHIC SURVEY AND ONTOUR MAP USED IN PREPARING PLANS WAS PROVIDED BY S. VOY COMPANY, P.A., 535 S. EMPORIA, SUITE 104, WICHITA, KS. ENGINEER DOES NOT GUARANTEE SURVEY ELEVATIONS FOR ACCURACY. CONTRACTOR SHALL VERIFY ELEVATIONS AND NOTIFY ENGINEER OF ANY DISCREPANCIES.

PC=Beginning of Curve
PT=Curve/Tangent Intersect
PRC=Reverse Curve/Intersection
PCC=Compound Curve/Intersection

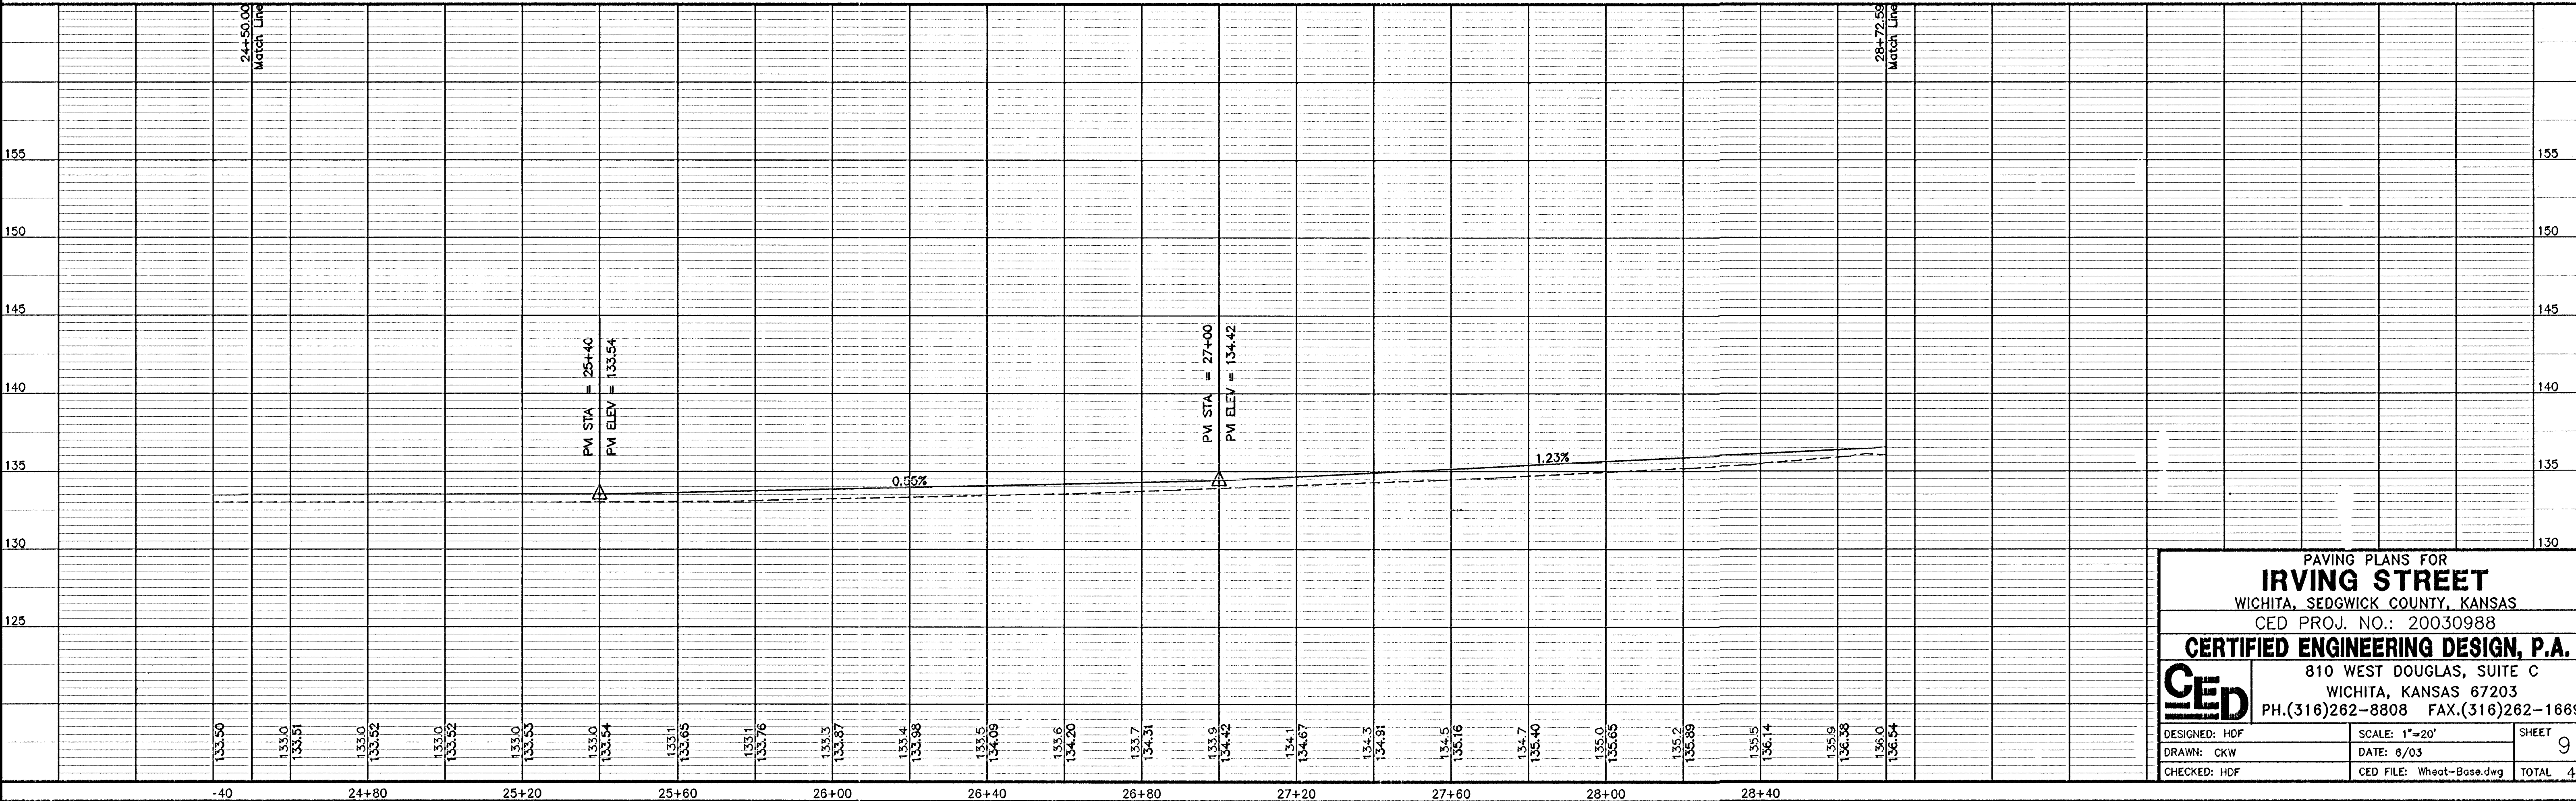

PAVING PLANS FOR
IRVING STREET
WICHITA, SEDGWICK COUNTY, KANSAS
CED PROJ. NO.: 20030988
CERTIFIED ENGINEERING DESIGN, P.A.
810 WEST DOUGLAS, SUITE C
WICHITA, KANSAS 67203
PH.(316)262-8808 FAX.(316)262-1669

DESIGNED: HDF **SCALE:** 1"=20' **SHEET:** 9
DRAWN: CKW **DATE:** 6/03
CHECKED: HDF **CED FILE:** Wheat-Base.dwg **TOTAL:** 43