

**LEGEND**

G = GAS MAIN  
 W = WATER MAIN  
 SS = SANITARY SEWER  
 SWS = STORM WATER SEWER  
 UGE = UNDER GROUND ELECTRIC  
 UGT = UNDER GROUND TELEPHONE


B.M. = BENCH MARK  
 TELE. PED. = TELEPHONE PEDESTAL  
 F.H. = FIRE HYDRANT  
 C.A. = CUI ANCHOR  
 Q.P. = QUARD POST  
 H.L.P. = HIGH LINE POLE  
 L.P. = LIGHT POLE  
 M.B. = MAIL BOX  
 P.P. = POWER POLE  
 S.H. = SPRINKLER HEAD  
 S. = SIGN  
 W.H. = WATER WELL  
 W.V. = WATER VALVE  
 S.S.M.H. = SANITARY SEWER MANHOLE

UTILITIES SHOWN REPRESENT THE BEST INFORMATION AVAILABLE FOR DESIGN. ADDITIONAL UTILITIES MAY BE PRESENT ON THIS PROJECT. THE CONTRACTOR SHALL BE RESPONSIBLE FOR DETERMINING THE EXACT LOCATION, DEPTH AND SIZE OF ALL UNDERGROUND UTILITIES PRIOR TO CONSTRUCTION. THE CONTRACTOR SHALL BE LIABLE FOR ANY DAMAGE CAUSED BY THE FAILURE TO DO SO.

**SURVEY DISCLAIMER:**  
 TOPOGRAPHIC SURVEY AND CONTOUR MAP USED IN PREPARING PLANS WAS PROVIDED BY SAVOY COMPANY, P.A., 535 S. EMPORIA, SUITE 104, WICHITA, KS. ENGINEER DOES NOT GUARANTEE SURVEY ELEVATIONS FOR ACCURACY. CONTRACTOR SHALL VERIFY ELEVATIONS AND NOTIFY ENGINEER OF ANY DISCREPANCIES.

- = Existing Gravel Surface
- = Proposed Roadbed Widening (See Typical Section, Sheet No. 3)
- = Existing Ditch Flow Line
- = Proposed Ditch Flow Line

PC=Beginning of Curve  
 PT=Curve/Tangent Intersect  
 PRC=Reverse Curve/Reverse Intersect  
 PCC=Compound Curve/Compound Intersect

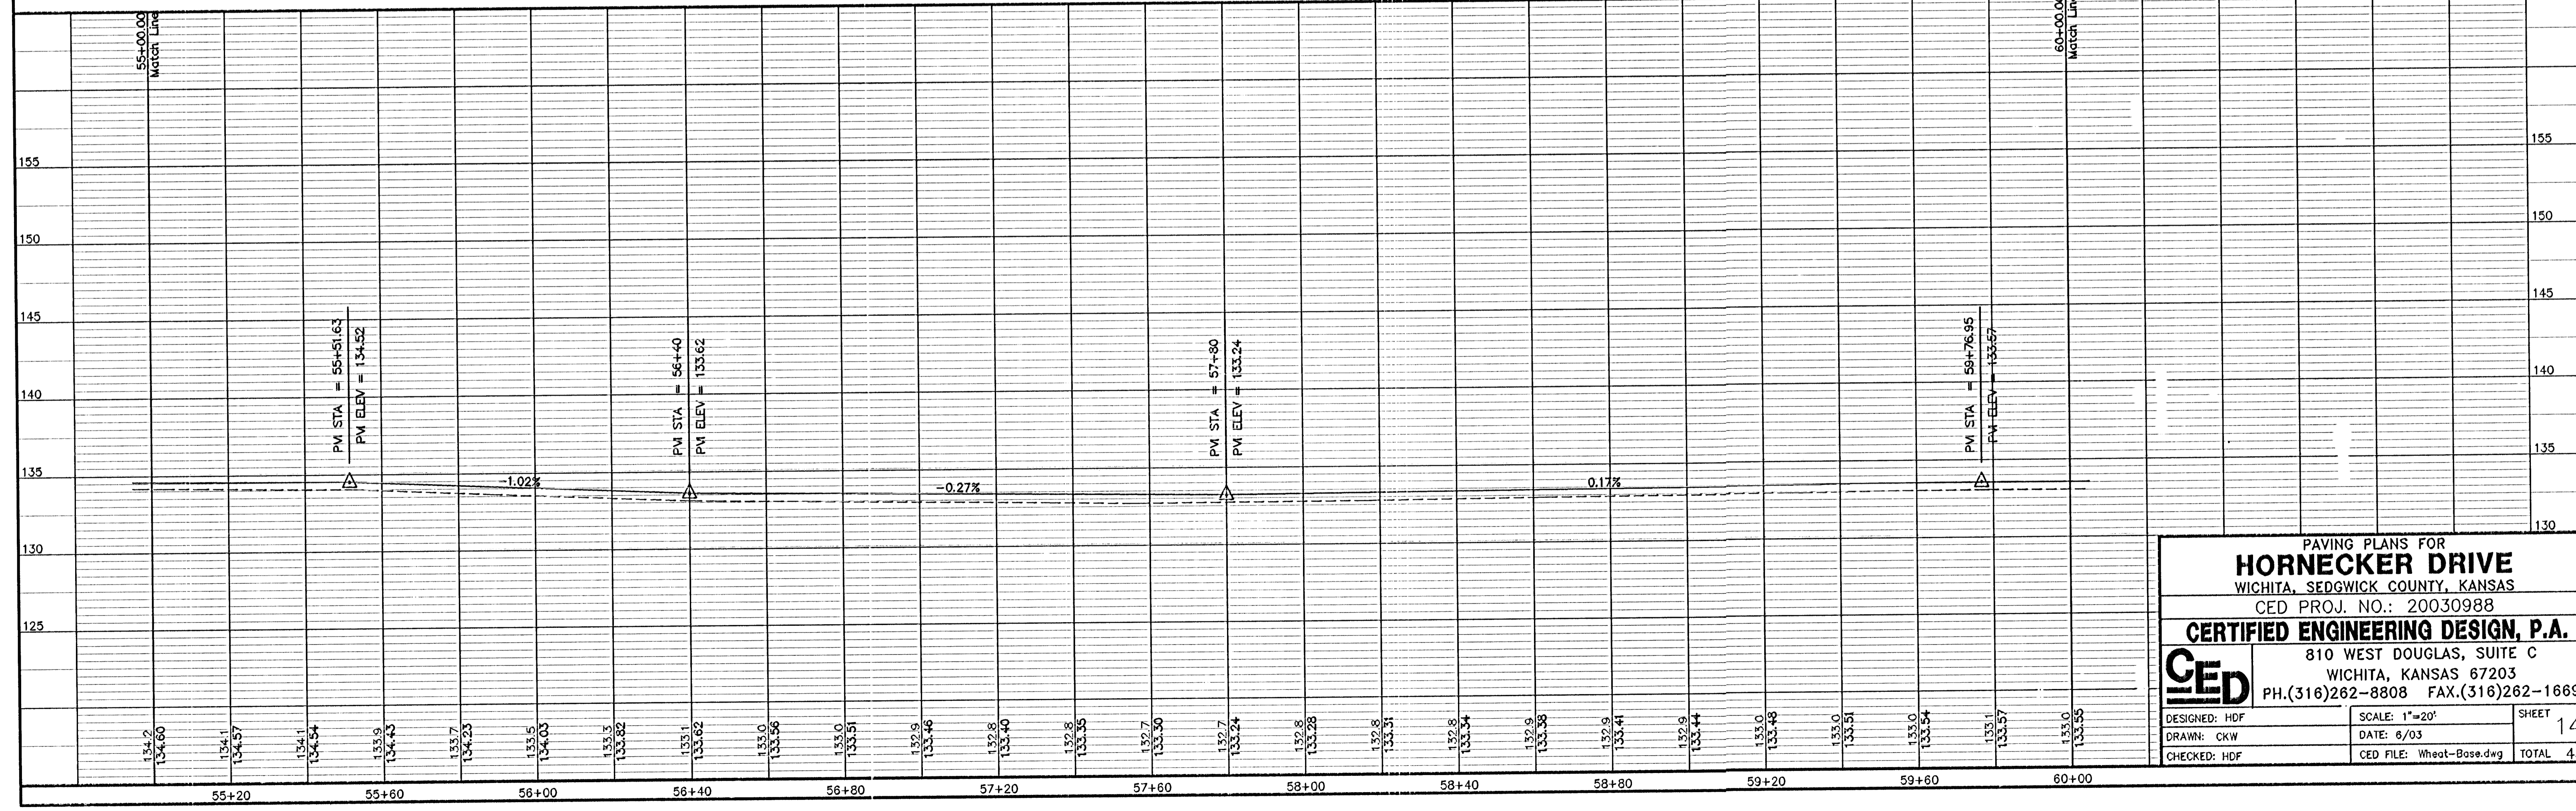

PAVING PLANS FOR  
**HORNECKER DRIVE**  
 WICHITA, SEDGWICK COUNTY, KANSAS  
 CED PROJ. NO.: 20030988  
**CERTIFIED ENGINEERING DESIGN, P.A.**  
 810 WEST DOUGLAS, SUITE C  
 WICHITA, KANSAS 67203  
 PH.(316)262-8808 FAX.(316)262-1669

DESIGNED: HDF  
 DRAWN: CKW  
 CHECKED: HDF

SCALE: 1"=20'  
 DATE: 6/03  
 CED FILE: Wheat-Base.dwg

SHEET  
 14  
 TOTAL 43