

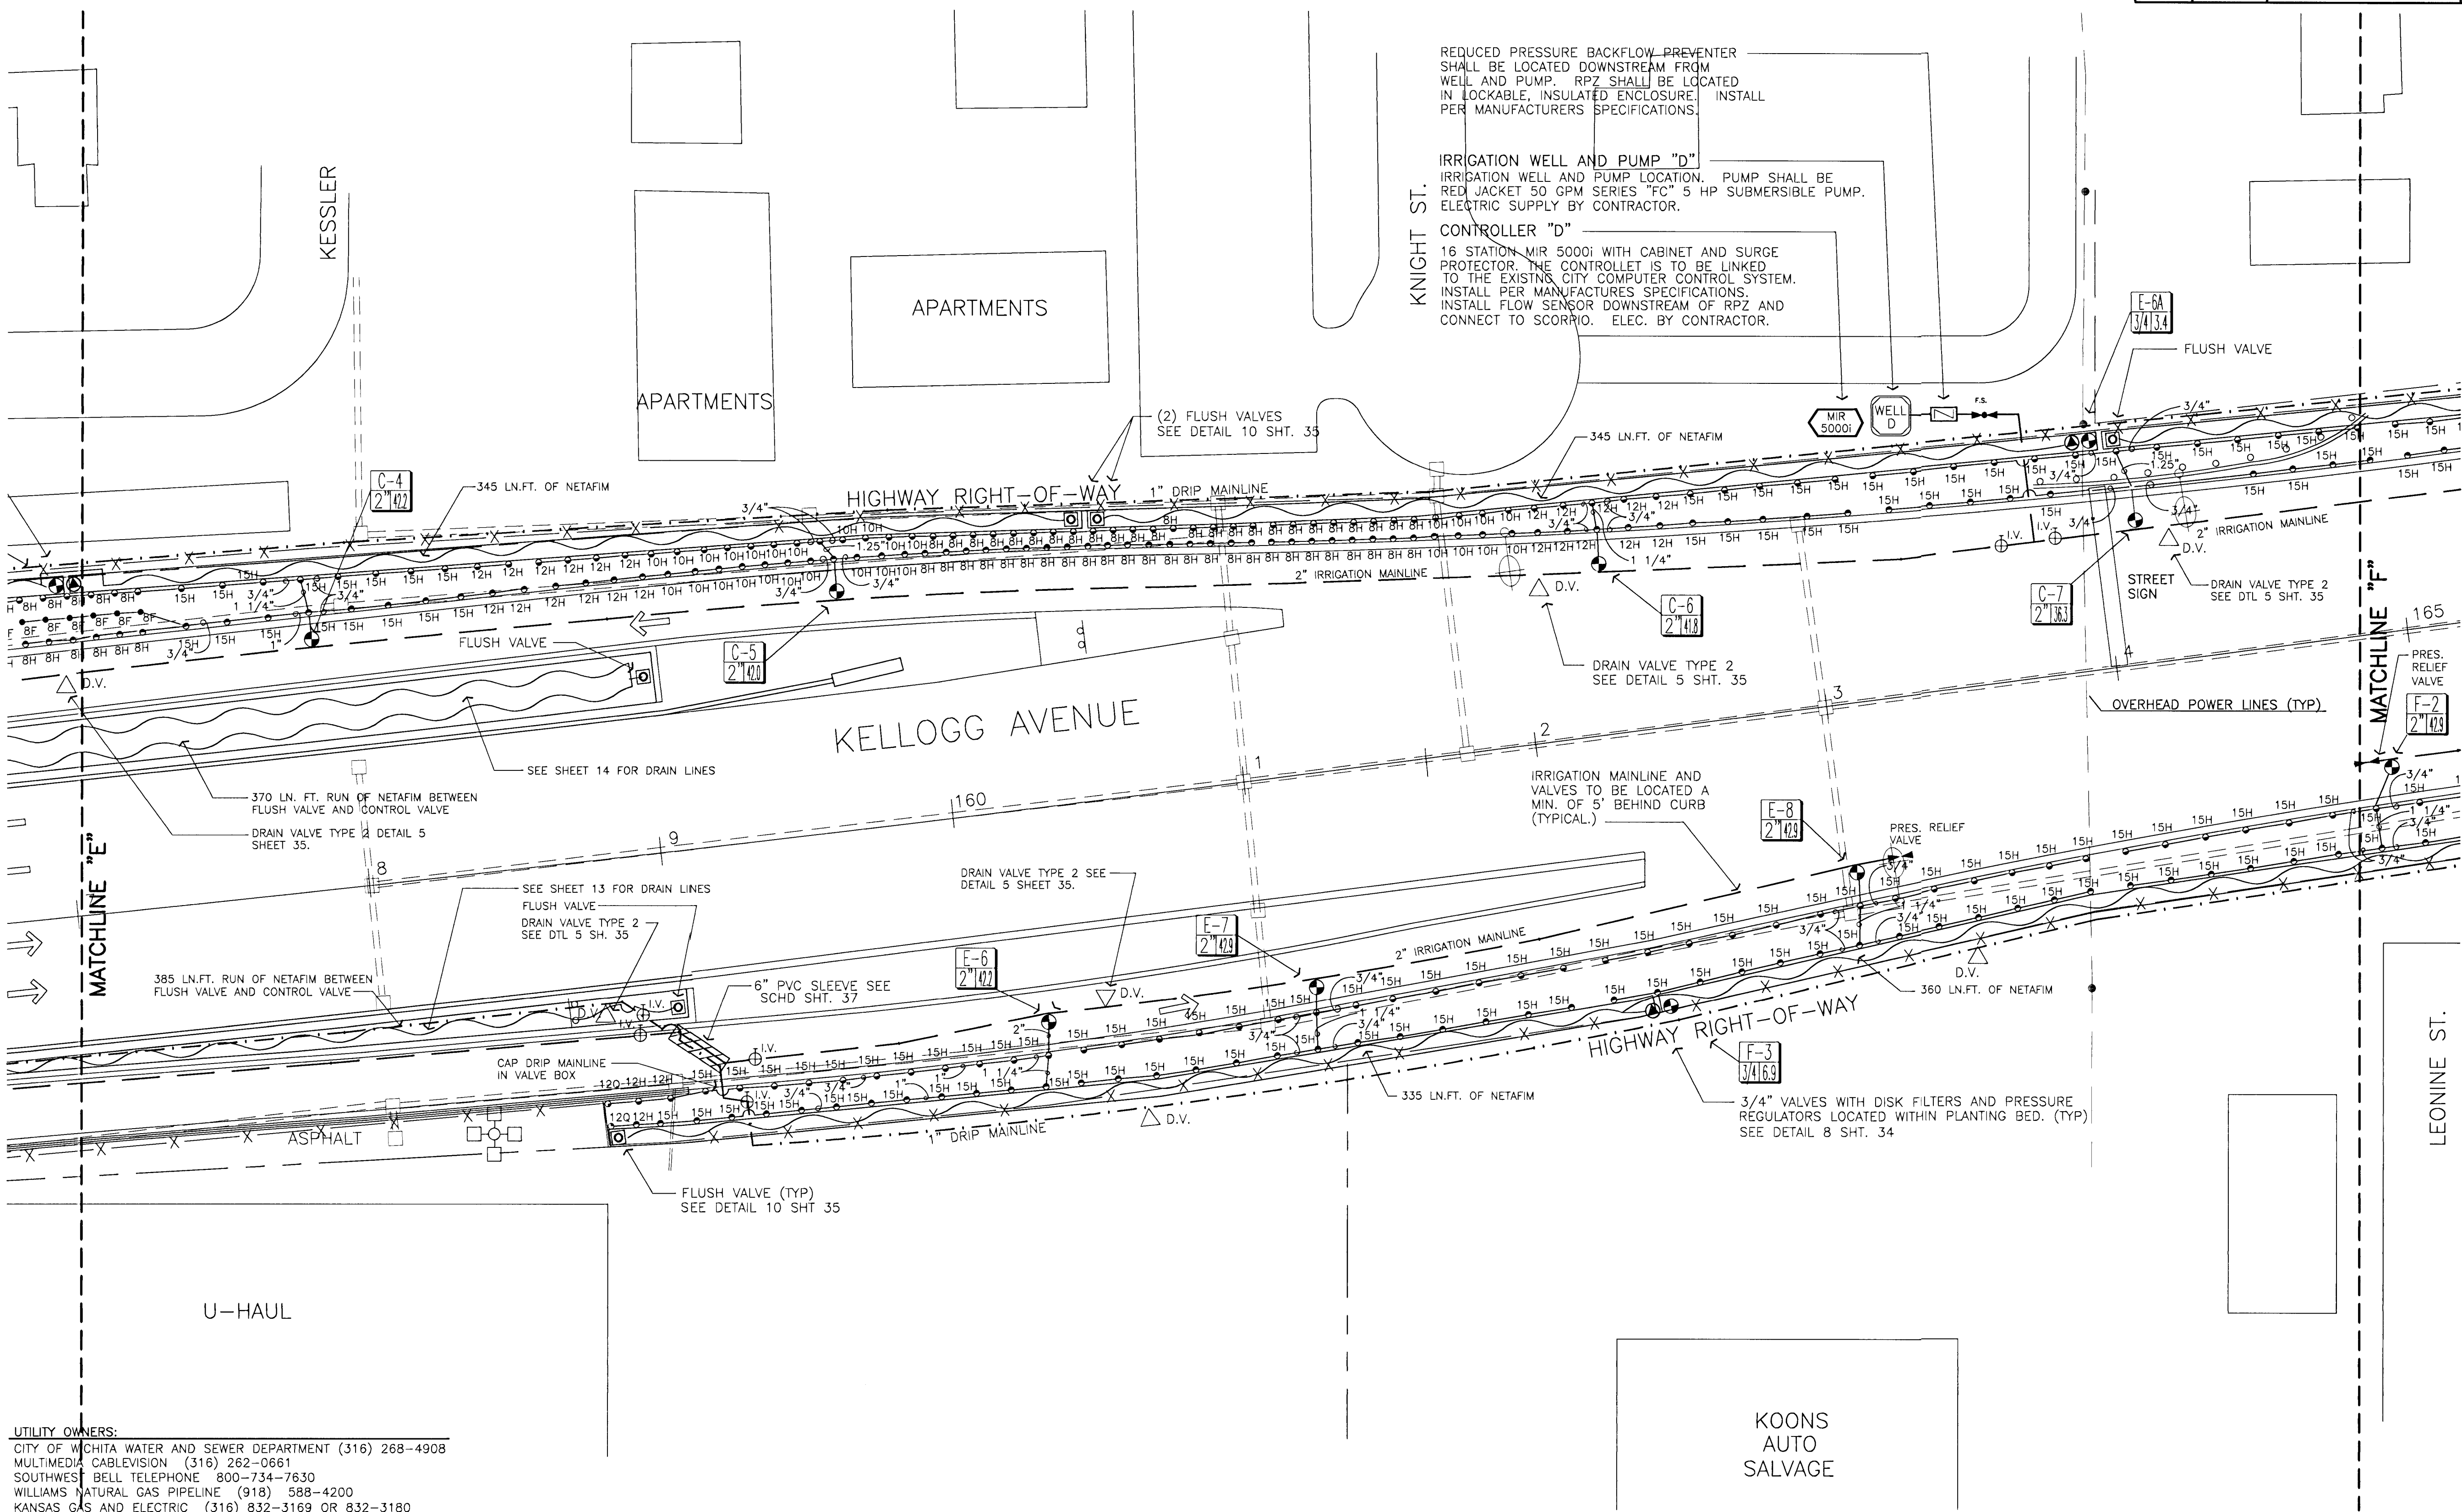


FHWA REG NO.	STATE	PROJECT NO.	YEAR	SHEET NO.	SHEETS
7	KANSAS	54-87-TE-0039-01	1997	32	43

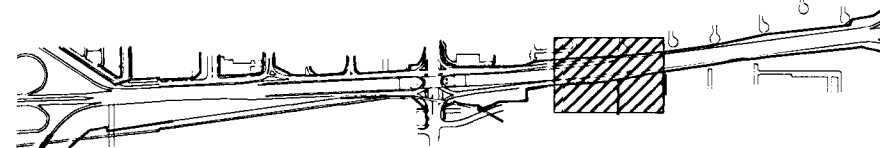


UTILITY OWNERS:
CITY OF WICHITA WATER AND SEWER DEPARTMENT (316) 268-4908
MULTIMEDIA CABLEVISION (316) 262-0661
SOUTHWEST BELL TELEPHONE 800-734-7630
WILLIAMS NATURAL GAS PIPELINE (918) 588-4200
KANSAS GAS AND ELECTRIC (316) 832-3169 OR 832-3180

CONTRACTOR TO VERIFY LOCATIONS OF ALL UTILITIES PRIOR TO DIGGING.

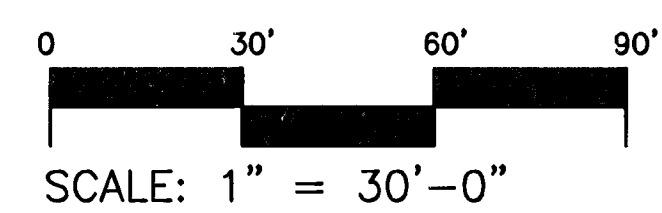

KEY PLAN

NOTE:
SEE SHEETS 35 AND 36 FOR IRRIGATION DETAILS
SEE SHEET 37 FOR IRRIGATION NOTES AND LEGEND
SEE SHEET 15 FOR DRAIN TILE LOCATIONS

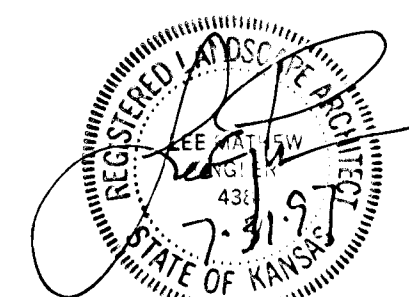

KANSAS DEPARTMENT OF TRANSPORTATION

KELLOGG AND WEST STREET
STATION 157+00 TO 165+00
IRRIGATION PLAN
PROJECT NO. #70122-1

Wilson Darnell Mann

architecture site planning interiors
Wichita, Kansas

DESIGNED BY: WDM, PA

CHECKED BY: LME

DRAWN BY: SKW

DATE: 7/31/97

SHEET 32 OF 43

13-06
08/19/1997
K:\94082\RRG\U-6
E:\94082\MAINBASE E:\94082\RRG