

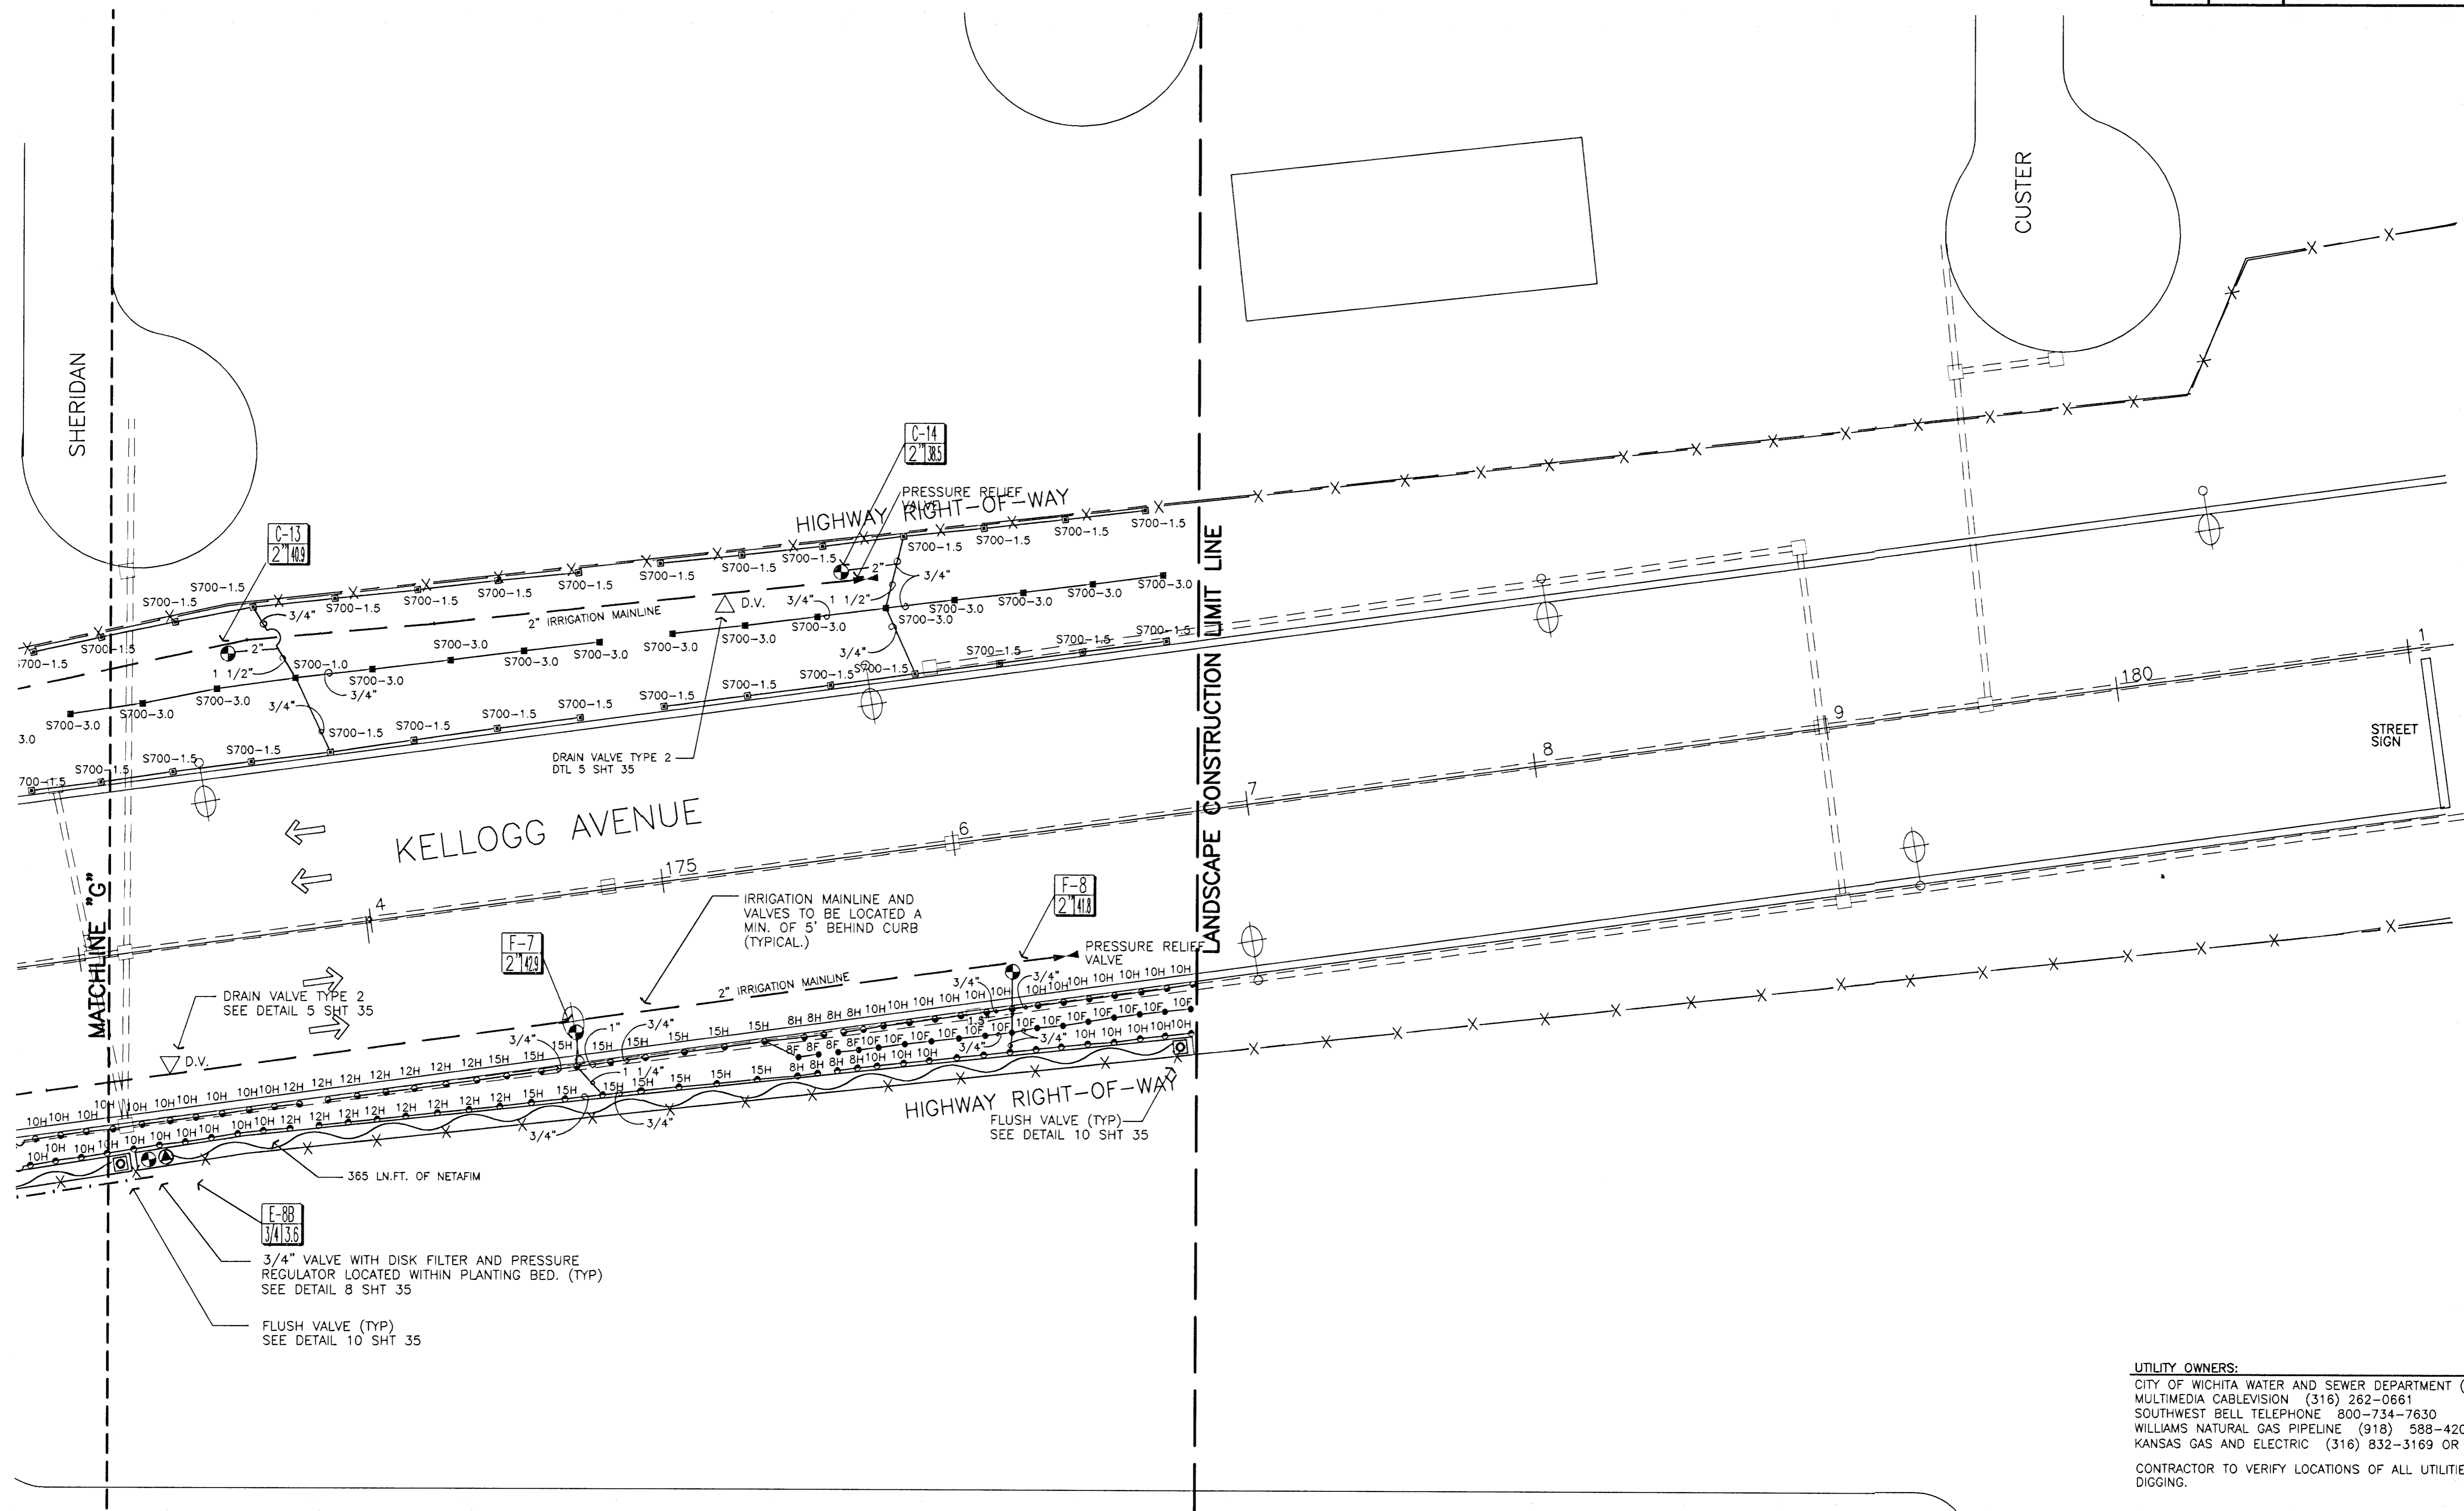


FHWA REG NO.	STATE	PROJECT NO.	YEAR	SHEET NO.	SHEETS
7	KANSAS	54-87-TE-0039-01	1997	34	43

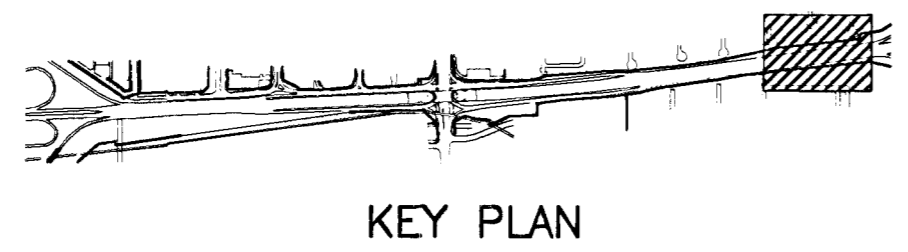

UTILITY OWNERS:
 CITY OF WICHITA WATER AND SEWER DEPARTMENT (316) 268-4908
 MULTIMEDIA CABLEVISION (316) 262-0661
 SOUTHWEST BELL TELEPHONE 800-734-7630
 WILLIAMS NATURAL GAS PIPELINE (918) 588-4200
 KANSAS GAS AND ELECTRIC (316) 832-3169 OR 832-3180
 CONTRACTOR TO VERIFY LOCATIONS OF ALL UTILITIES PRIOR TO DIGGING.

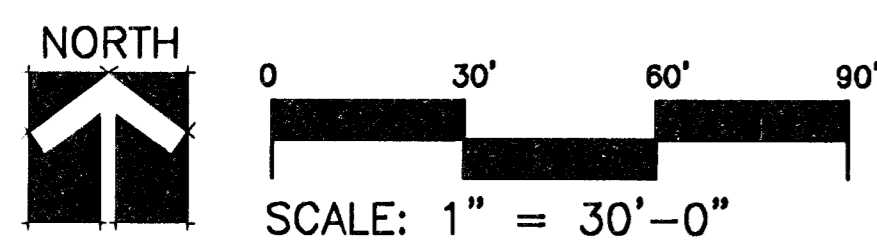


NOTE:
 SEE SHEETS 35 AND 36 FOR IRRIGATION DETAILS
 SEE SHEET 37 FOR IRRIGATION NOTES AND LEGEND

KANSAS DEPARTMENT OF TRANSPORTATION
 KELLOGG AND WEST STREET
 STATION 173+00 TO 181+00
 IRRIGATION PLAN
 PROJECT NO. #701227

Wilson Darnell Mann
 architecture site planning interiors
 Wichita, Kansas

DESIGNED BY: WDM, PA	CHECKED BY: LME
DRAWN BY: SKW	DATE: 7/31/97 SHEET 34 OF 43

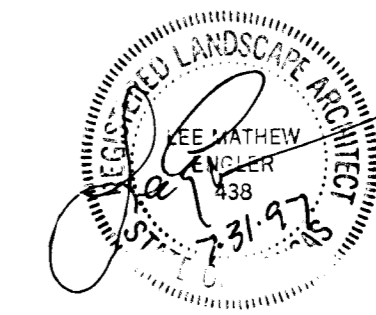

2-17-97
 E:\94082\LI-8
 E:\94082\MAINBASE E:\94082\IRRIG