

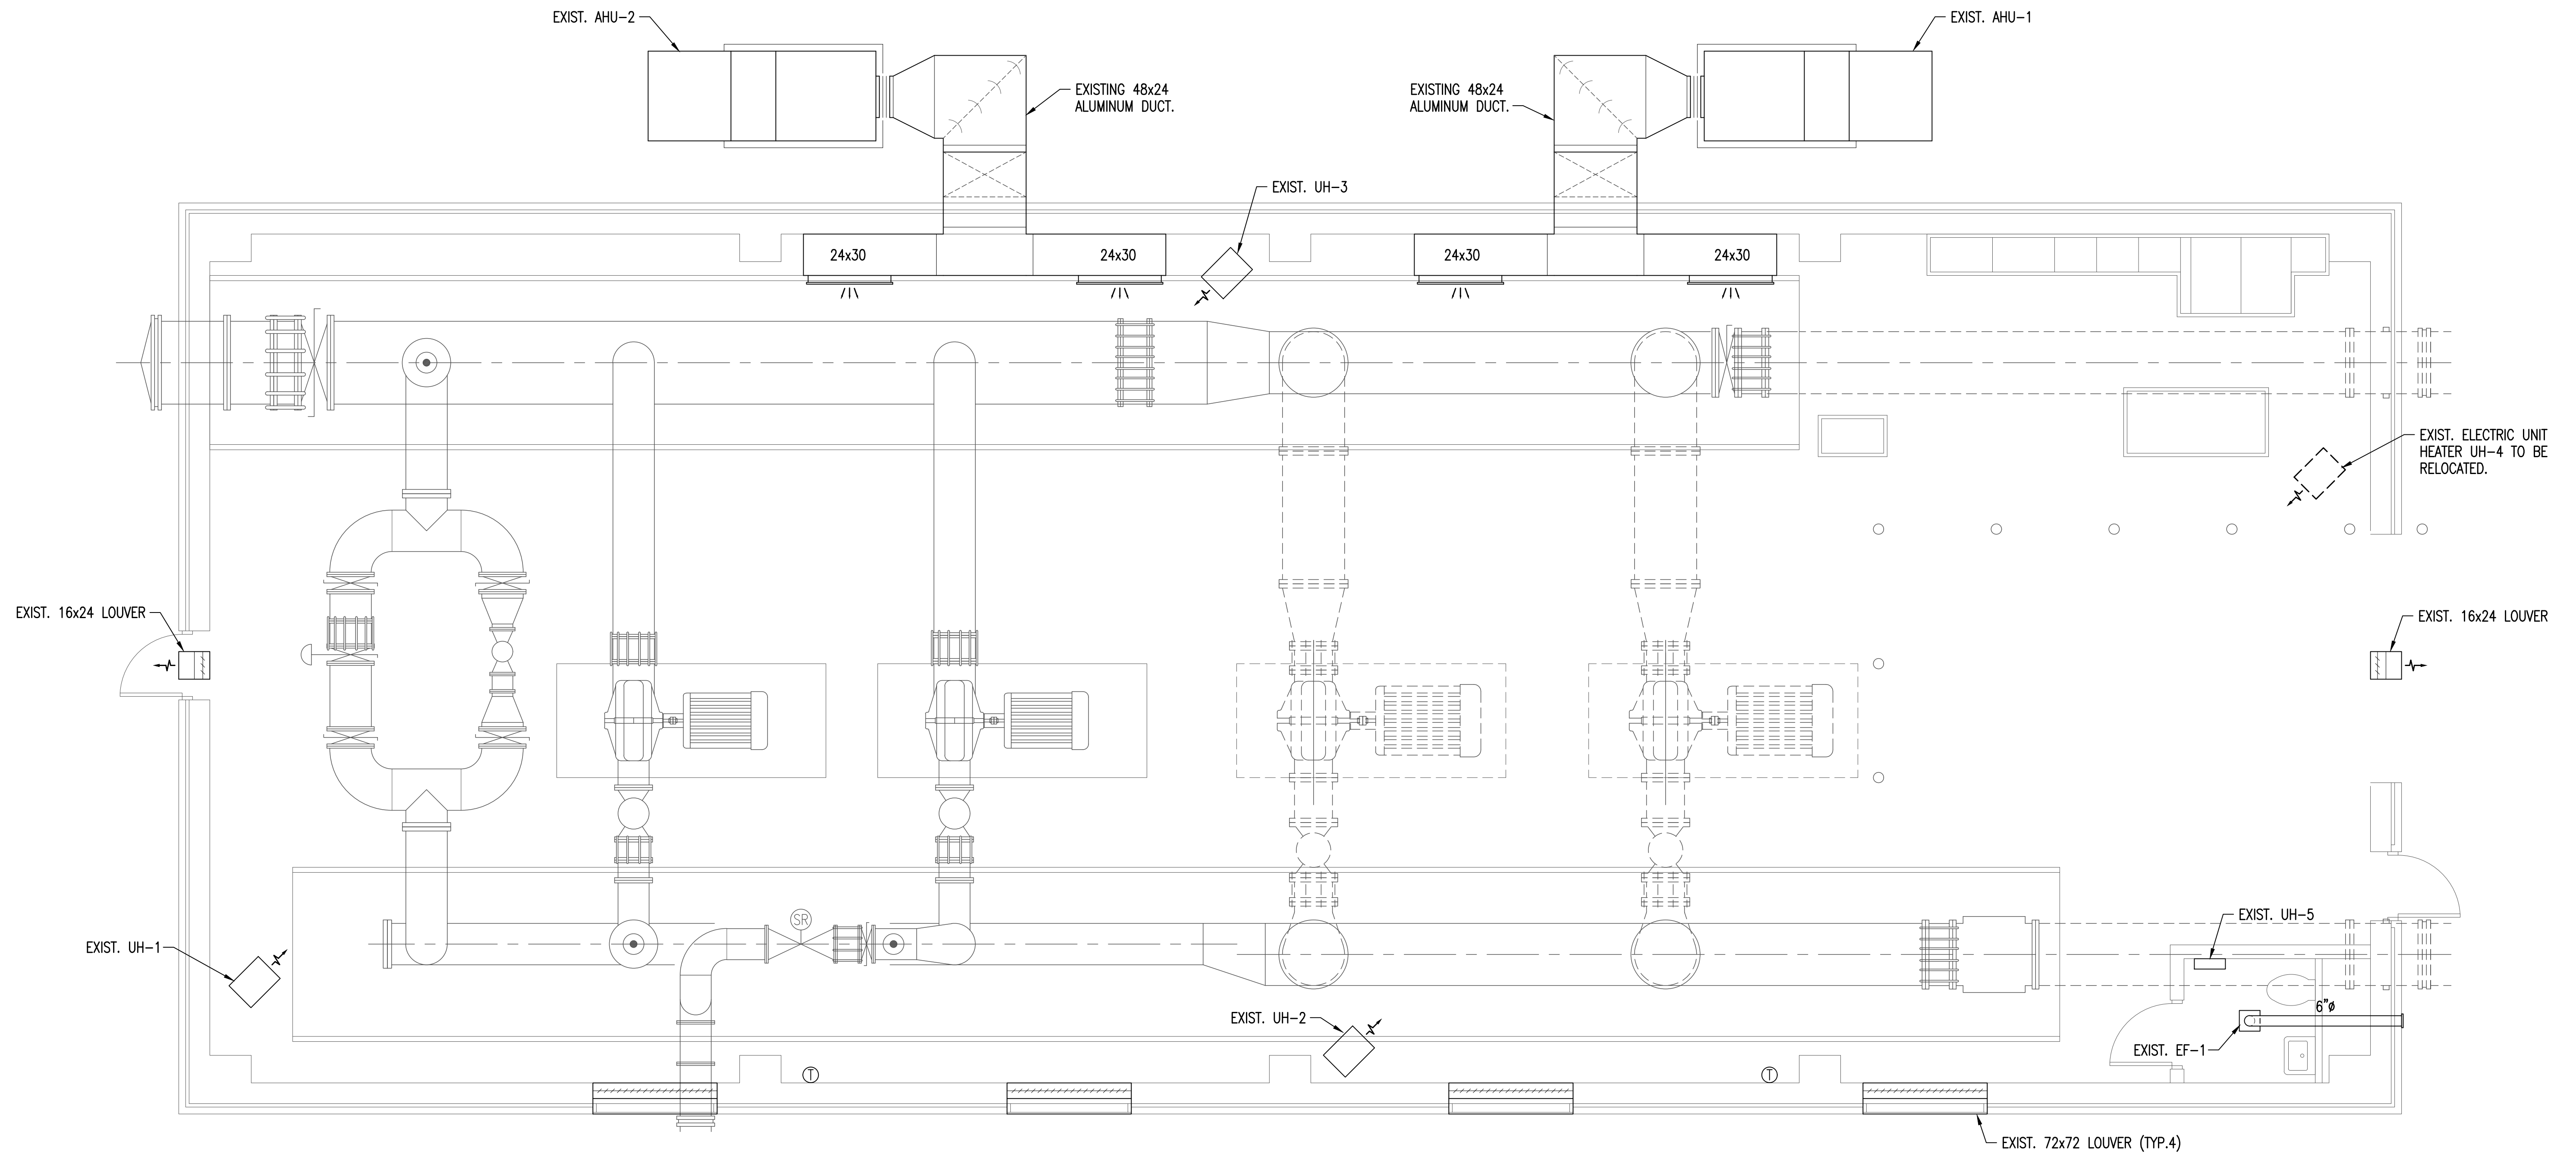


Saved: 02-05-2021 11:43:26 AM by MATT NEWMAN
 Plot Scale: 1:1 03-04-2021 4:50:13 PM by MATT NEWMAN
 U:\Wichita-Facil\2018\180537\000\Mech\Drawings\MDT01 MECHANICAL DEMOLITION FLOOR PLAN

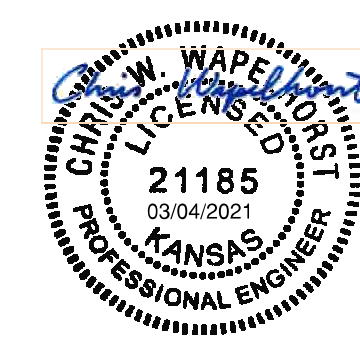

A **MECHANICAL DEMOLITION FLOOR PLAN**

0' 2' 4' 6' 10'
 SCALE: 1/4" = 1'-0"

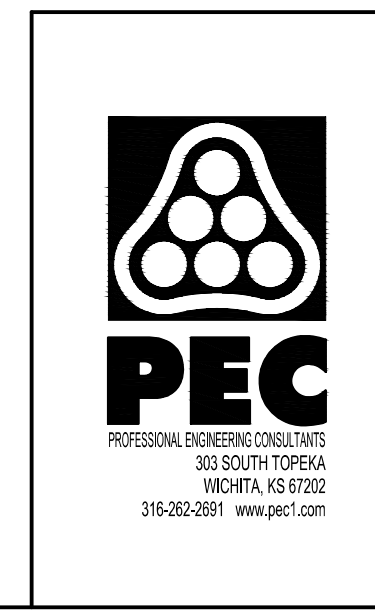

4			
3			
2			
1	CONSTRUCTION DOCUMENTS		03-04-21
No.	Revision	By	Date
CITY OF WICHITA, KANSAS			
MECHANICAL DEMOLITION FLOOR PLAN			
STANDBY POWER GENERATION - SOUTHEAST PUMP STATION			
Professional Engineering Consultants, P.A. 303 S. TOPEKA • WICHITA, KANSAS 67202 316-262-2691 • FAX 316-262-3003			
Designed by	CWW	Job No.	180537-000
Drawn by	MHN	Checked by	JBC
Date	MARCH 2021	Dwg No.	MD101