

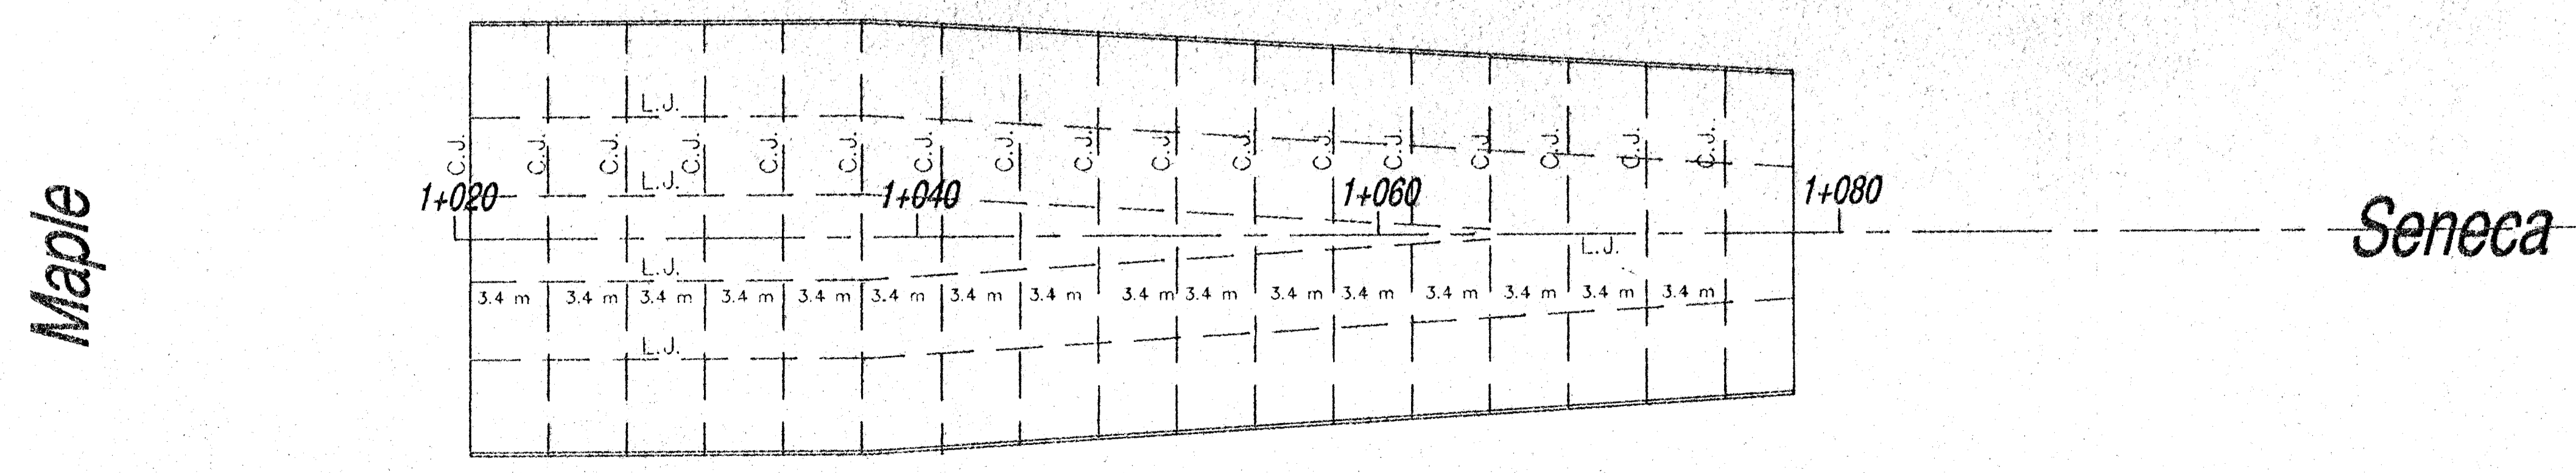


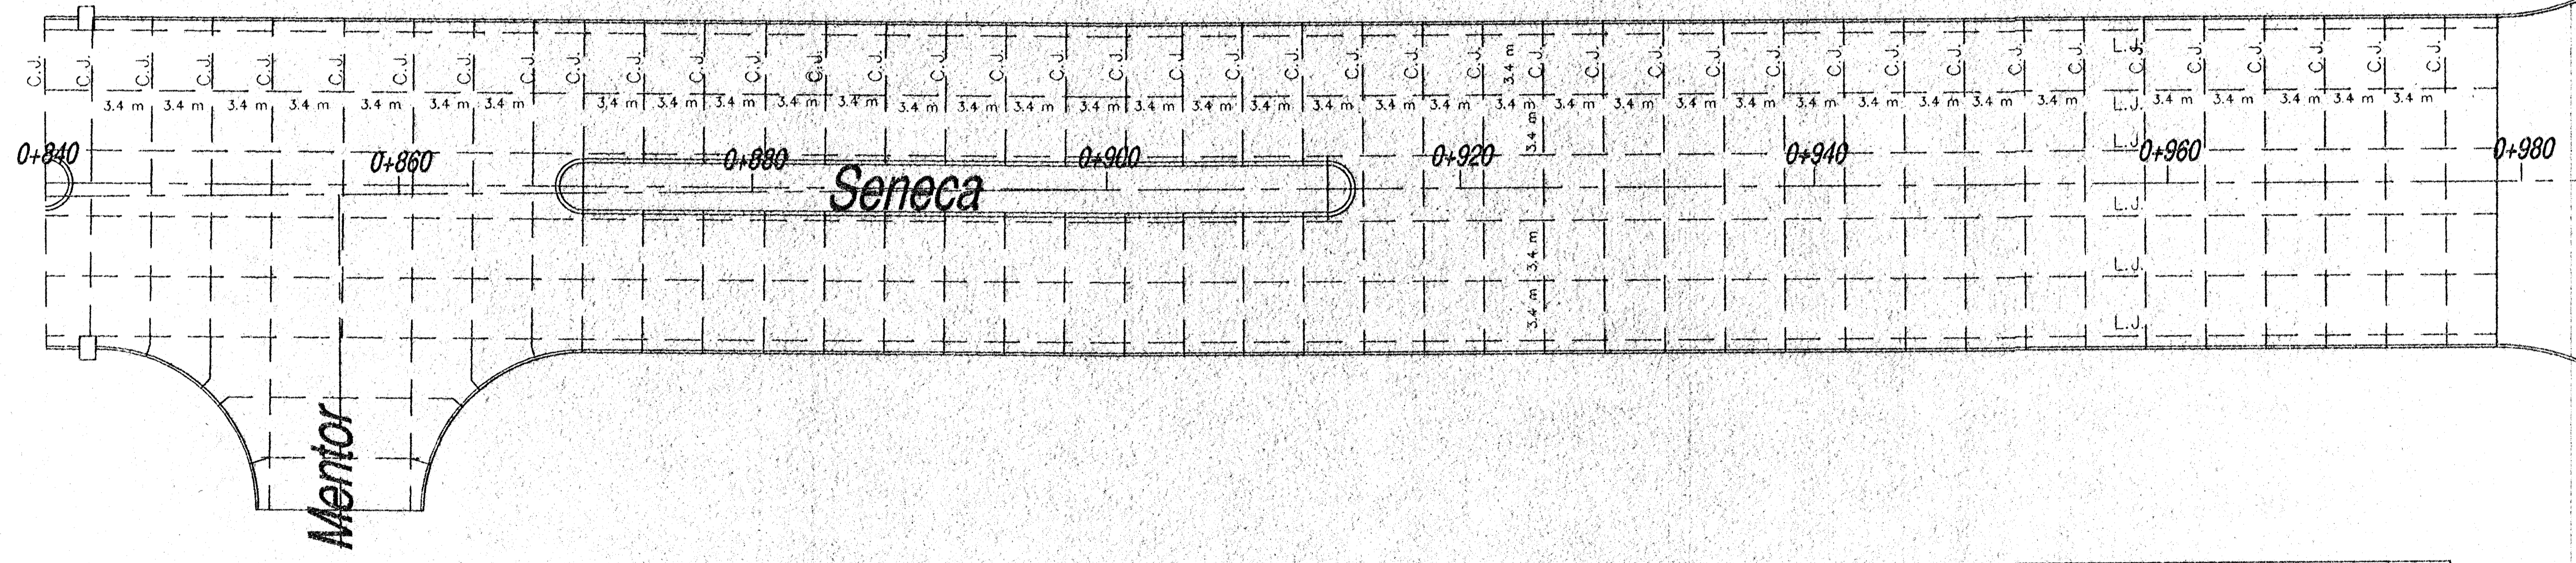

FHWA REG. NO.	STATE	PROJECT NO.:	YEAR	SHEET NUMBER	TOTAL SHEETS
7	KANSAS	87 N-0093-01	1999	8	68

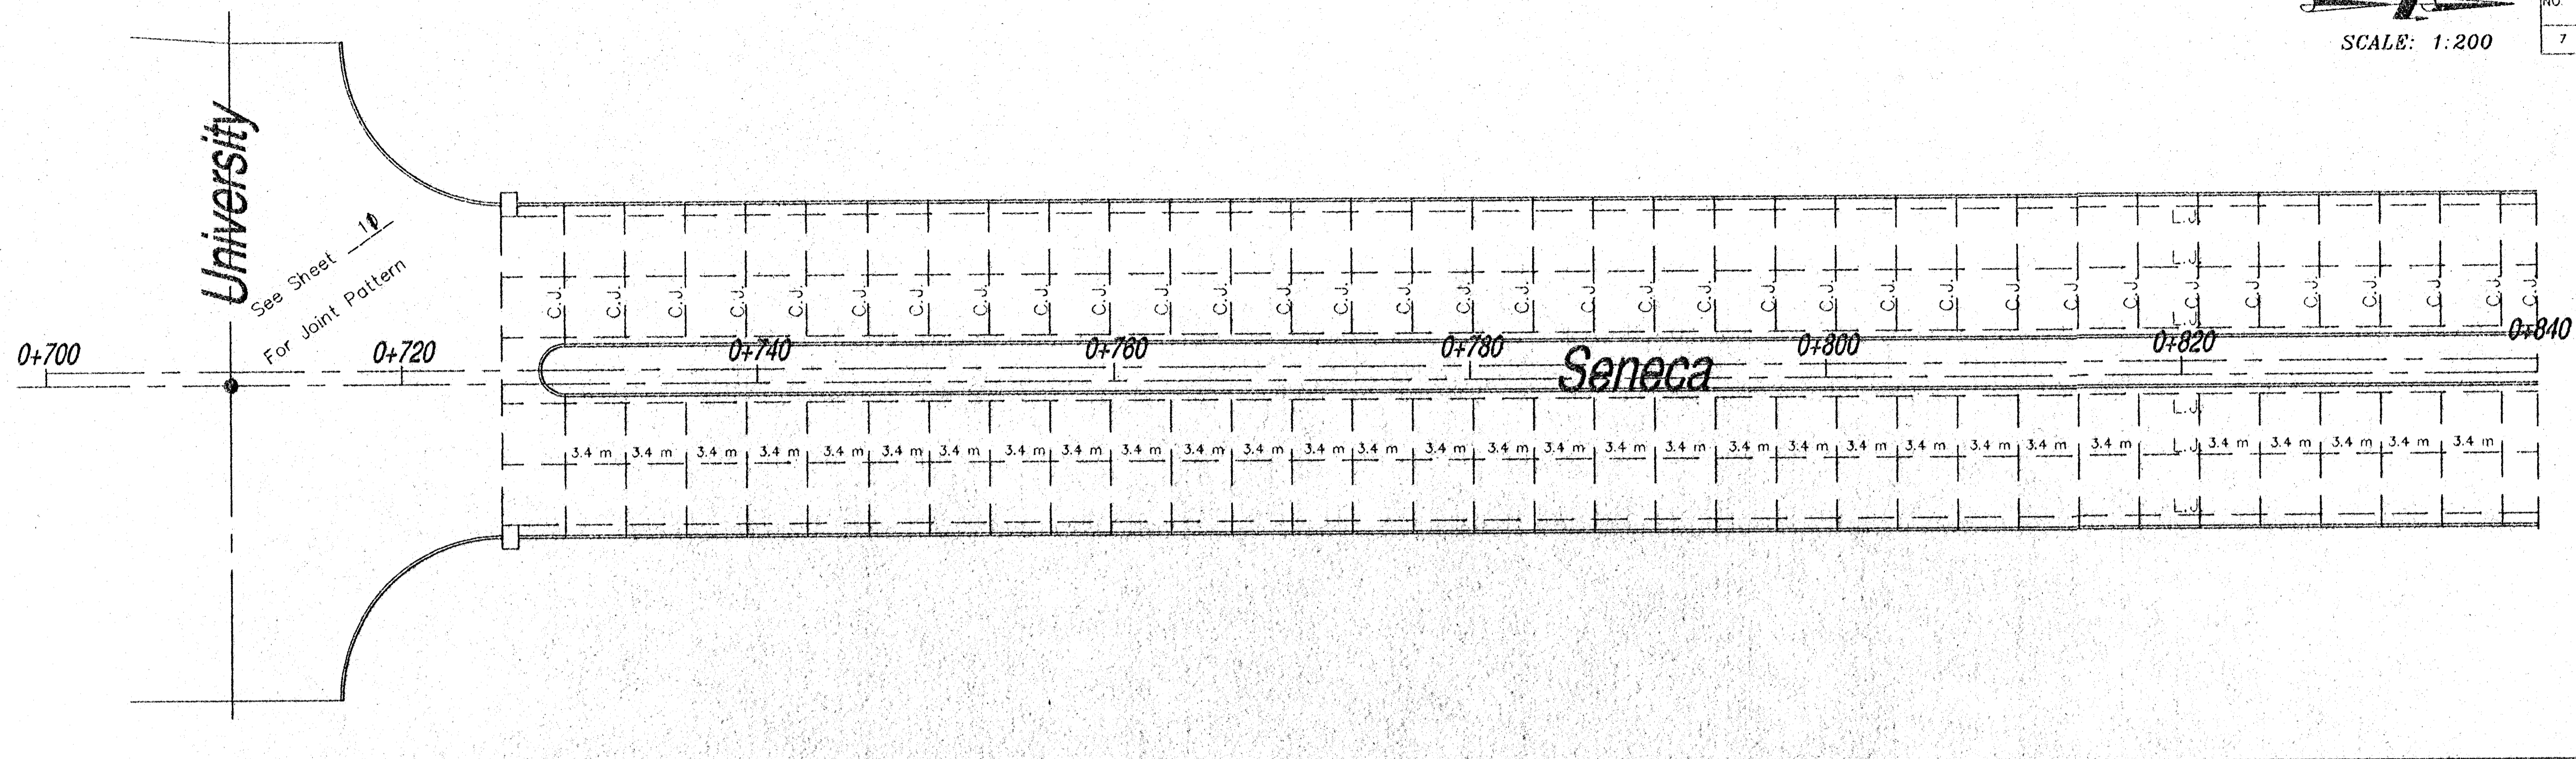

CONCRETE PAVING PLAN

L.J. Longitudinal Joints  
C.J. Contraction Joints

SCALE:	APPROVED:	DRAWN BY:
DATE:	CHECKED:	CHECKED:
PROJECT NO.	SHEET NO.:	SHEET NO.:

**ME** MUNICIPAL ENGINEERS, P.A.  
254-LAURA, SUITE 201, WICHITA, KANSAS 67211  
318-282-3942 (TEL.)  
318-282-8654 (FAX)

Maple

Maple

Mentor

University

Seneca

Seneca

Seneca