




G:\CIVIL\98026\GRADE\PHASE3\GRADE2.DWG, Wed Jun 07 13:28:18 2000

G:\CIVIL\98026\GRADE\PHASE3\GRADE2

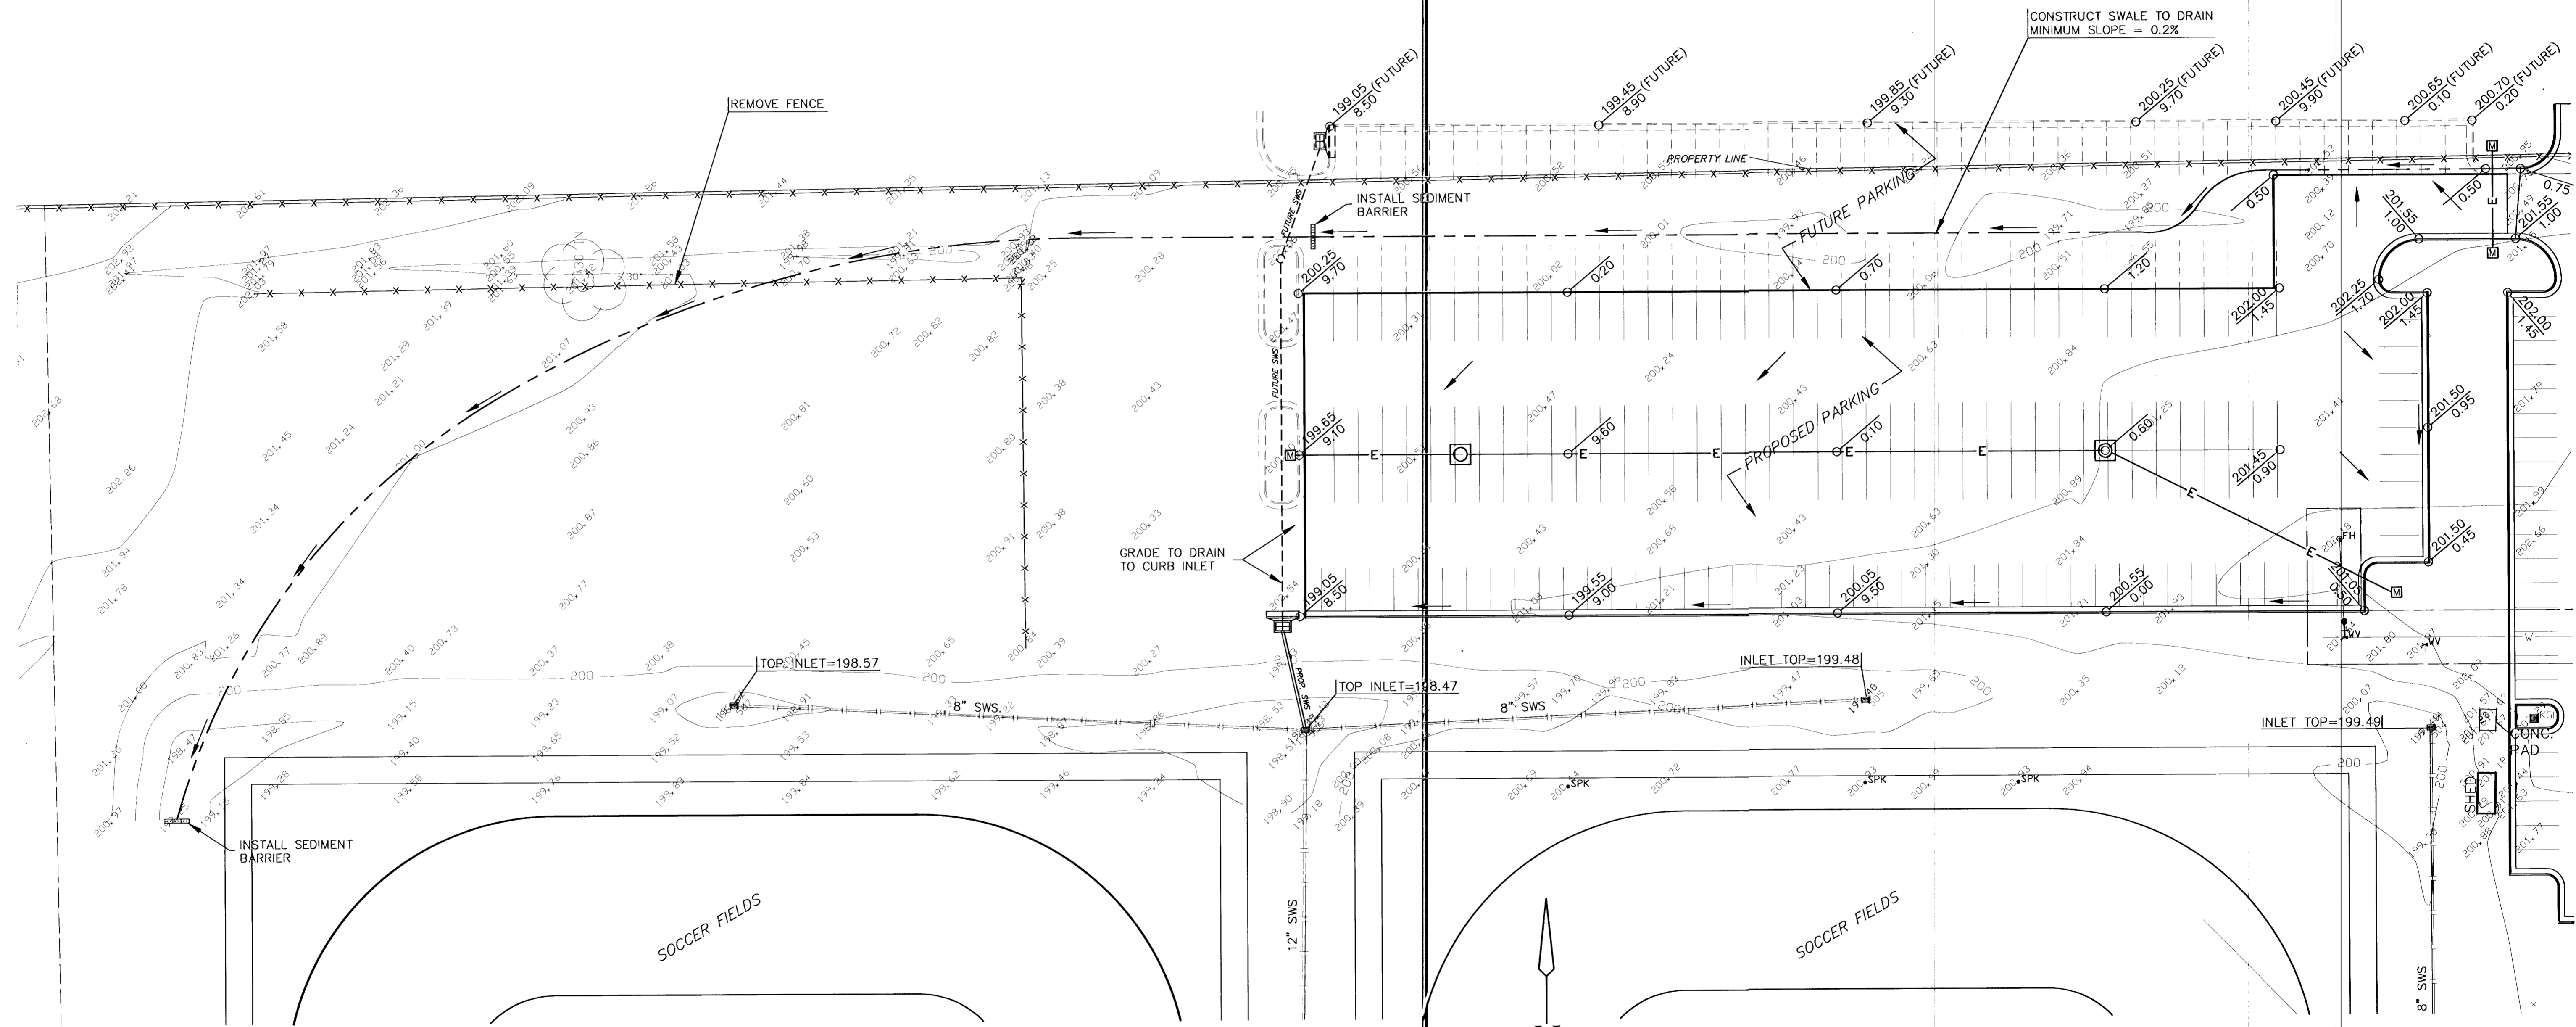

LEGEND

- _{GM} - GAS METER
- *_{TD} - TREE AND DIAMETER
- _{TD} - TREE AND DIAMETER
- △_{SC} - SECTION CORNER
- _{LP} - LIGHT POLE
- _{FH} - FIRE HYDRANT
- _{WV} - WATER VALVE
- _{WM} - WATER METER
- _{PP} - POWER POLE AND DEADMAN
- _{KE} - ELECTRIC BOX
- _{POLE} - POLE
- TRAF. MH - TRAFFIC SIGNAL MANHOLE
- △ - SECTION CORNER
- _{LP} - LIGHT POLE
- _{FH} - FIRE HYDRANT
- _{WV} - WATER VALVE
- _{WM} - WATER METER
- _{ICV} - IRRIGATION CONTROL VALVE
- TR
- EDGE OF TREES
- UNDERGROUND ELECTRIC LINE
- FENCE
- _{BM} - BENCHMARK
- _{SWMH} - STORM WATER MANHOLE
- _{SSMH} - SANITARY SEWER MANHOLE
- - TELEPHONE RISER
- STORM SEWER PIPE
- WATER LINE
- SANITARY SEWER LINE
- GAS LINE
- TELEPHONE LINE
- - INLET
- DIRECTION OF FLOW
- _{240.0}
○_{9.5} - PROP. SPOT ELEVATION
TOP # INDICATES TOP OF FULL CURB (WHERE APPLICABLE)
BOTTOM # INDICATES FLOW LINE (WHERE APPLICABLE)

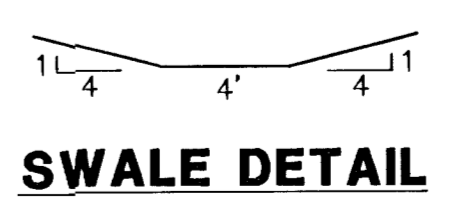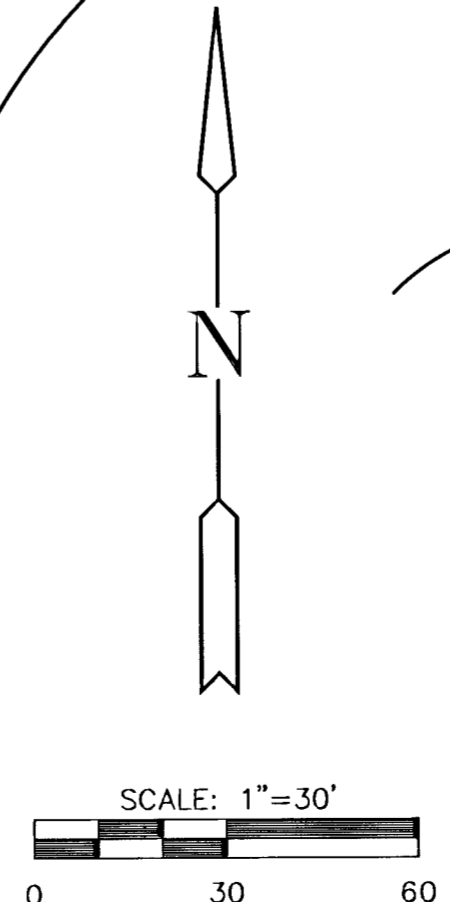

MID-KANSAS ENGINEERING
CONSULTANTS, INC.
411 N. WEBB ROAD
WICHITA, KS. 67206
316-684-9600

NORTHEAST BASEBALL/SOCCER COMPLEX
PROJECT NAME

GRADING PLAN
SHEET TITLE

GJA DESIGN BY:	GJR DRAWN BY:	GJA CHECKED BY:
MARCH 2000 DATE	98026 JOB NO.	3 / 7 SHEET/OF