
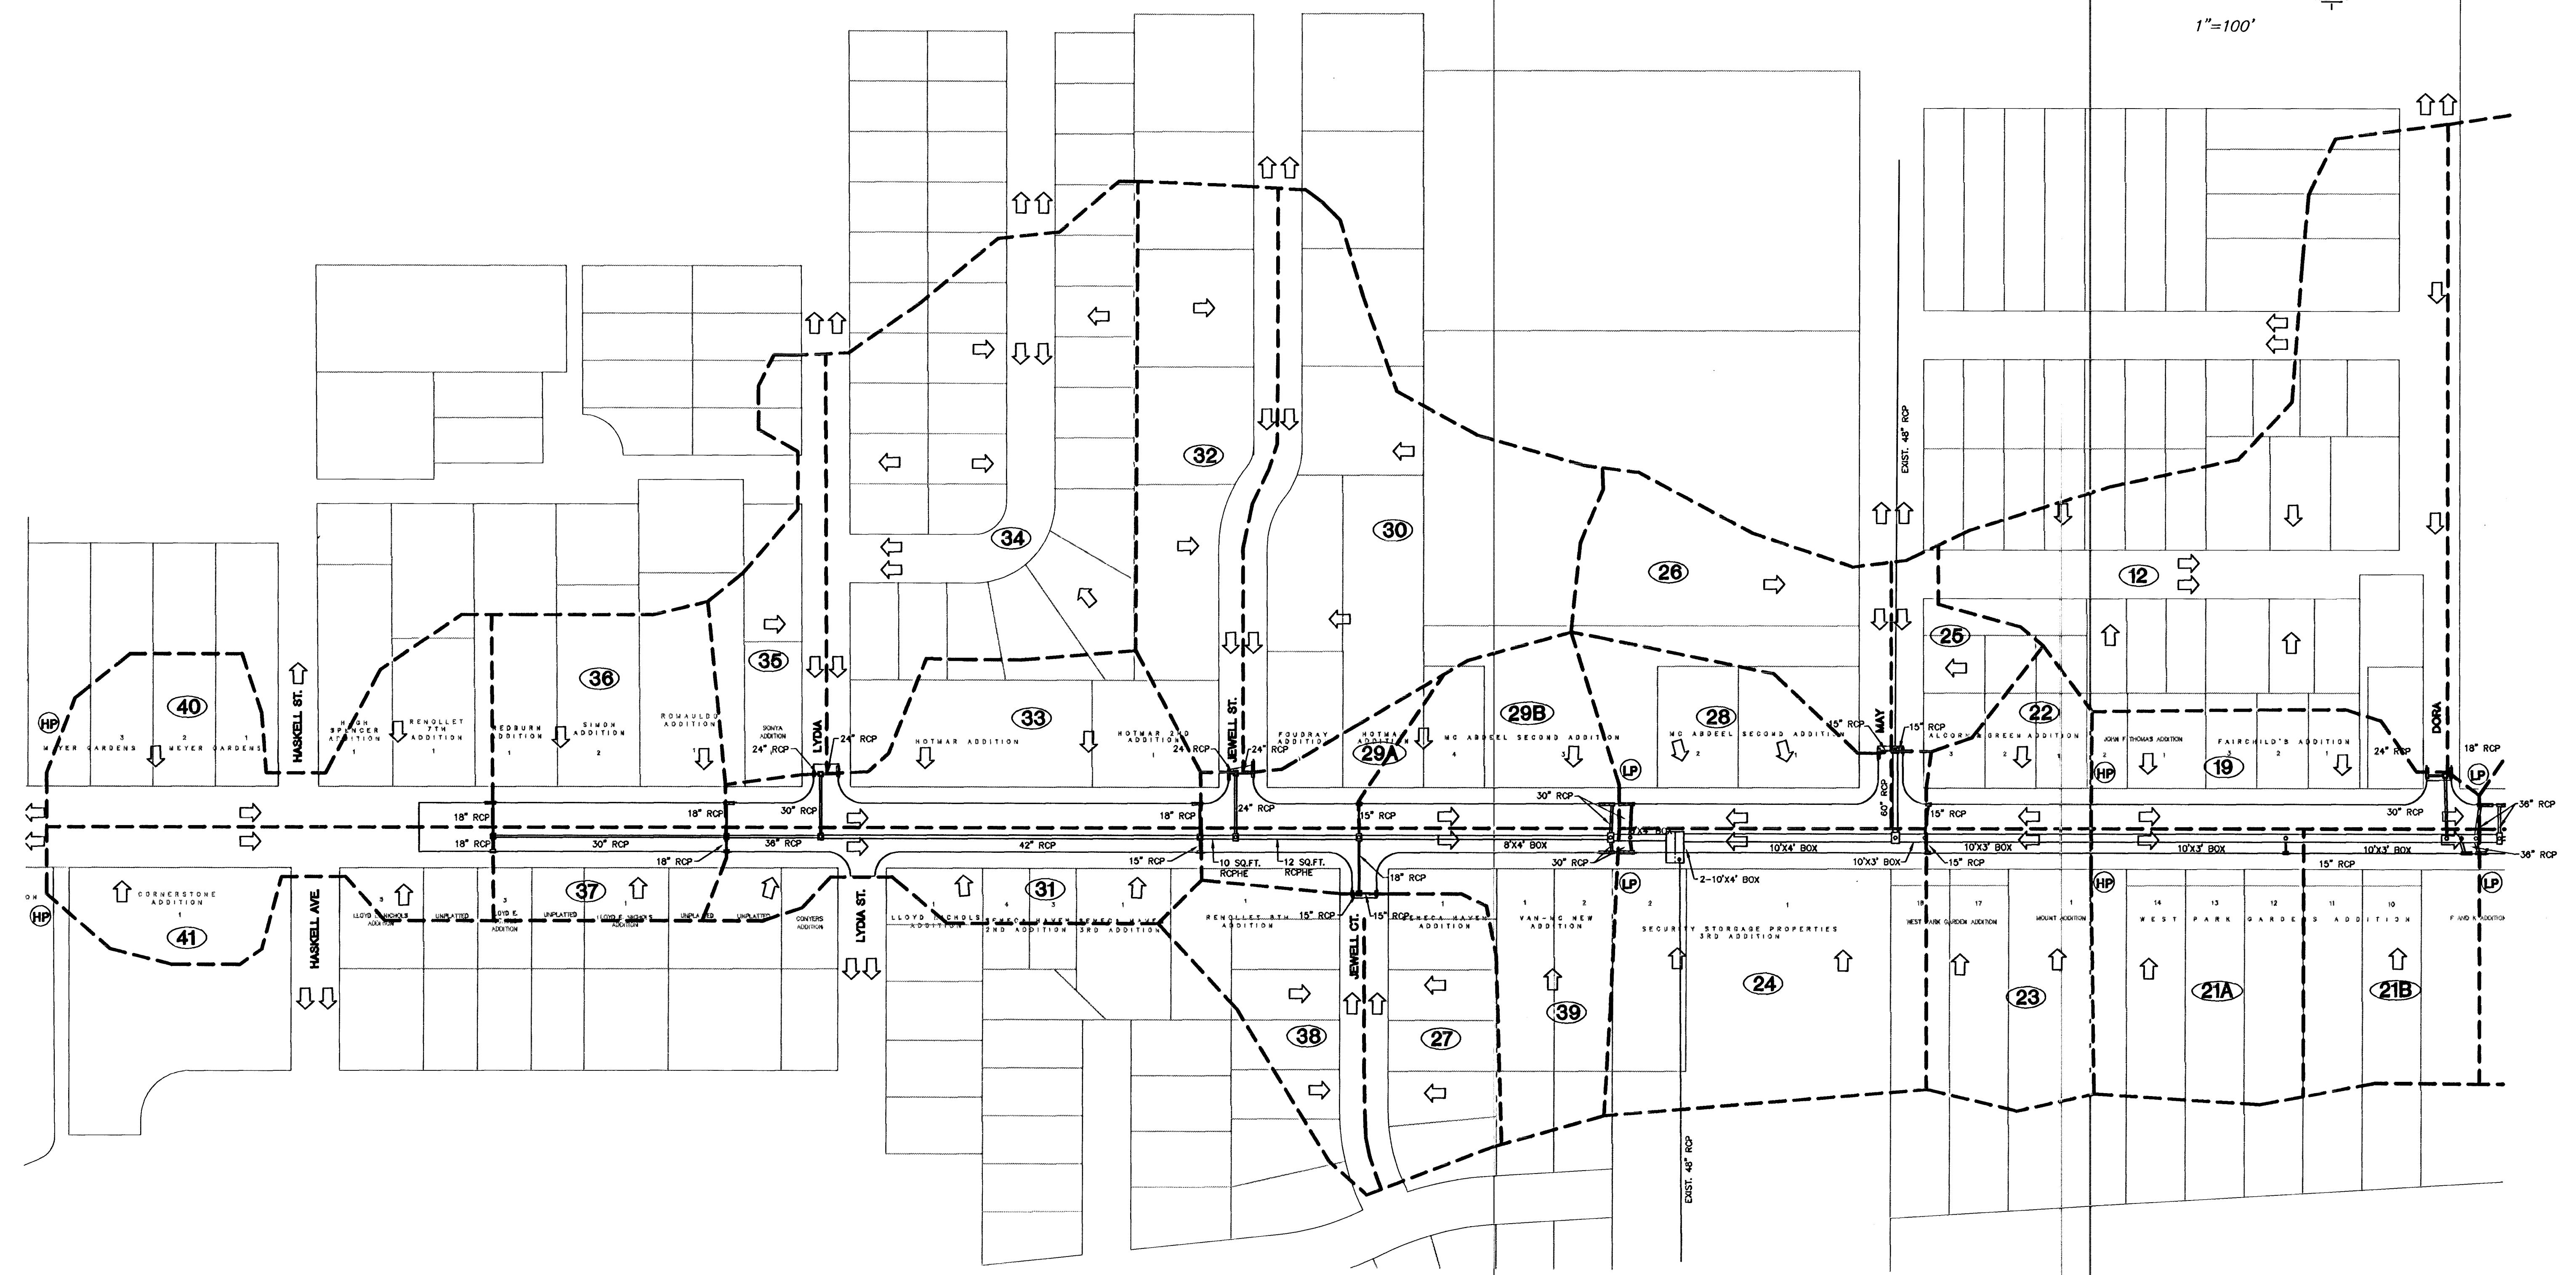


FHWA REG NO.	STATE	PROJECT NO.	YEAR	SHEET NO.	SHEETS
7	KANSAS	87N 0064-01	1997	106	130

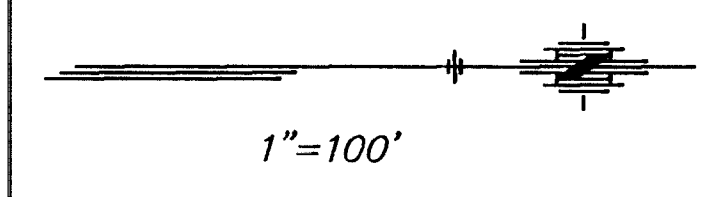

KANSAS DEPARTMENT OF TRANSPORTATION

**SOUTH SENECA STREET
DRAINAGE PLAN**

PROJECT NO. 87N 0064-01 SEDGWICK CO.

MID-KANSAS ENGINEERING CONSULTANTS, INC.
WICHITA, KANSAS

DESIGNED BY: GJA,PAF	CHECKED BY: GJA
DRAWN BY: PAF	DATE: 7/98

SHEET 106 OF 130

H:\CIVIL\SENECA\DRAWING\87N0064\87N0064.DWG 13:48:53 1997

944003DR1