
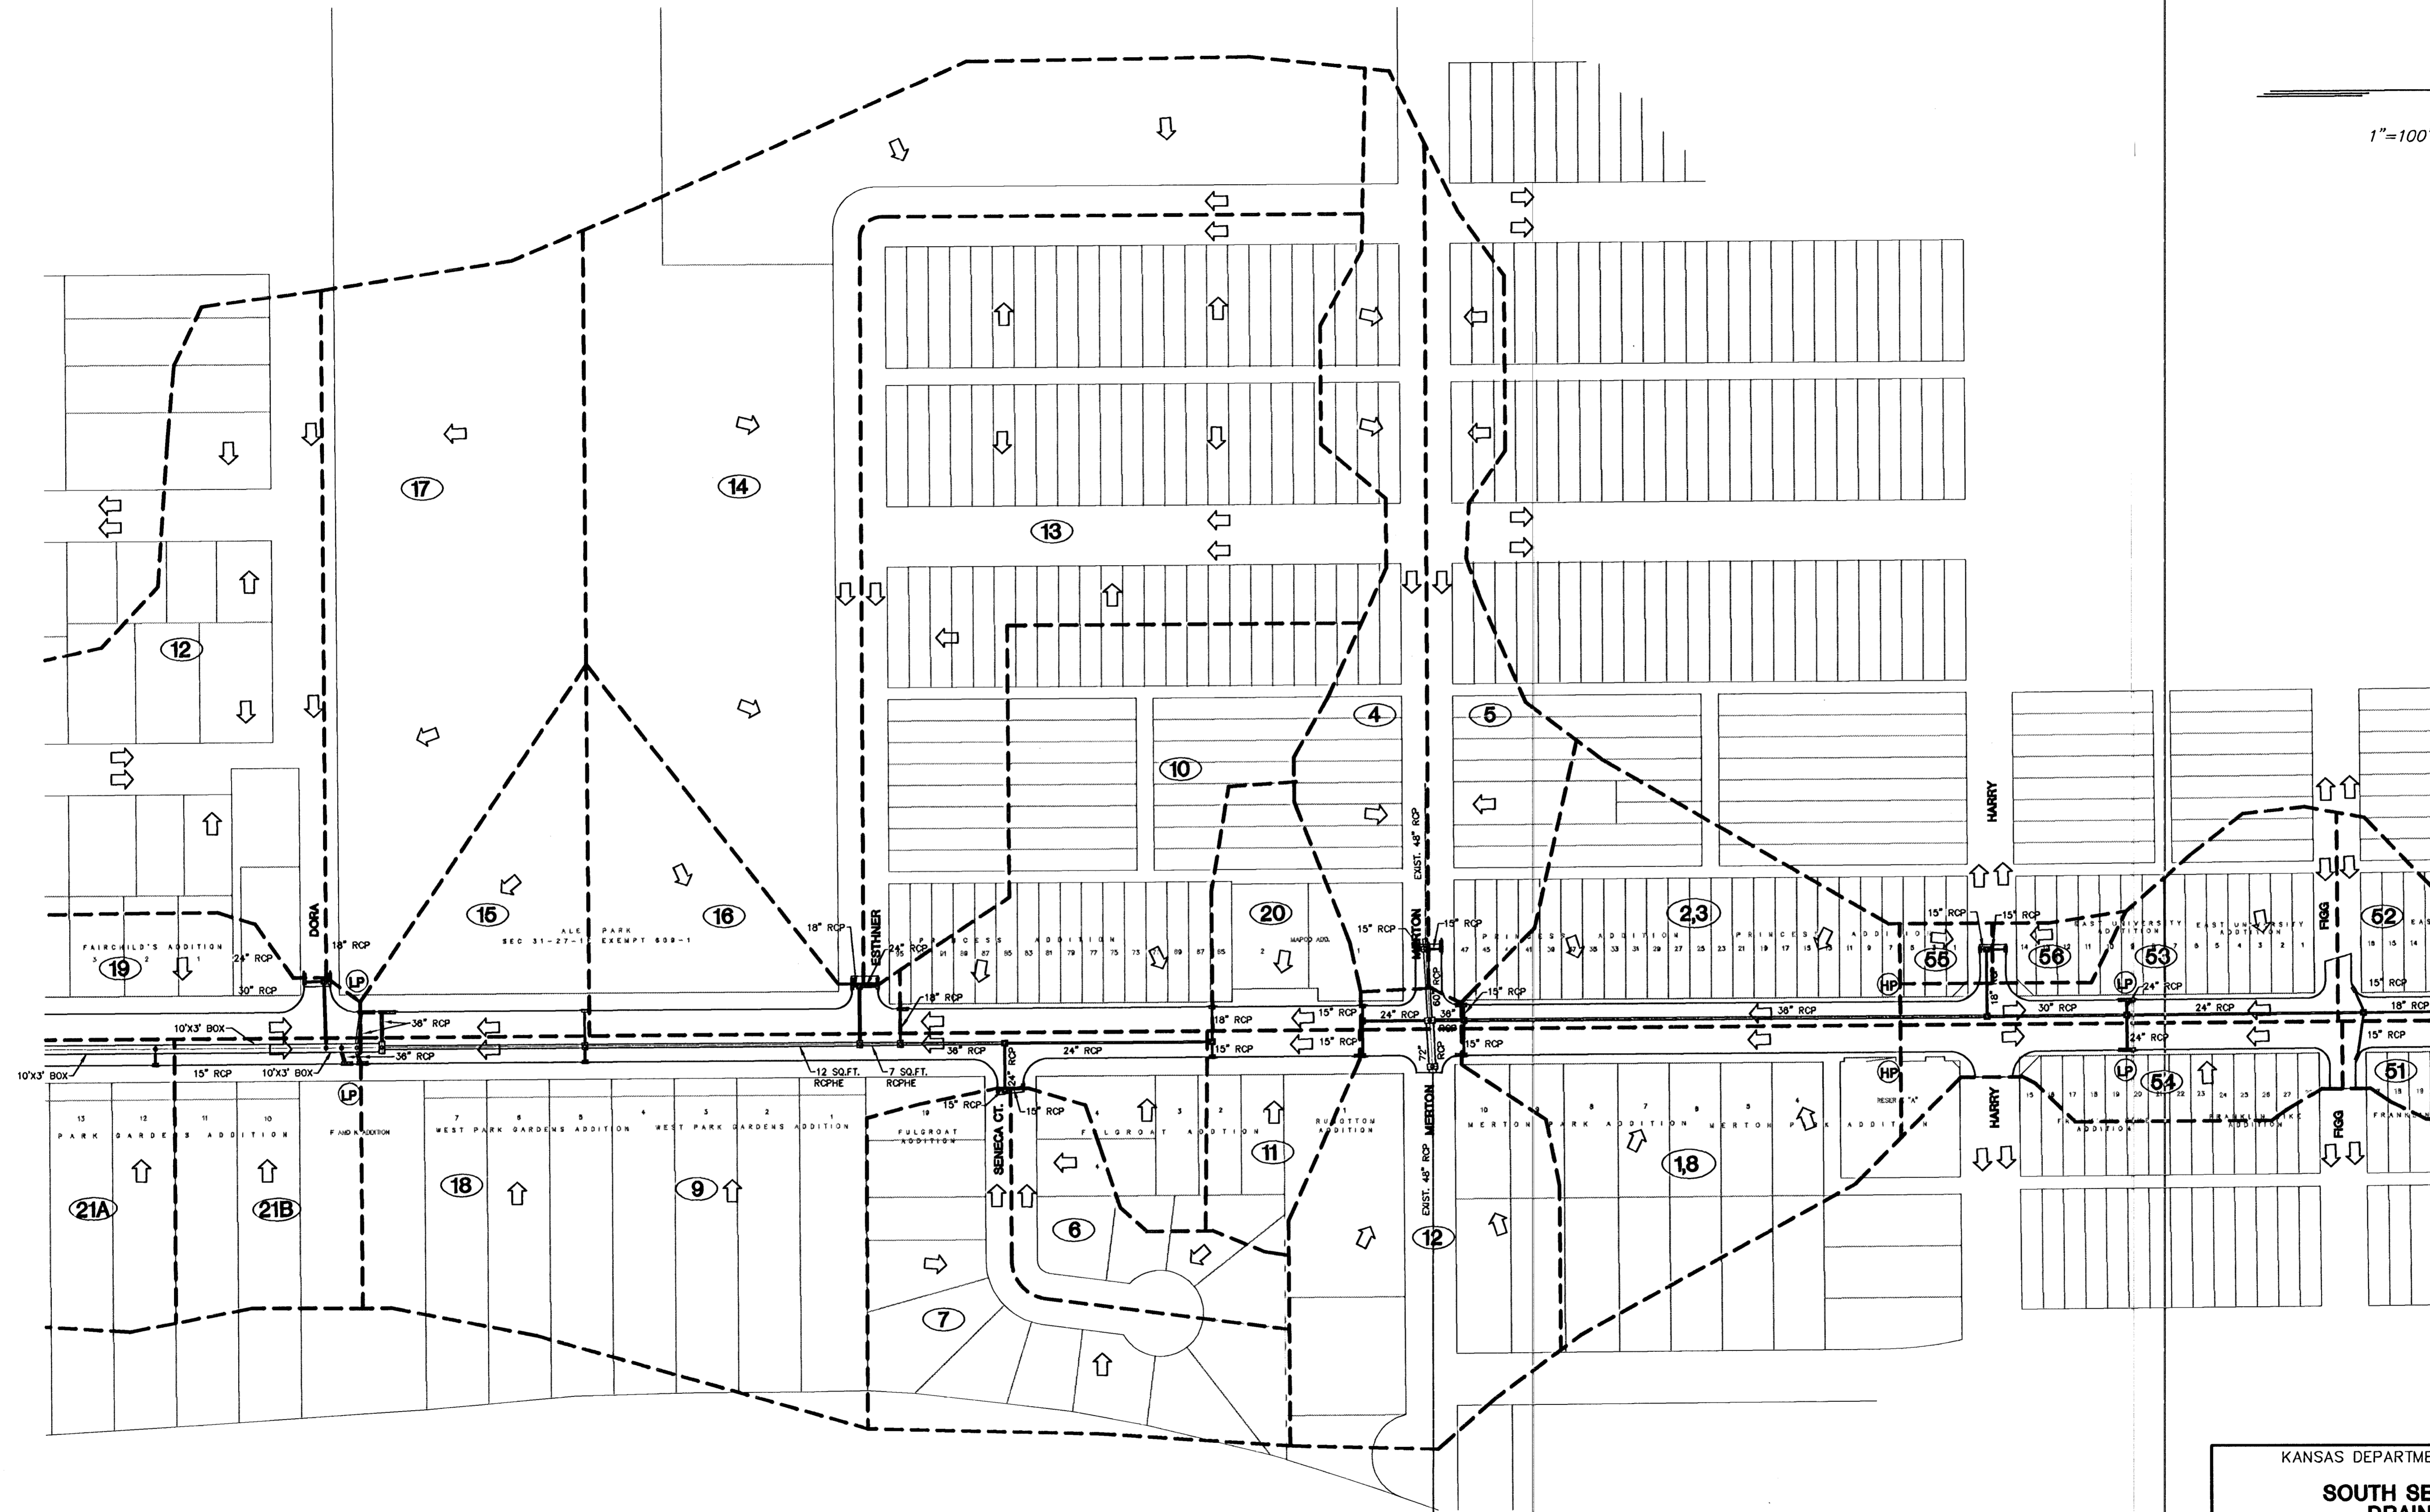


| FHWA REG NO. | STATE | PROJECT NO. | YEAR | SHEET NO. | SHEETS |
|--------------|--------|-------------|------|-----------|--------|
| 7 | KANSAS | 87N 0064-01 | 1997 | 107 | 130 |

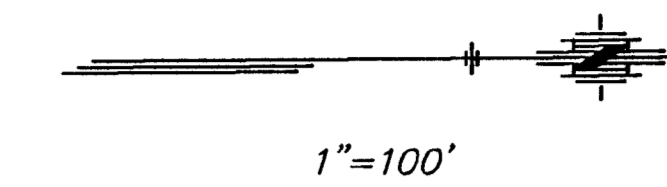

KANSAS DEPARTMENT OF TRANSPORTATION

**SOUTH SENECA STREET
DRAINAGE PLAN**

PROJECT NO. 87N 0064-01 SEDGWICK CO.

MID-KANSAS ENGINEERING CONSULTANTS, INC.
WICHITA, KANSAS

| | |
|----------------------|----------------------------------|
| DESIGNED BY: GJA,PAF | CHECKED BY: GJA |
| DRAWN BY: PAF | DATE: 7/98 SHEET 107 OF 130 |

94005DR2

H:\CIVIL\SENECA\94005\DRAINAGE\94005DR2 F11 May 30 13:51:19 1997