
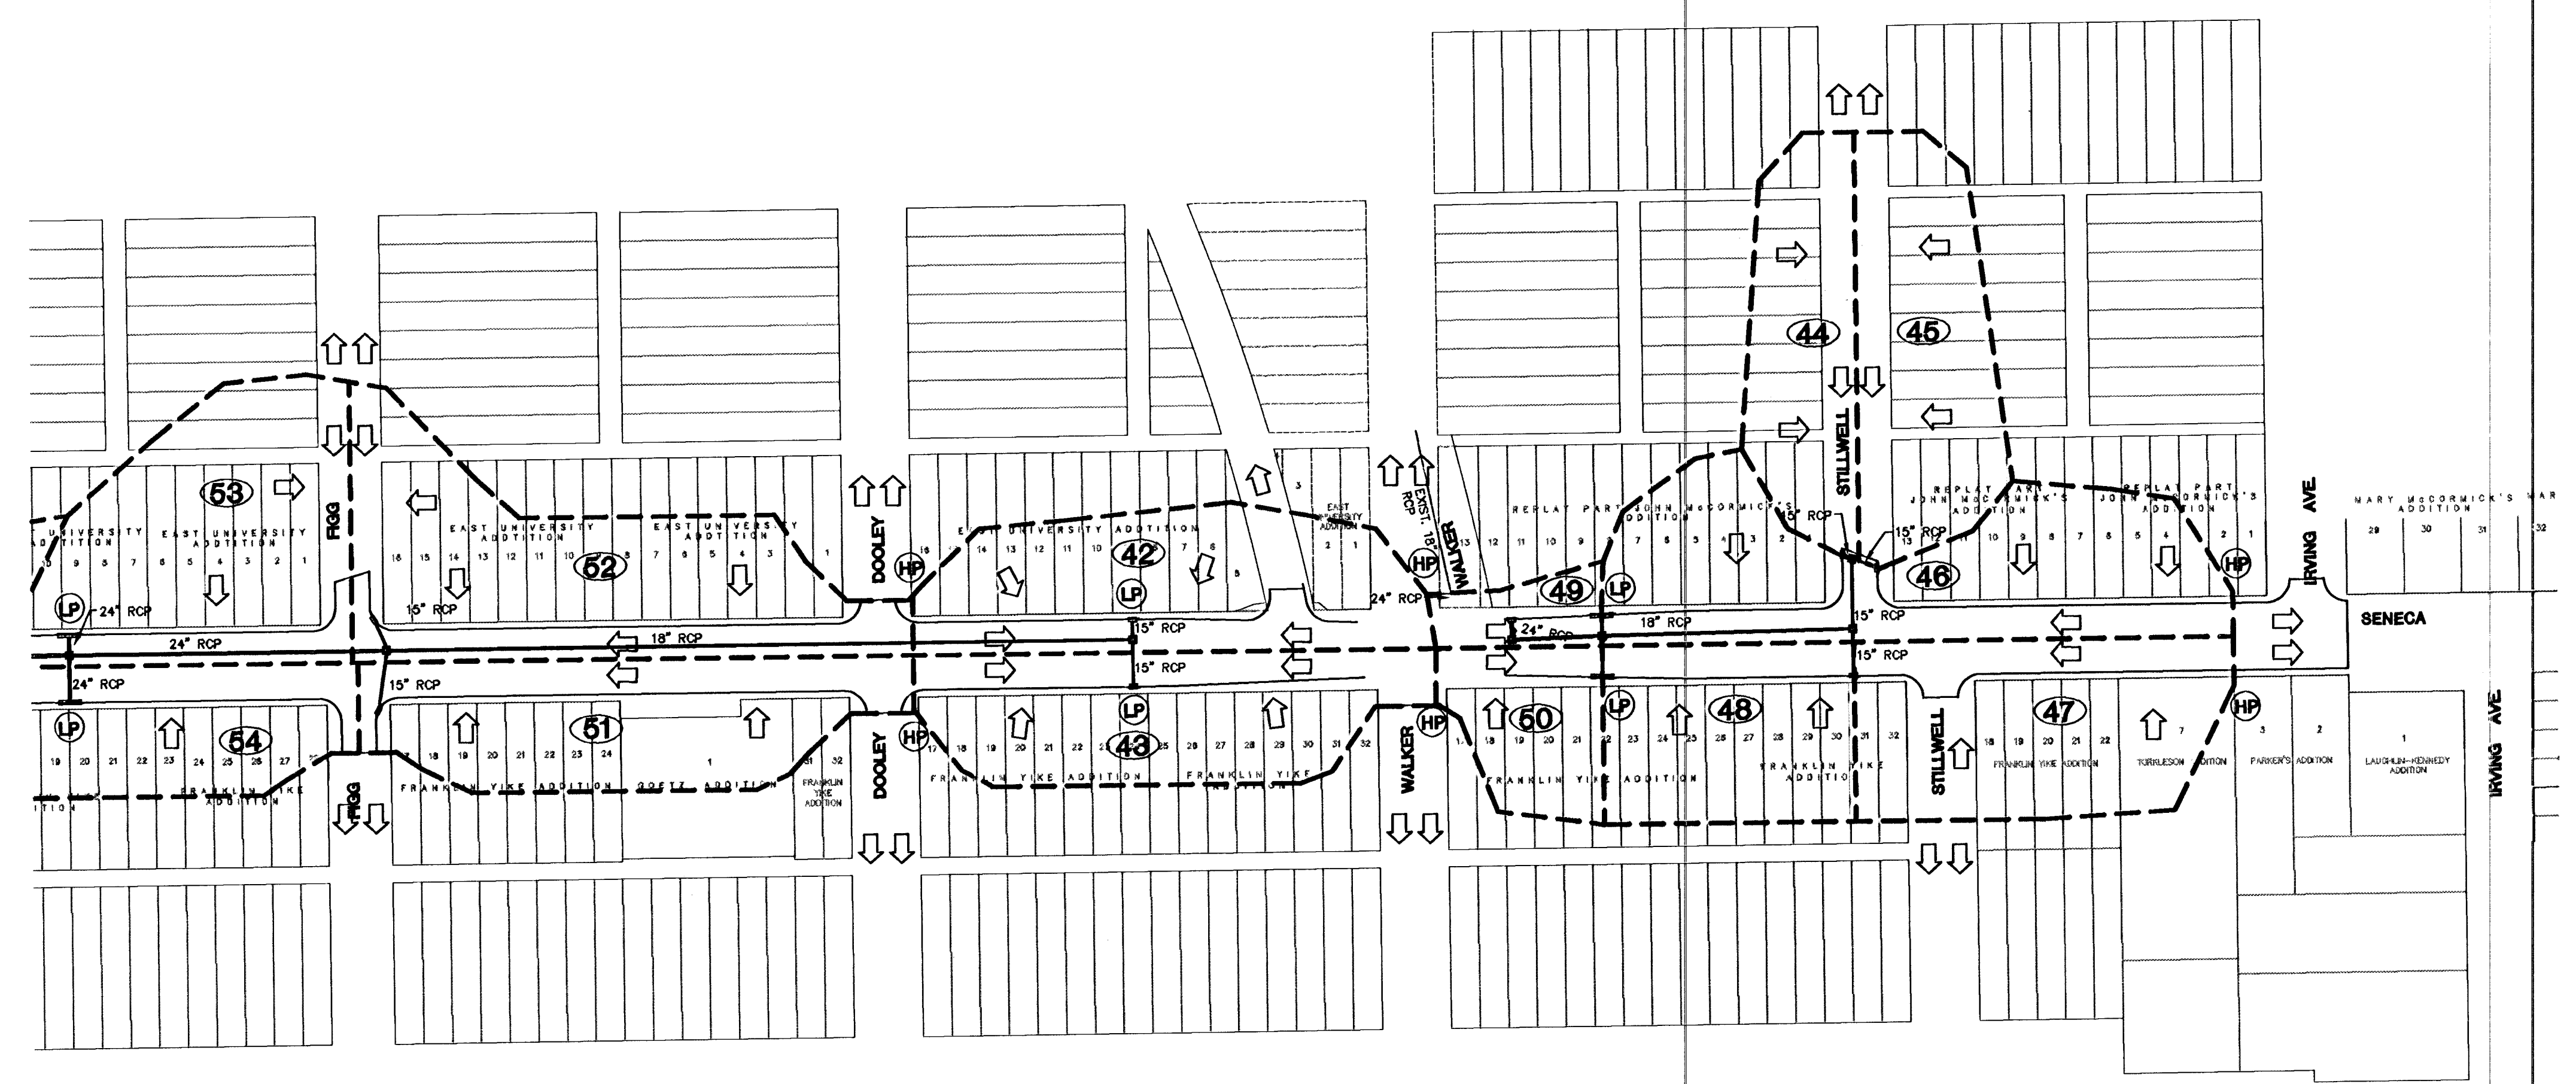


FHWA REG NO.	STATE	PROJECT NO.	YEAR	SHEET NO.	SHEETS
7	KANSAS	87N 0064-01	1997	108	130

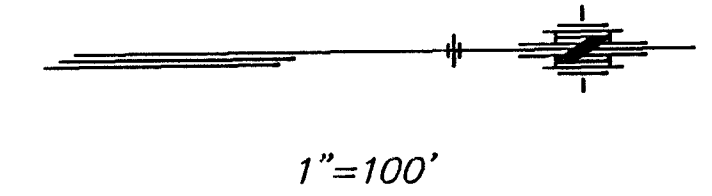

KANSAS DEPARTMENT OF TRANSPORTATION

**SOUTH SENECA STREET  
DRAINAGE PLAN**

PROJECT NO. 87N 0064-01      SEDGWICK CO.

**MID-KANSAS ENGINEERING CONSULTANTS, INC.**  
WICHITA, KANSAS

DESIGNED BY: GJA,PAF	CHECKED BY: GJA
DRAWN BY: PAF	DATE: 7/98      SHEET 108 OF 130

H:\CIVIL\SENECA\84005\DRAWING\84005DR3.FR, May 30 13:52:06 1997

84005DR3