


MAIN 16 OF THE FOUR MILE CREEK SEWER IN THE CITY OF WICHITA

OCA NO. 744115
CITY OF WICHITA PROJECT NO. 468-83803
JAMES L. ARMOUR, P.E. - CITY ENGINEER

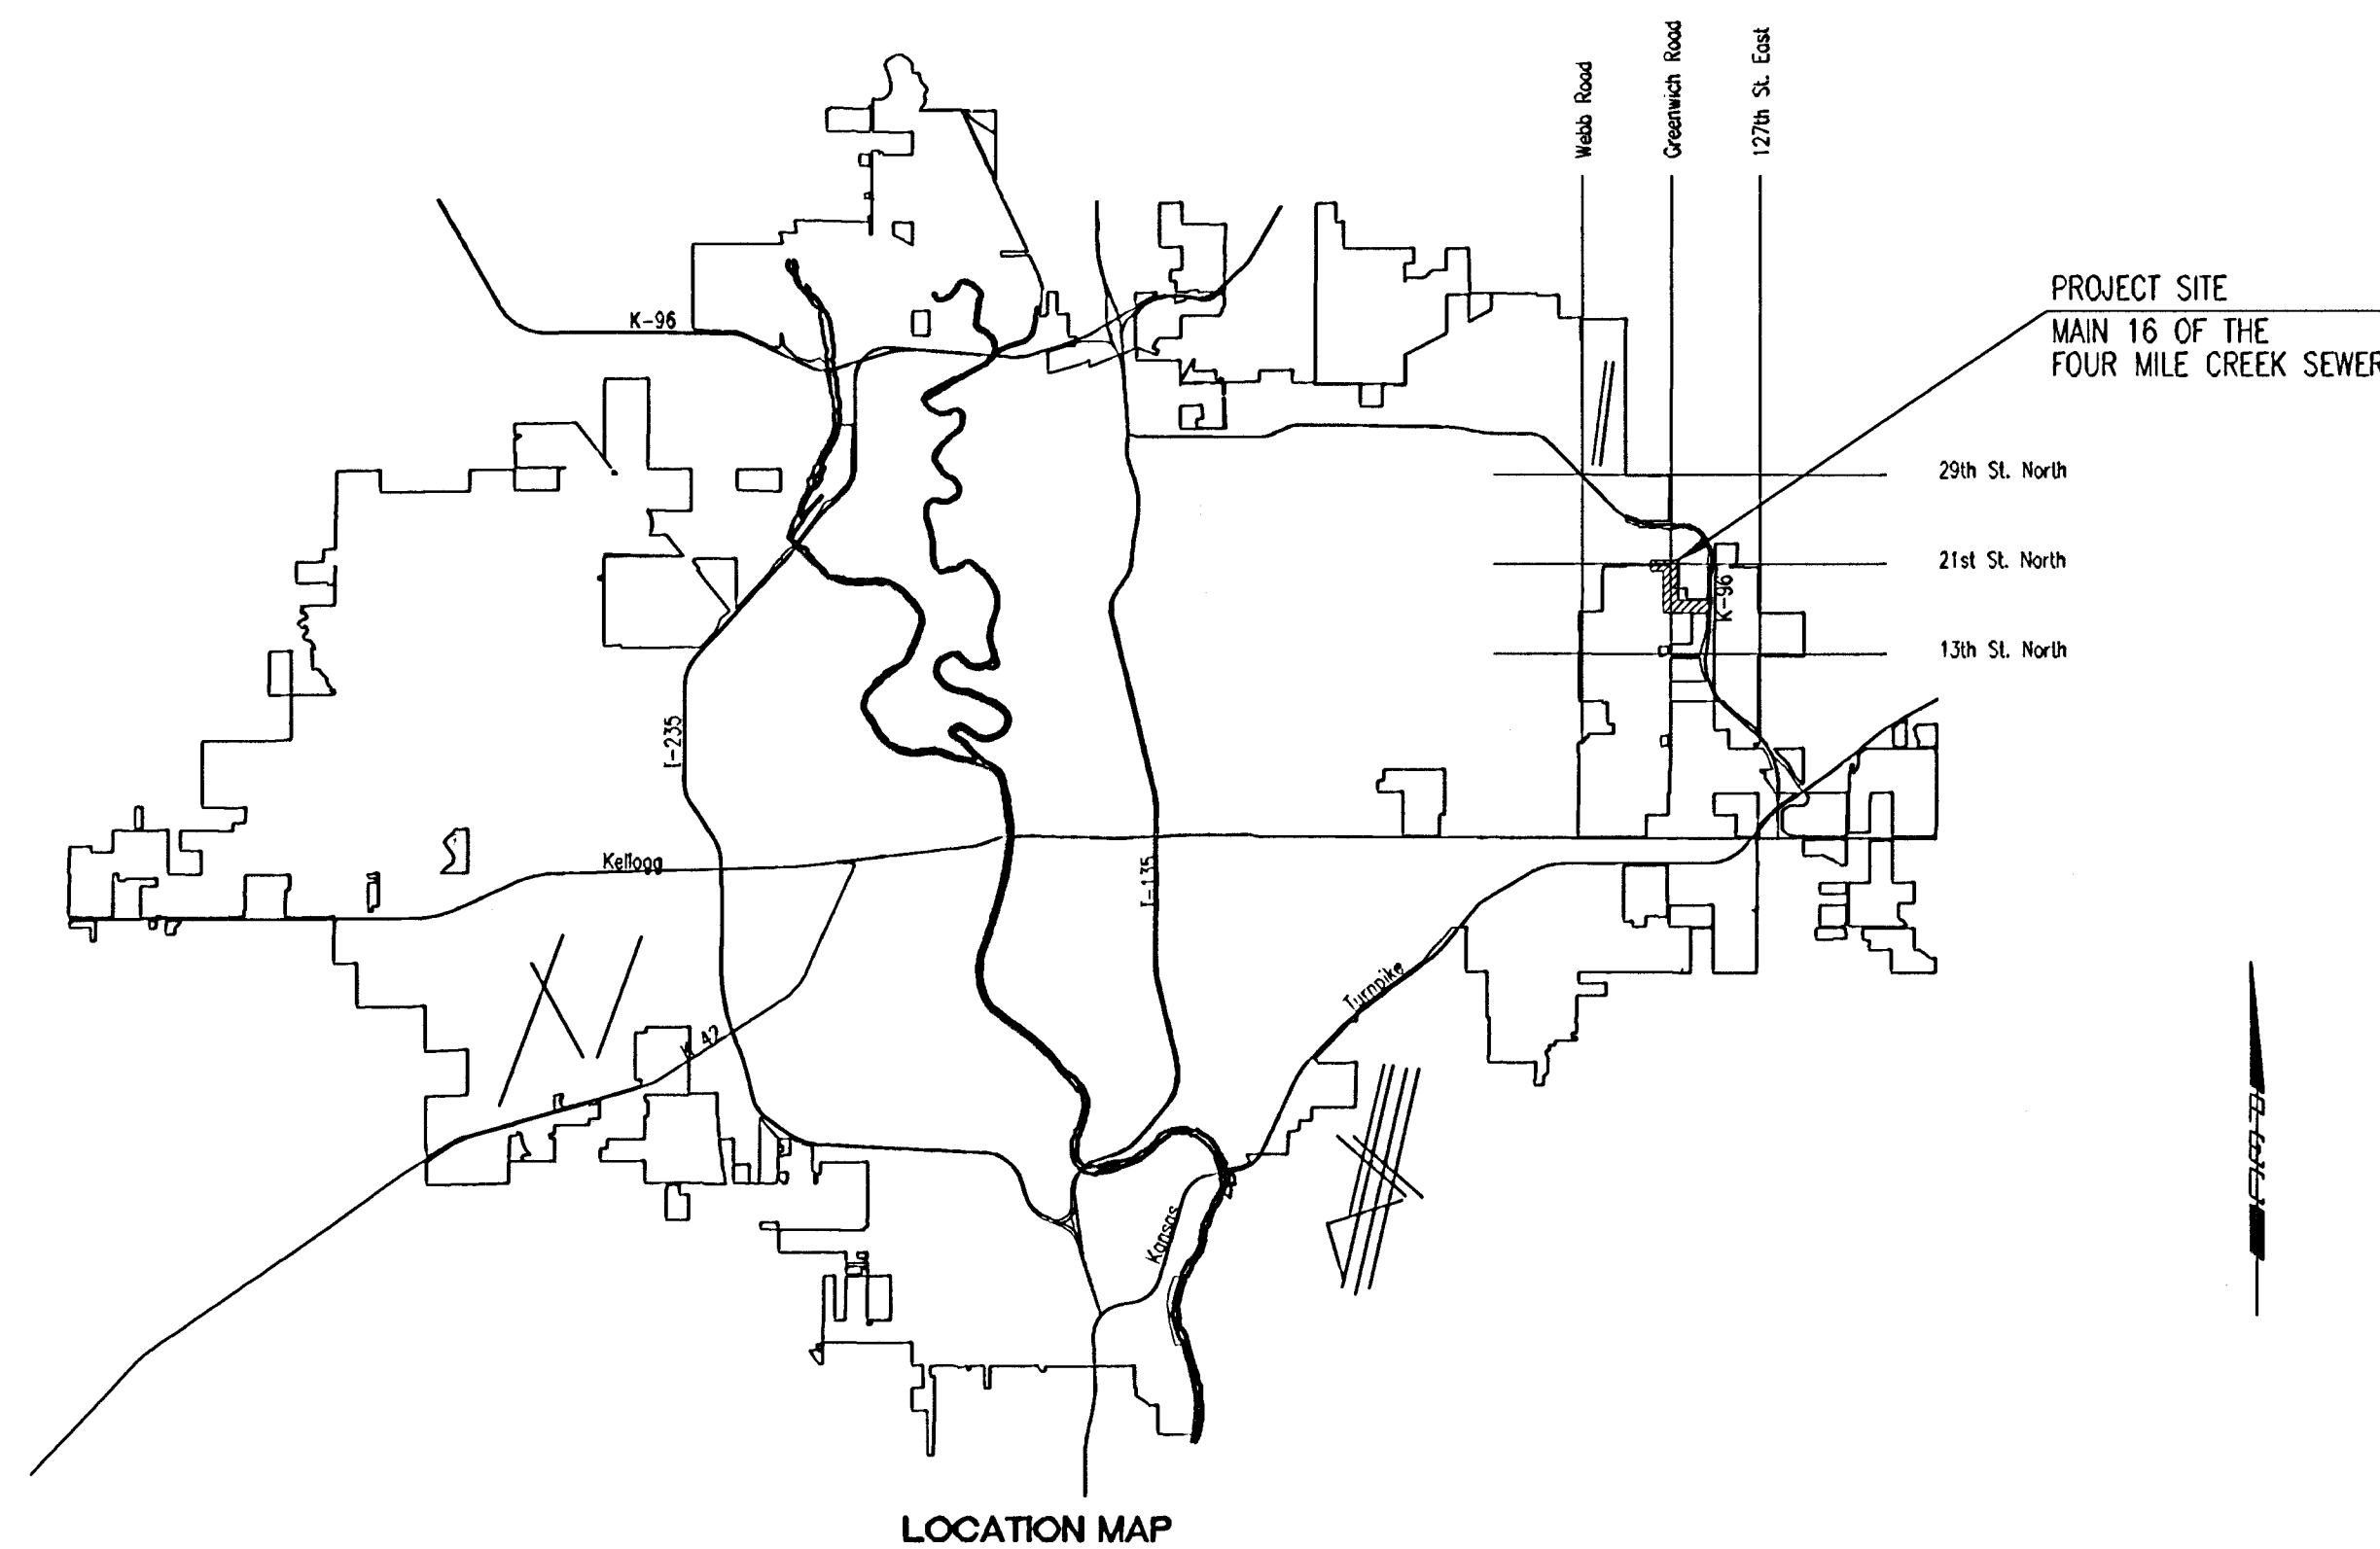


INDEX OF SHEETS

SHEET NO. 1	TITLE SHEET
SHEET NO. 2	KEY MAP AND GENERAL NOTES
SHEET NO. 3	HORIZONTAL/VERTICAL CONTROL
SHEET NO. 4-13	PLAN/PROFILE
SHEET NO. 14	PUMP STATION DEMOLITION AND GRADING PLAN
SHEET NO. 15	PUMP STATION ABANDONMENT
SHEET NO. 16	FORCE MAIN ABANDONMENT AND MISCELLANEOUS DETAILS
SHEET NO. 17-19	PLATS
SHEET NO. 20	TYPE "P" MANHOLE DETAILS
SHEET NO. 21	FRAME & COVER DETAILS
SHEET NO. 22	RISER DETAILS
SHEET NO. 23-26	SOIL EROSION BMP DETAILS

*Mies Construction, Inc. - Contractor
Strothman, City - Inspector
Released 12/5/05
As-Built
Stubs
.pdf by JDL 3/8/06*

MAY 2005
PLANS PREPARED BY
PROFESSIONAL ENGINEERING CONSULTANTS, P.A.
ENGINEERS
WICHITA, KANSAS

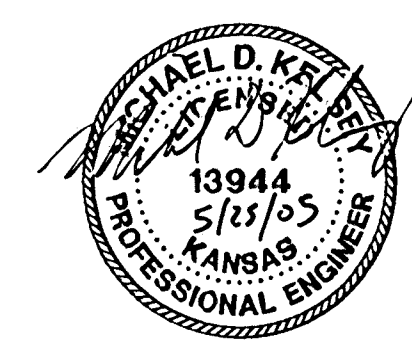

DSNR: MDK OPER: JAC SCALE: 1=1.00
G:\2004\04215\002\SSITILE 05-24-2005 03:09:33 pm