




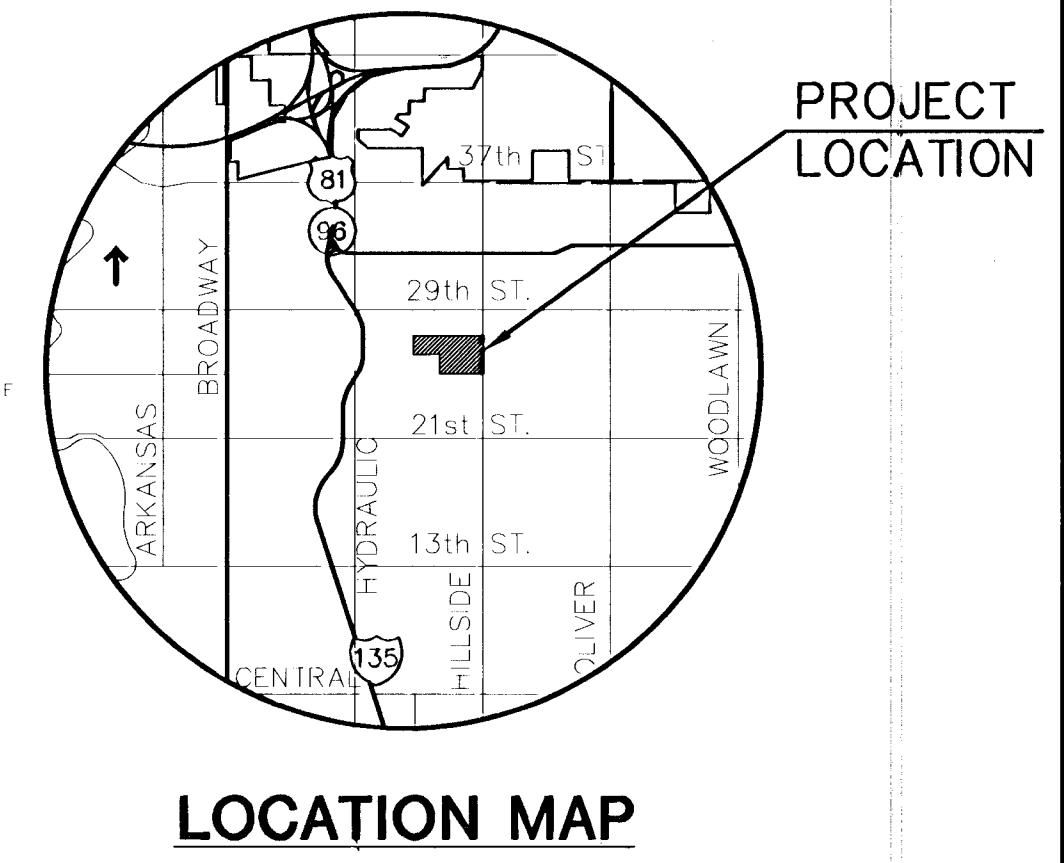

- LEGEND**
- 2" UNDERGROUND SCHEDULE 40 PVC CONDUIT WITH PULL CORD. BURY 36" BELOW FINISHED GRADE.
 - ⊗ NEW SITE LIGHTING POLES PROVIDED AND INSTALLED BY KG&E.

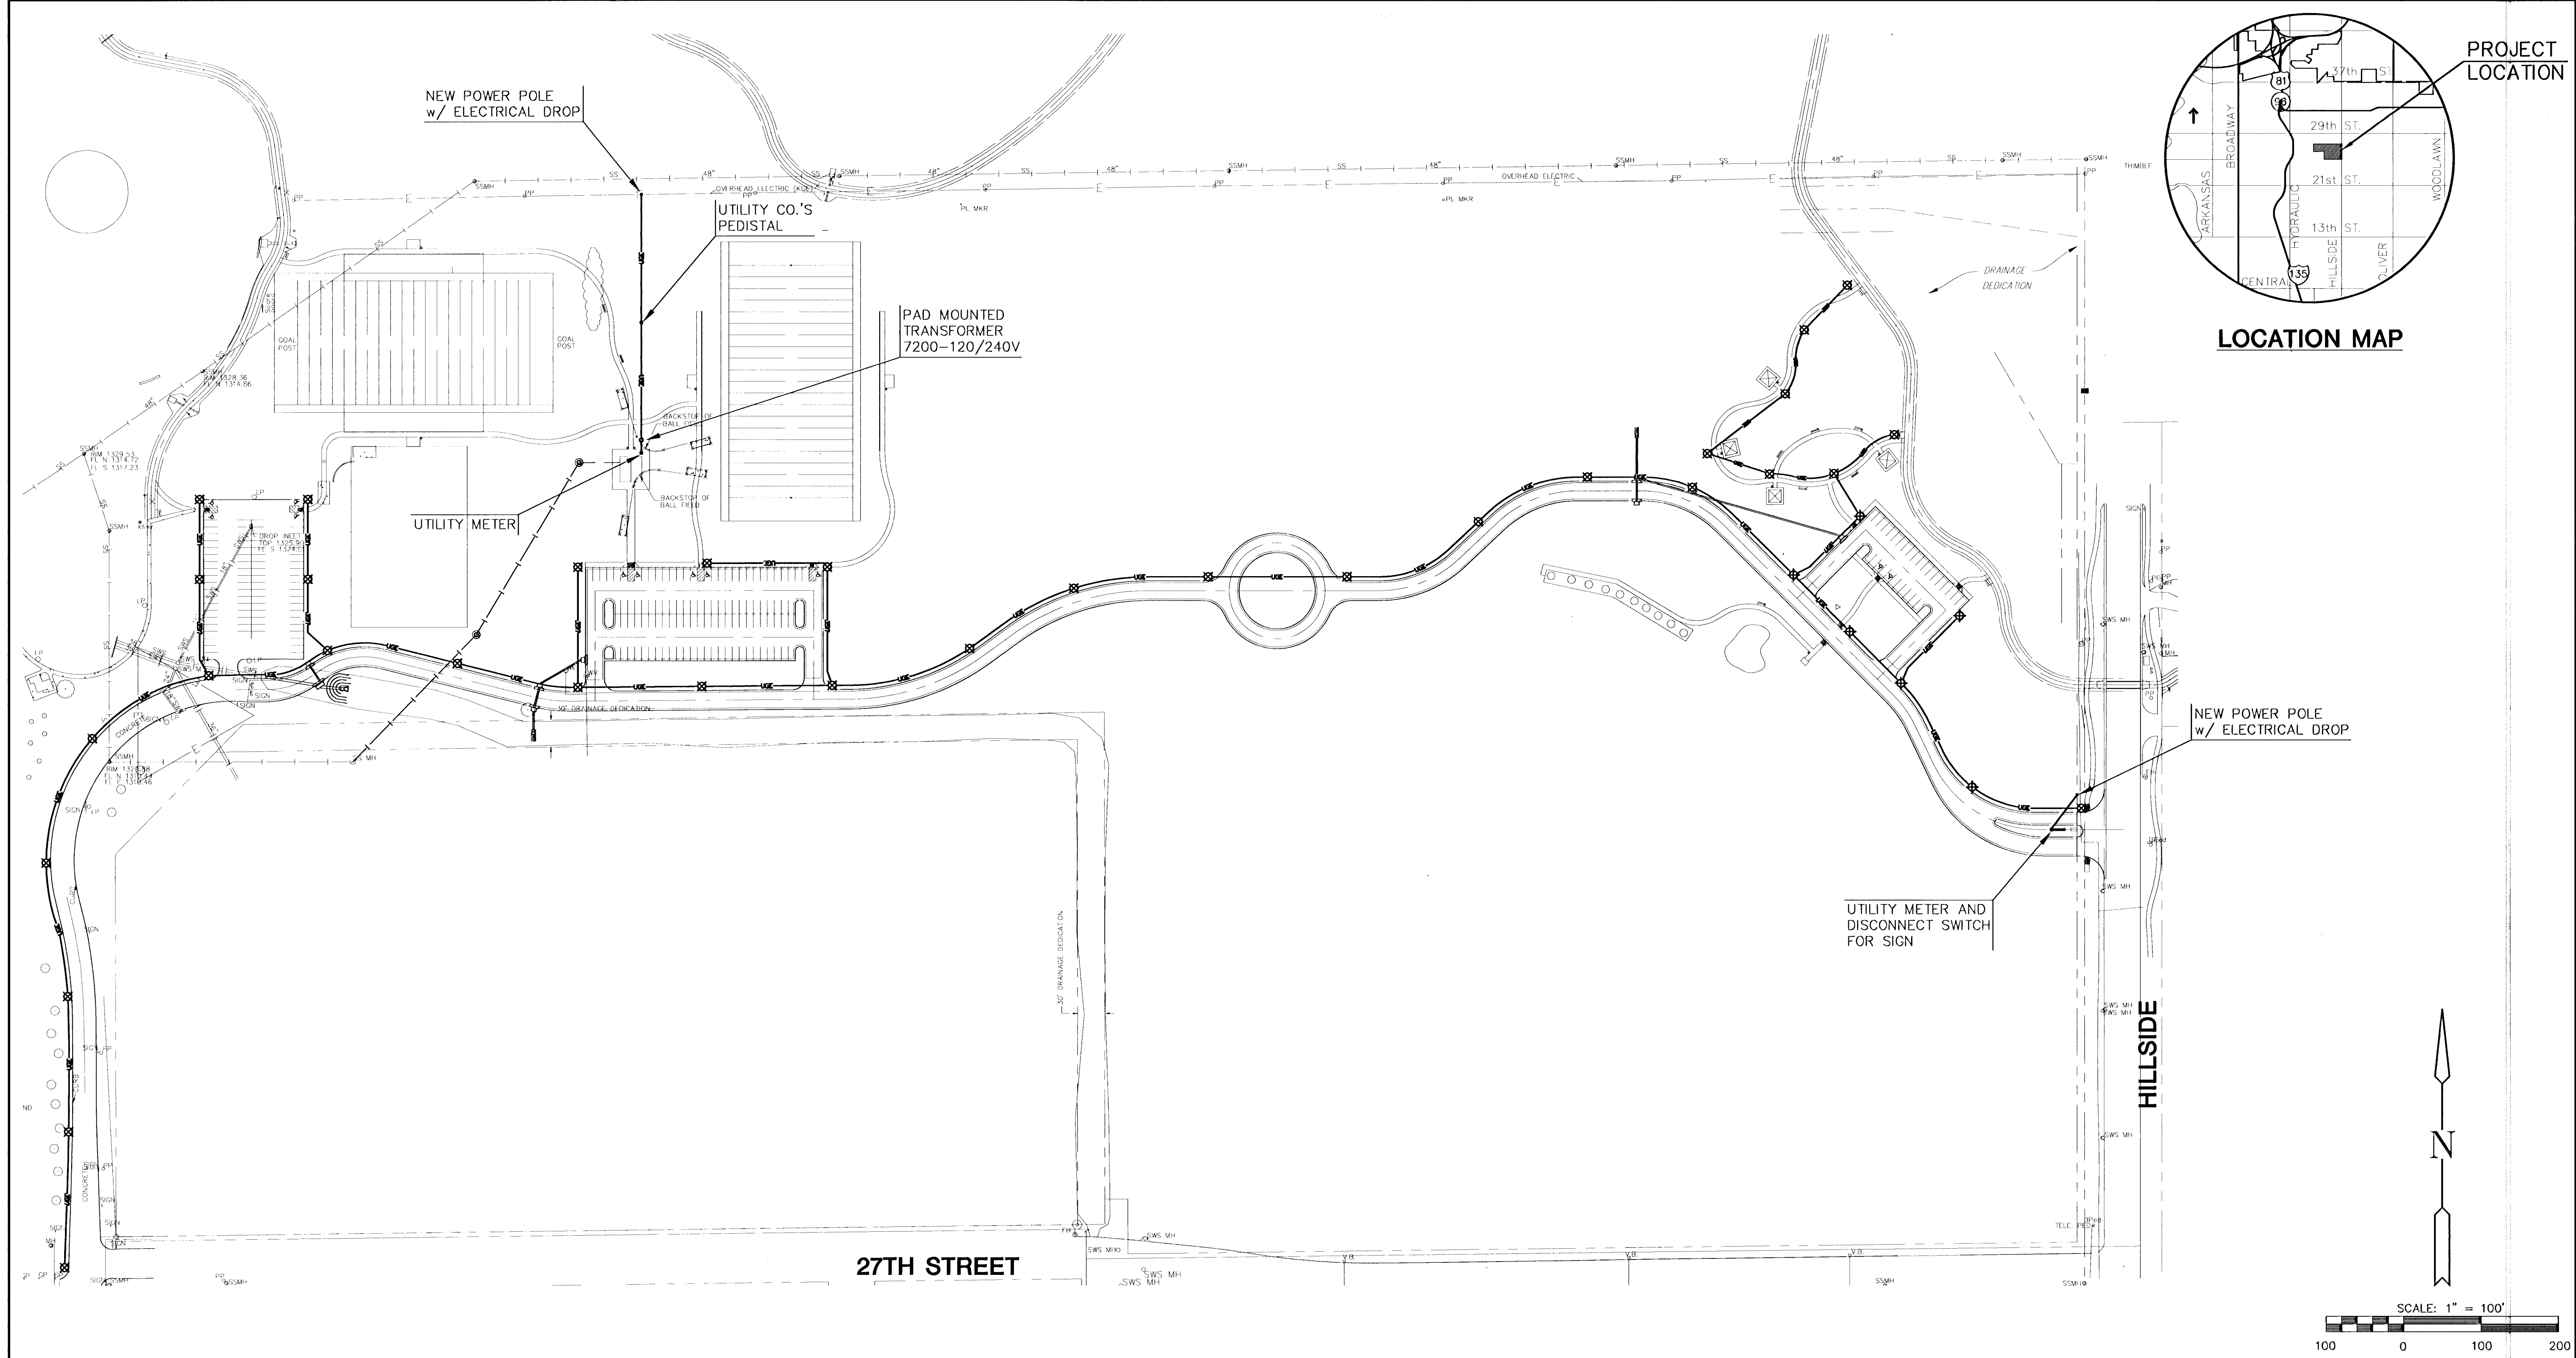

GossonLivingston
Architects
400 South Doyle
Wichita, KS 67202
316-261-5500
Fax 316-261-5506

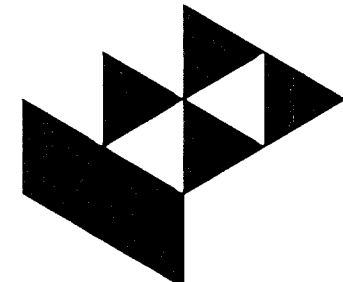

MKEC
ENGINEERING
CONSULTANTS
411 N. WEBB ROAD
WICHITA, KS. 67206
316-264-9600

GROVE PARK IMPROVEMENTS
PROJECT NAME

OVERALL ELECTRICAL LIGHTING PLAN
SHEET TITLE

JTC DESIGN BY:	GJR DRAWN BY:	JTC CHECKED BY:
OCTOBER 2001 DATE	01060ELE JOB NO.	ES 101 / 50 SHEET/OF

G:\CIVIL\01060\01060ELEC\01060ELE.DWG Plot Oct 29 16:42:07 2001