


S.V.A. DWG. NAME: 8003E003.DWG; DATE: 05/12/99; TIME: 16:11

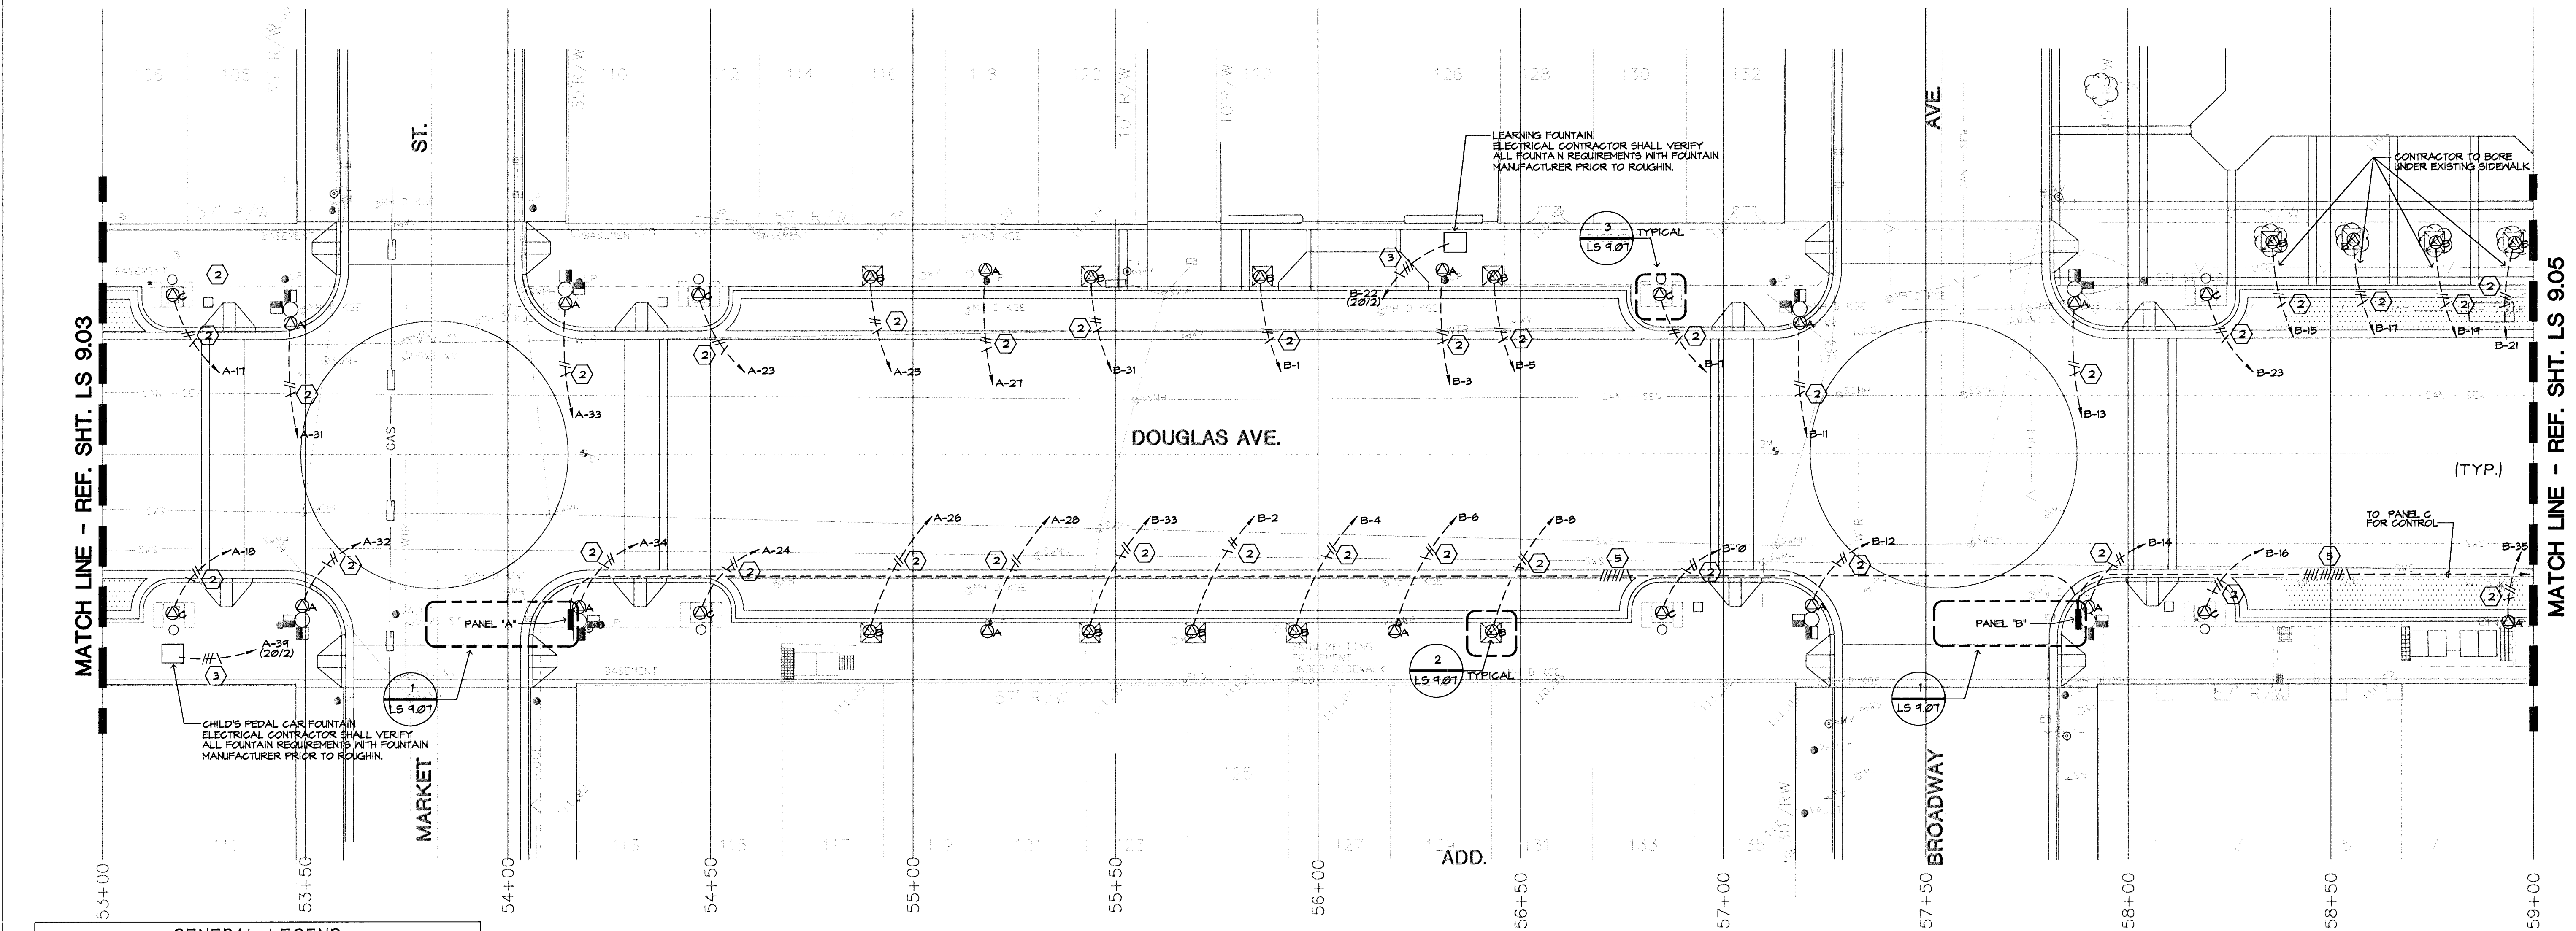

GENERAL LEGEND

— — — — — PROPERTY LINE
- - - - - CONTRACT LIMIT LINE
- - - - - CENTER LINE

WTR —
UGT —
GAS —
SWS —
UGT —
GAS —
SWS —
UGT —
GAS —
SWS —


EXISTING UTILITY LINES

— — — — — EDGE OF BASEMENT

DETAIL REFERENCE

1 — — — — — DETAIL NO.
LS 9.07 — — — — — SHEET NO.


EXISTING VAULTS

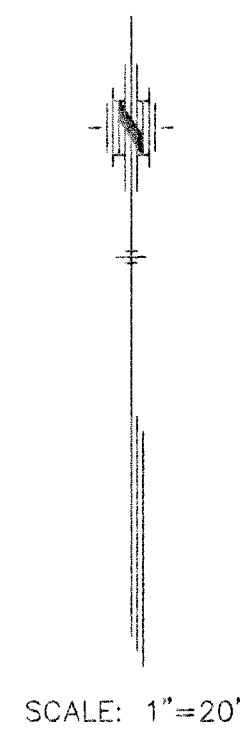

PARTIAL DOUGLAS AVE. POWER PLAN

NOTES:

1. BRANCH CIRCUITS ARE INDICATED AS ONE CIRCUIT HOME RUNS FOR CLARITY ONLY. CONTRACTOR MAY GROUP SINGLE POLE BRANCH CIRCUITS IN MULTIPLE CIRCUIT HOME RUNS (3 CIRCUIT MAXIMUM). A GROUND CONDUCTOR SIZED PER N.E.C. ARTICLE 250 IS REQUIRED IN ALL POWER, RECEPTACLE, AND LIGHTING CIRCUITS.

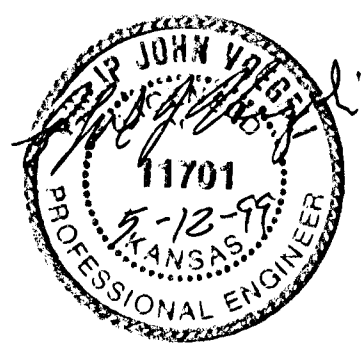

STREETSCAPES
PROJECT NAME

DOUGLAS AVE. @ 53+00 TO 59+00
SHEET TITLE

MID-KANSAS ENGINEERING CONSULTANTS, INC.
411 N. WEBB ROAD
WICHITA, KS. 67206
316-684-9600

SVA DESIGN BY: MAY 1998 DATE	SVA DRAWN BY: 92010 JOB NO.	SVA CHECKED BY: LS 9.04 SHEET OF
---------------------------------------	--------------------------------------	---