



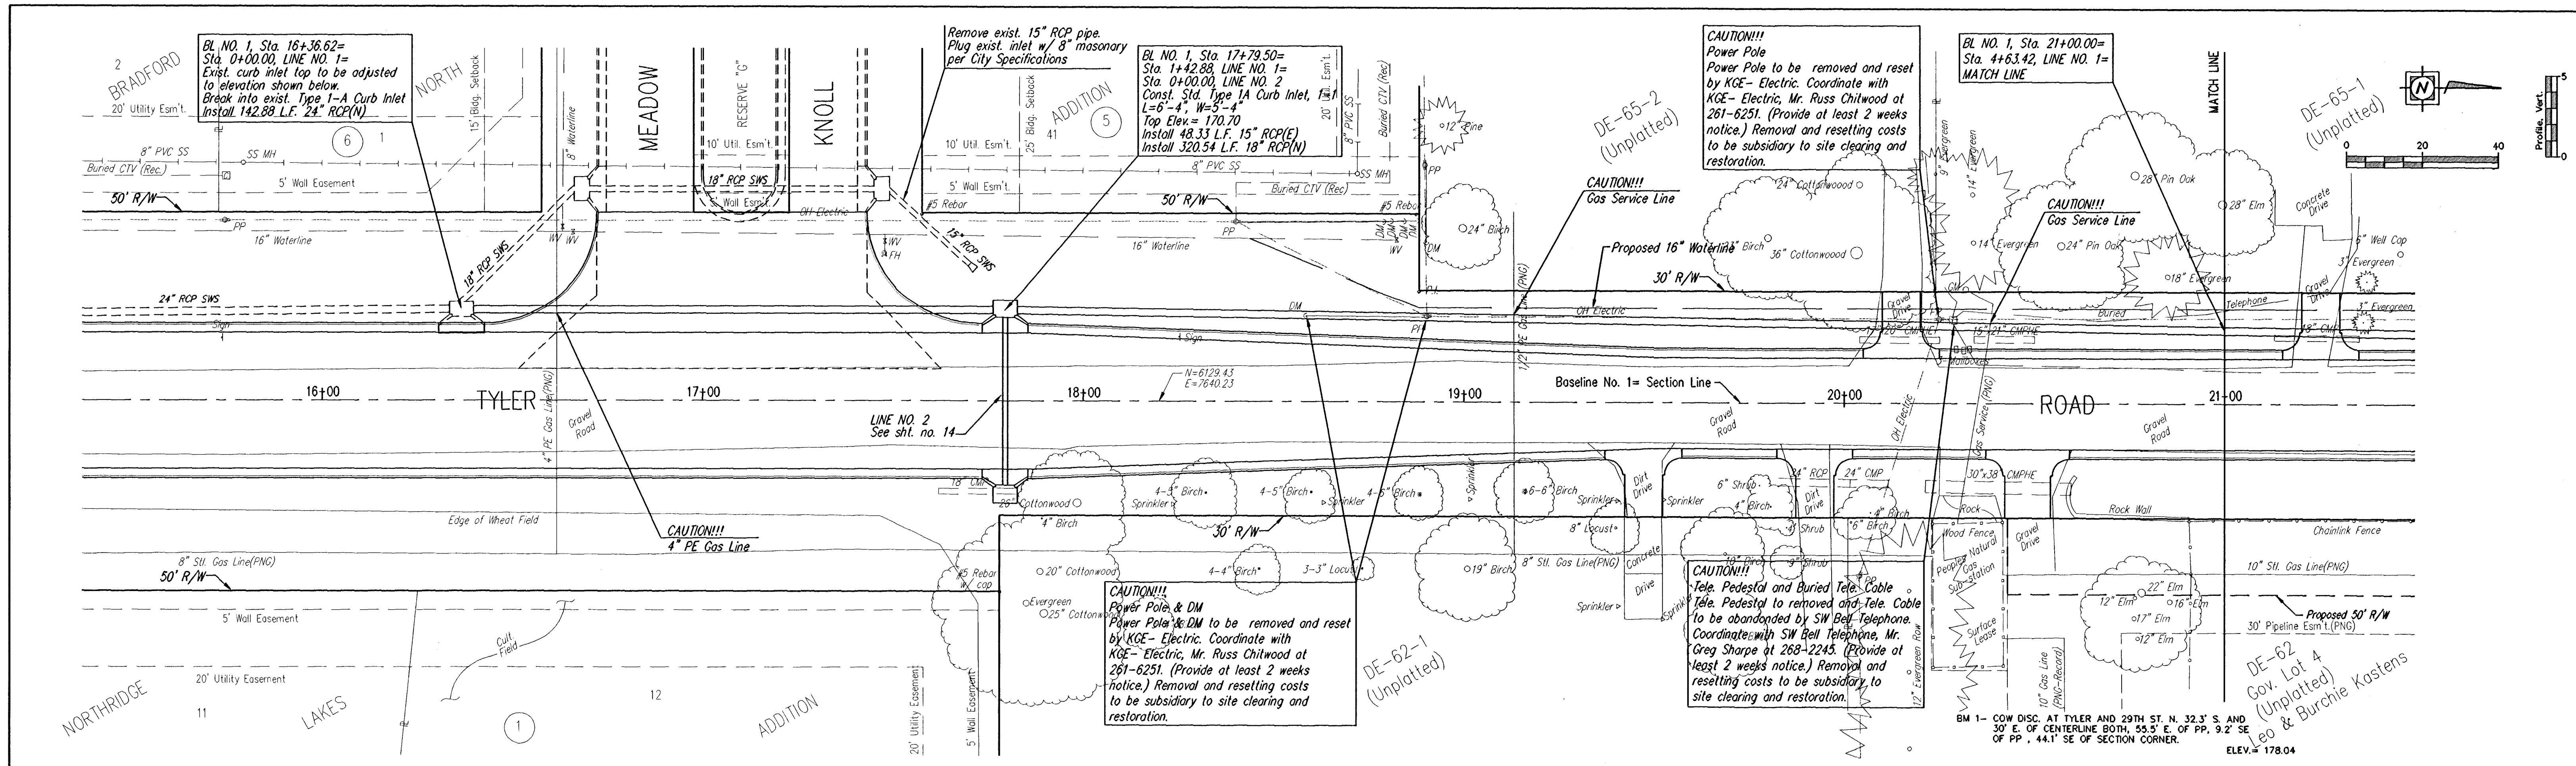

STORM SEWER LINE NO. 1

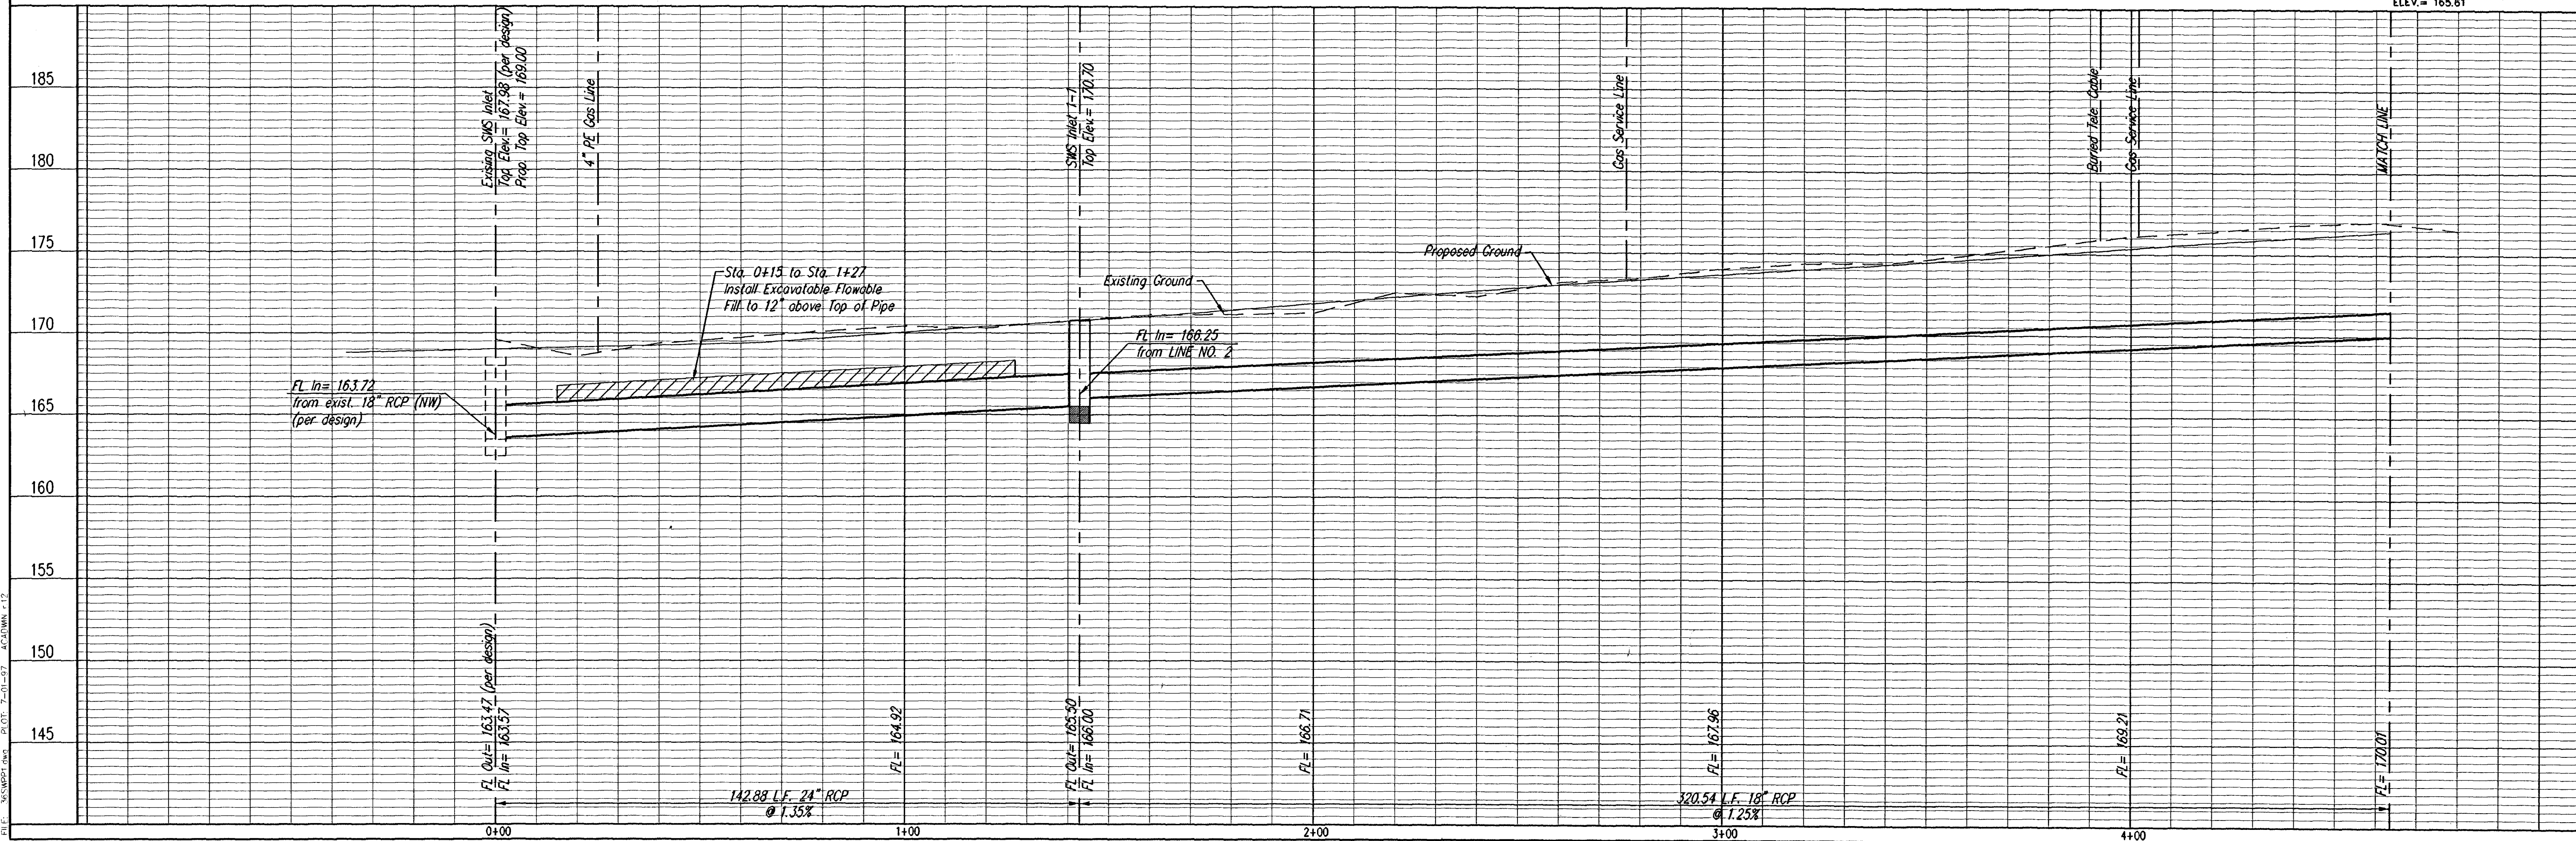

City of Wichita
Sedgwick County, Kansas

STORM SEWER LINE NO. 1
(SWS Sta. 0+00.00 to SWS Sta. 4+63.42)
Plan and Profile

Tyler Road from 29th Street North to 1/4 mile South
Street and Storm Drainage Improvements

103 South Osage, Suite 200
Dodge City, KS 67801
Tel: (316) 788-2552
Fax: (316) 788-4462

YOUNG & ASSOCIATES, P.A.
Civil and Environmental Engineers

Project No.: 96-036-002
Date: February 1997

Engr.: C.R. Young
Tech.: J.L. Murphy

Sheet No. 12 of 27