


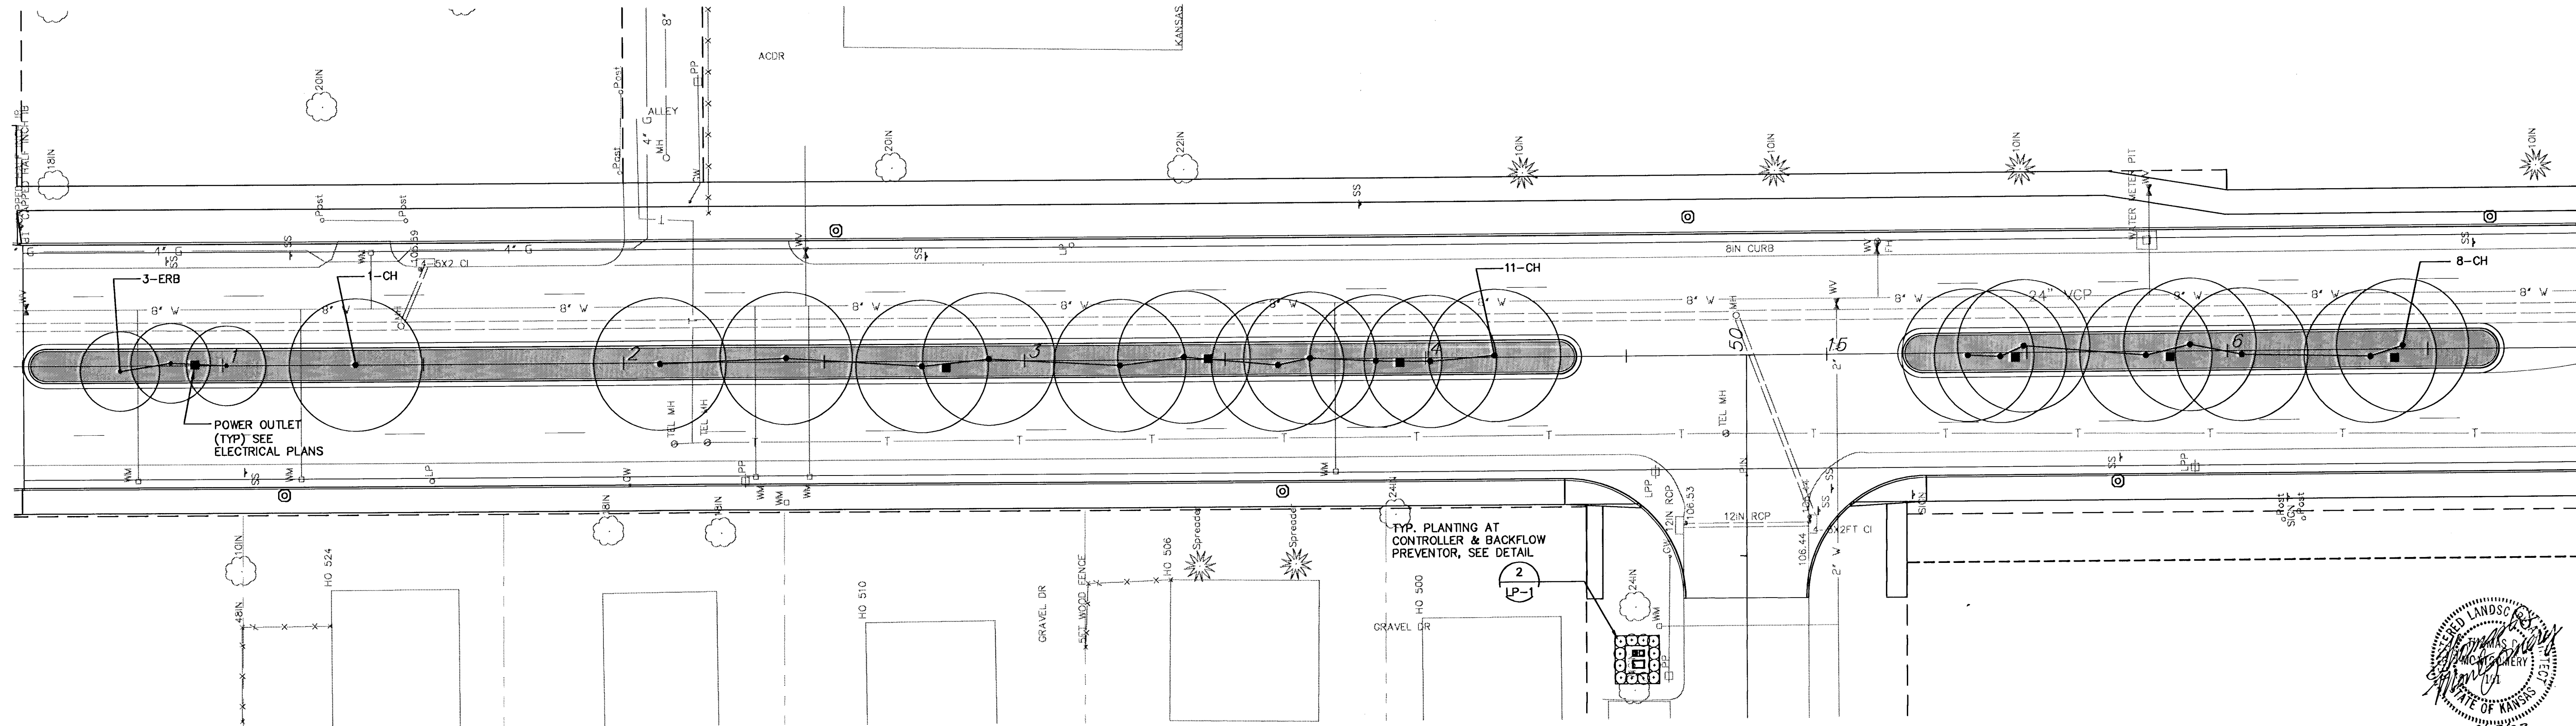

LANDSCAPE PLAN NO. 1 0' 10' 20' 40' 1"=20.0'

PLANT LIST

KEY	QTY.	COMMON NAME	BOTANICAL NAME	SIZE	CONDITION
DECIDUOUS TREES					
CH	45	COMMON HACKBERRY	Celtis occidentalis	4" cal.	Balled-in-Burlap
ERB	70	EASTERN REDBUD	Cercis canadensis	4" cal.	Balled-in-Burlap
SODDING					
	2750 S.Y.	TURF-TYPE FESCUE BLEND	Festuca		

LEGEND

AREAS TO BE SODDED WITH A TURF-TYPE FESCUE BLEND



NEW TREES

POWER OUTLET SEE ELECTRICAL PLANS

GENERAL NOTES:


- SEE SHEET LP101 FOR DECIDUOUS TREE PLANTING DETAIL AND PLANT LIST.
- REFERENCE THE CITY OF WICHITA STANDARD SPECIFICATIONS FOR LANDSCAPE AND IRRIGATION REQUIREMENTS.
- REMOVE EXISTING SOIL IN MEDIANS TO A DEPTH OF 18" AND REPLACE WITH TOPSOIL. TOPSOIL SHALL BE APPROVED BY OWNER'S REPRESENTATIVE.

KEYMAP

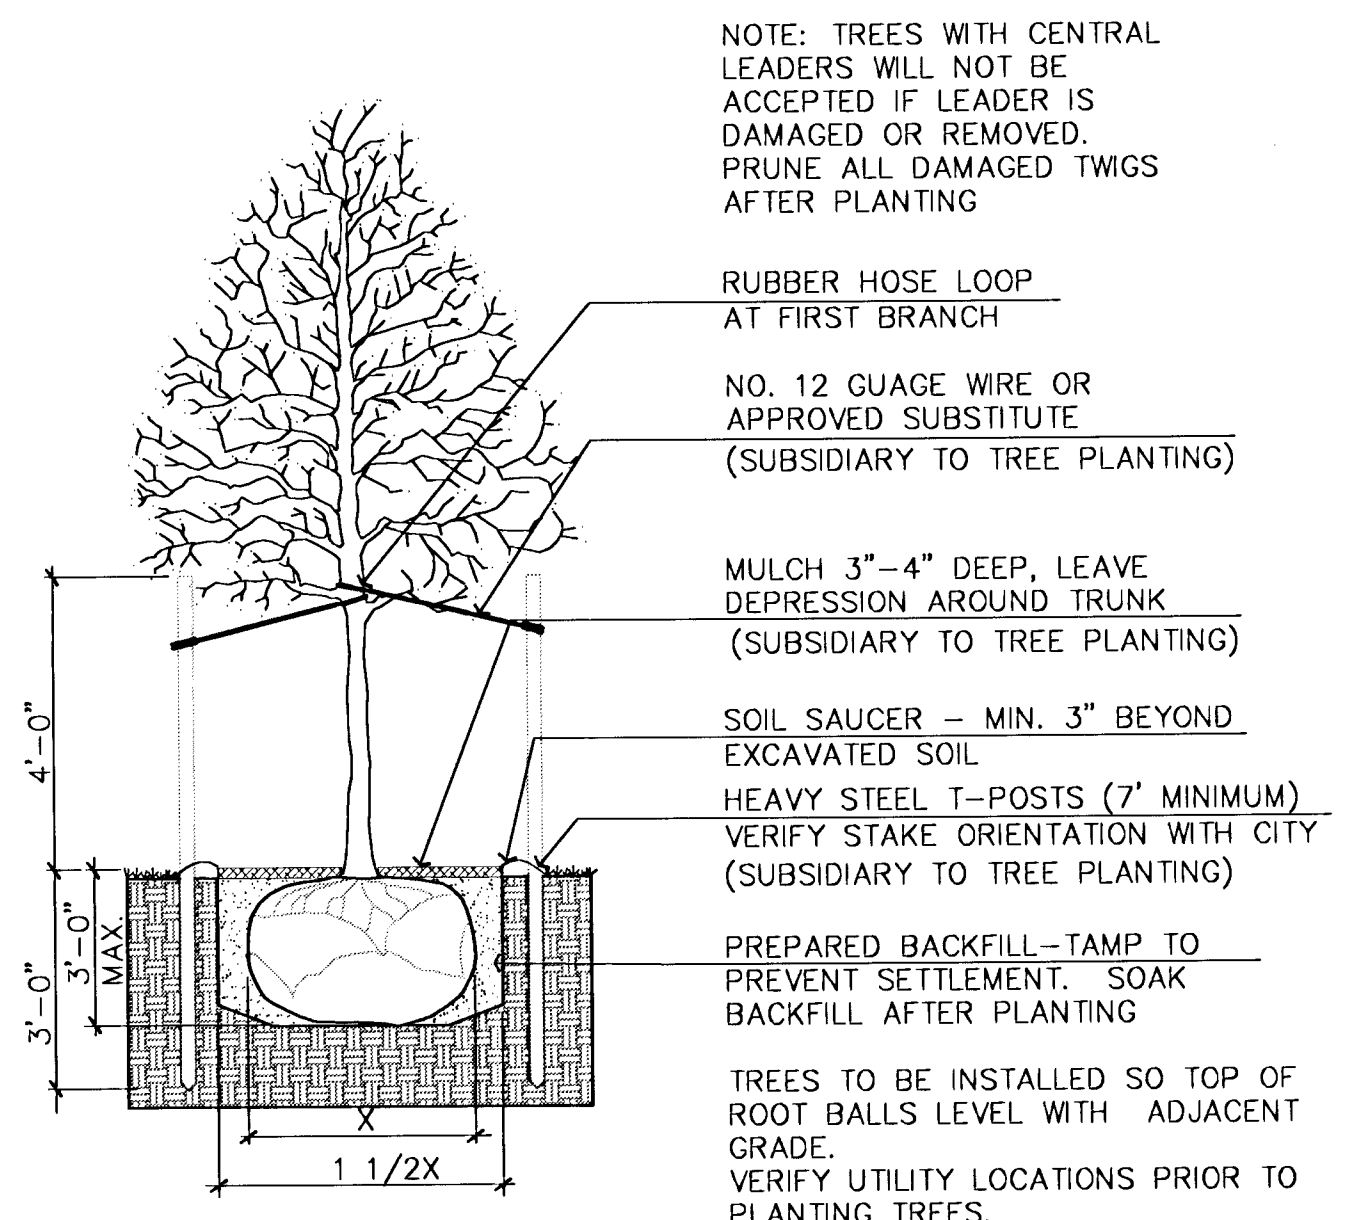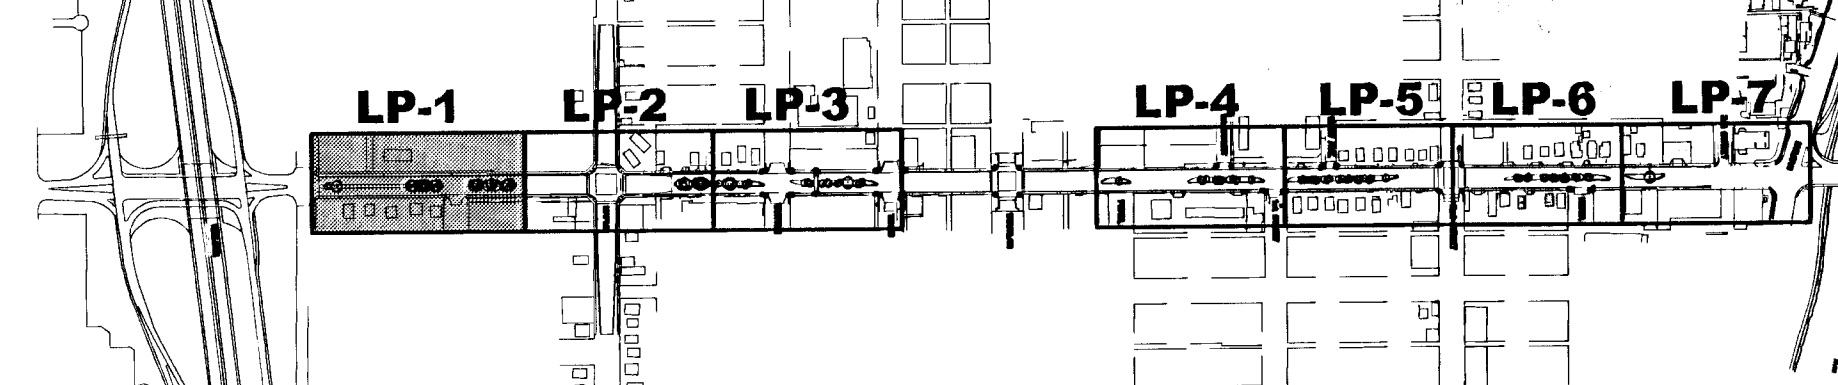


1 DECIDUOUS TREE PLANTING DETAIL

LP-1 NOT TO SCALE

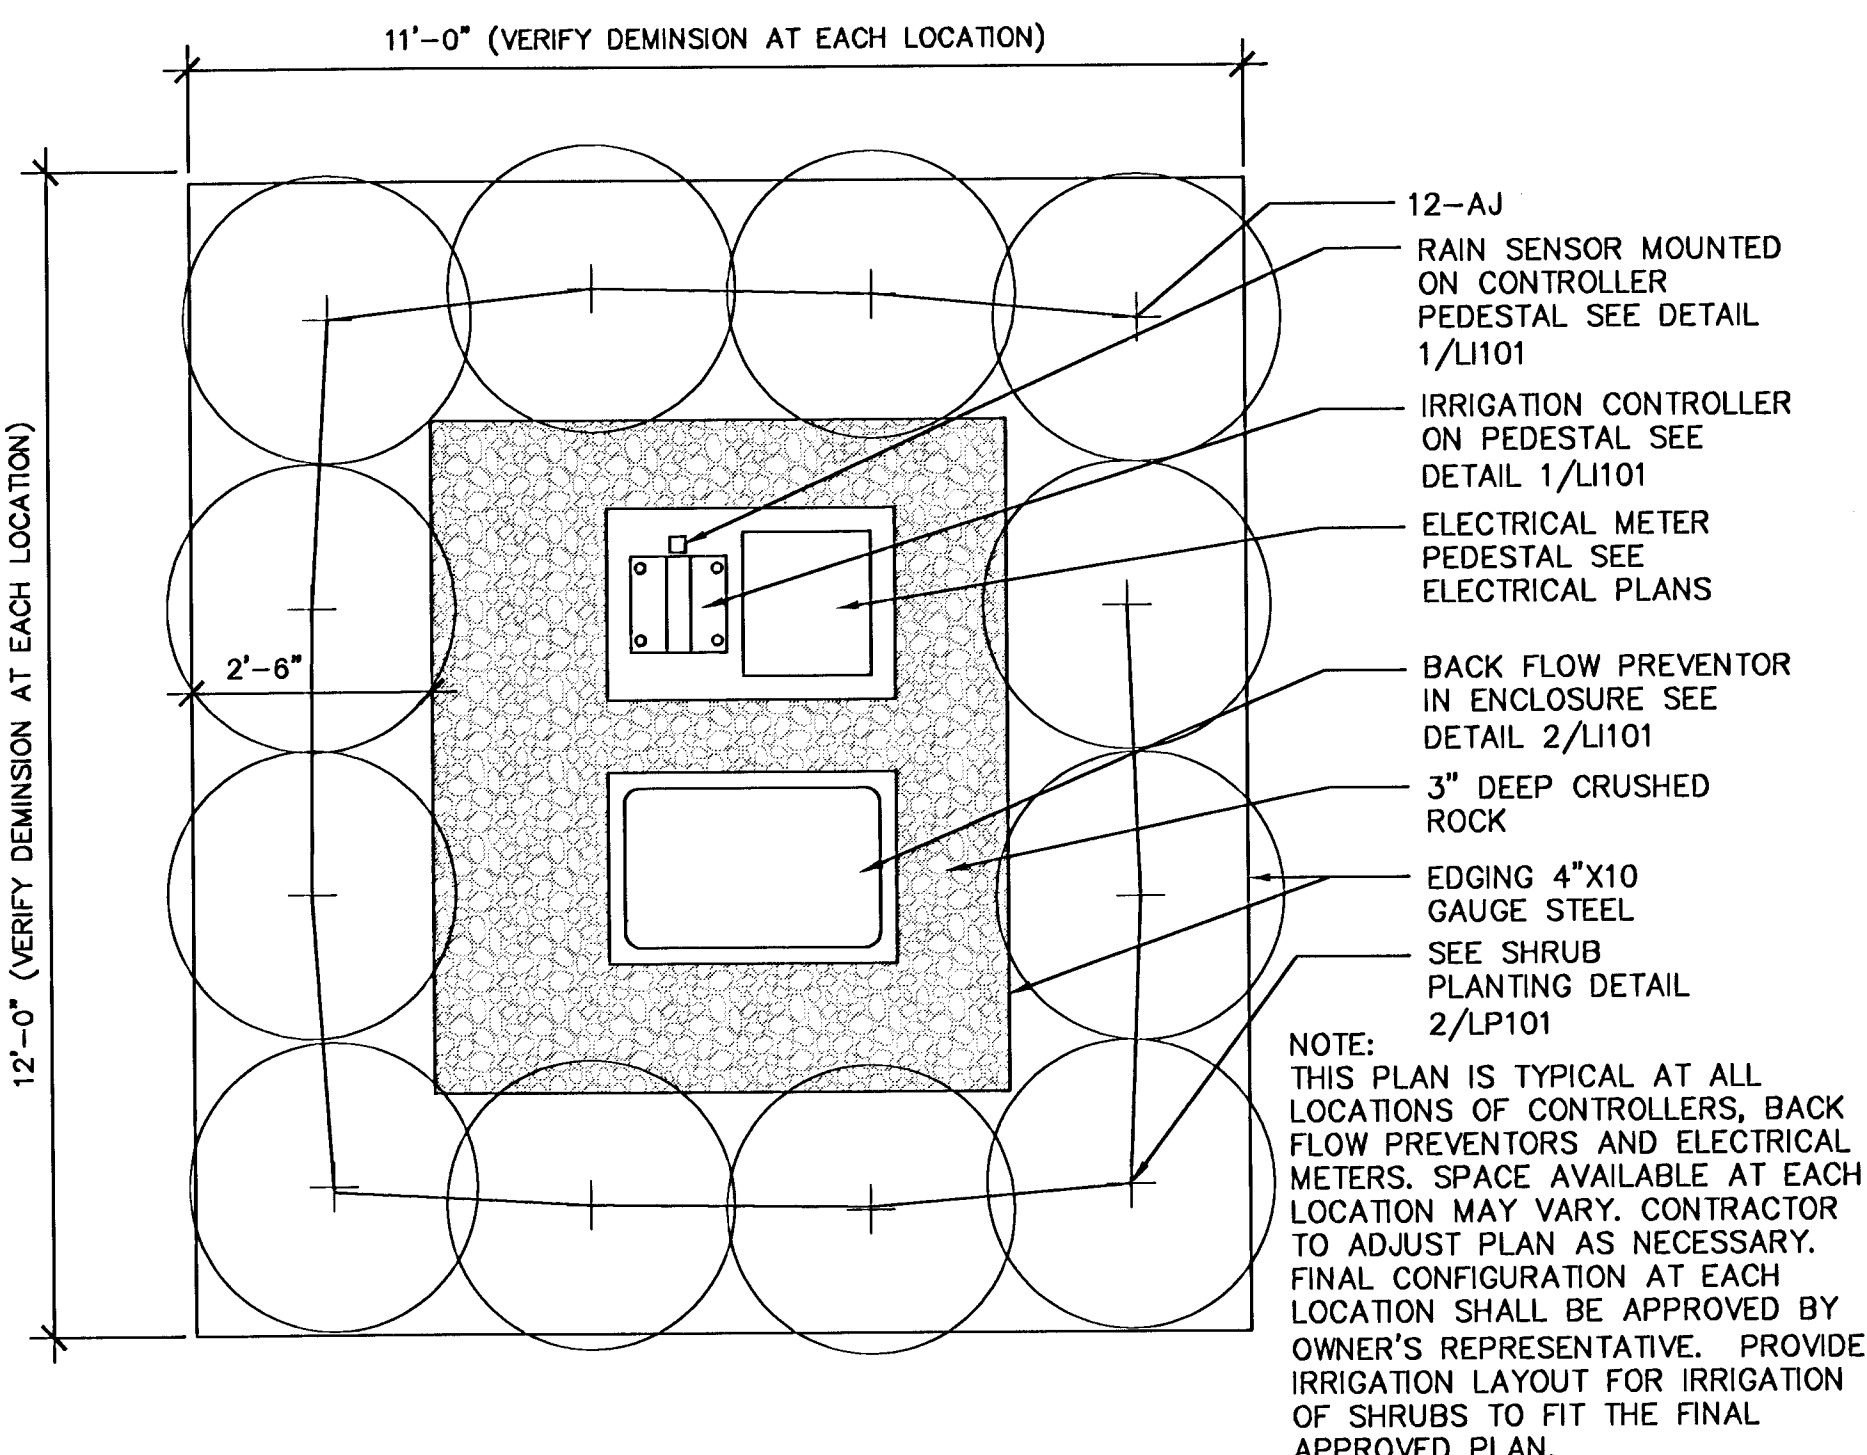

2 TYP. PLANTING AT CONTROLLER & BACKFLOW PREVENTOR

LP-1 NOT TO SCALE

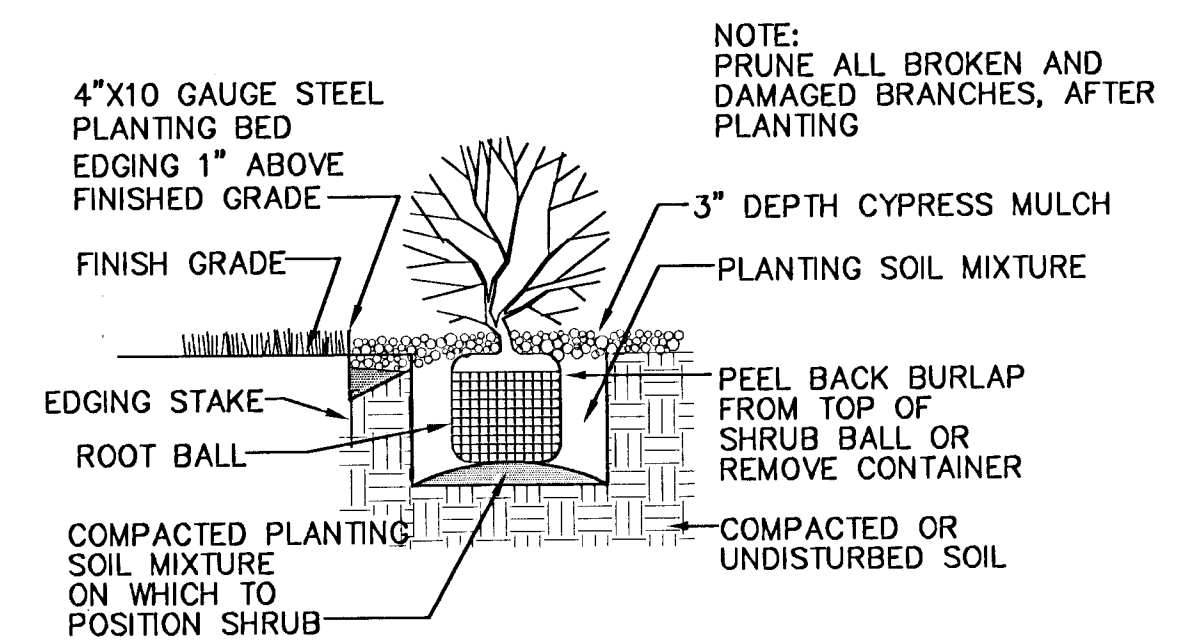

3 SHRUB PLANTING DETAIL

LP-1 NOT TO SCALE

MKEC
ENGINEERING CONSULTANTS
411 N. WEBB ROAD
WICHITA, KS. 67206
316-684-9600

SENECA STREET
PROJECT NAME

LANDSCAPE PLAN NO. 1
SHEET TITLE

DESIGN BY: TDM
DATE: 02/03/03

DRAWN BY: LES
DRAWING NAME: LP101

CHECKED BY: TDM
SHEET OF: LP1 7