


A LANDSCAPE PLAN NO. 3

LEGEND

- AREAS TO BE SODDED WITH A TURF-TYPE FESCUE BLEND
- NEW TREES
- POWER OUTLET SEE ELECTRICAL PLANS

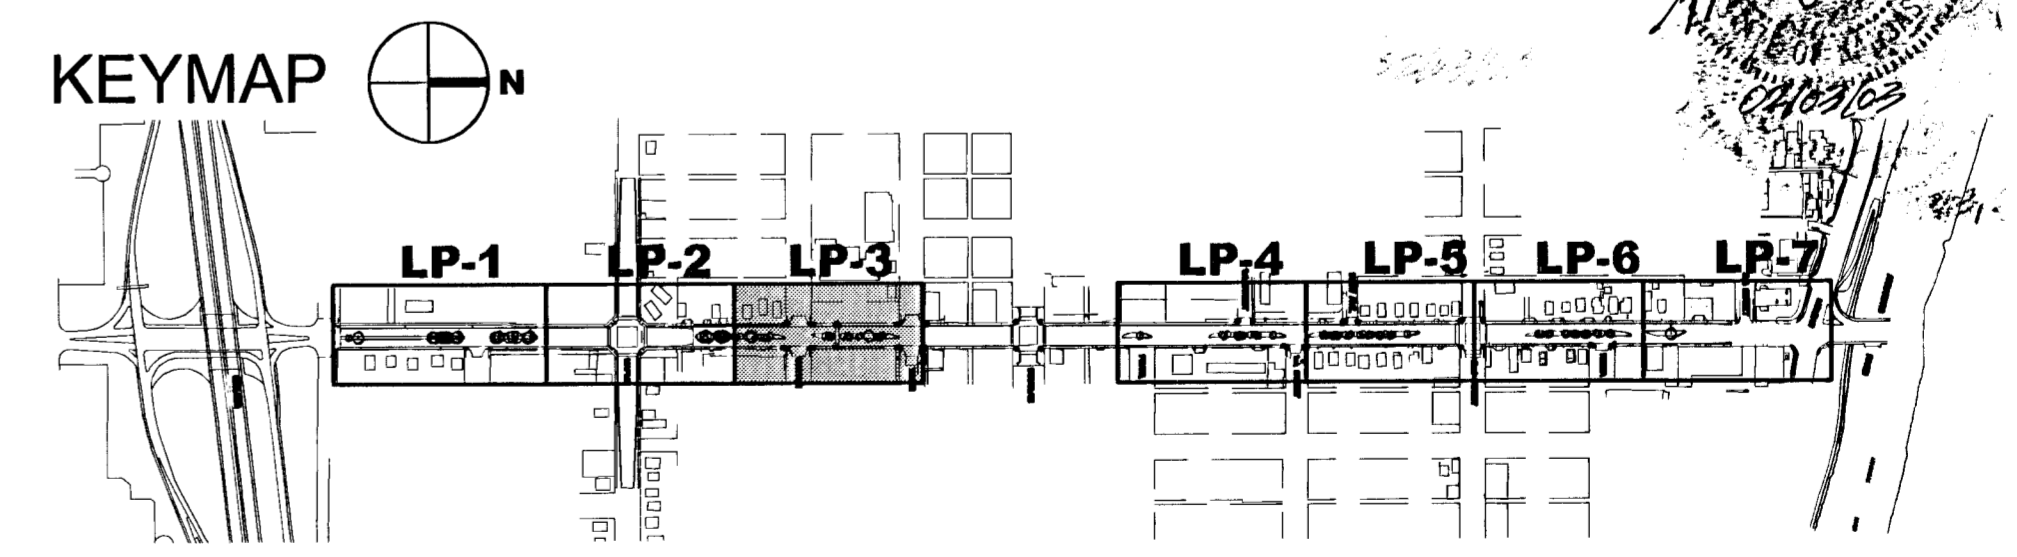

- GENERAL NOTES:**
- SEE SHEET LP101 FOR DECIDUOUS TREE PLANTING DETAIL AND PLANT LIST.
 - REFERENCE THE CITY OF WICHITA STANDARD SPECIFICATIONS FOR LANDSCAPE AND IRRIGATION REQUIREMENTS.
 - REMOVE EXISTING SOIL IN MEDIANS TO A DEPTH OF 18" AND REPLACE WITH TOPSOIL. TOPSOIL SHALL BE APPROVED BY OWNER'S REPRESENTATIVE.

SENECA STREET
PROJECT NAME

LANDSCAPE PLAN NO. 3
SHEET TITLE

MKEC
ENGINEERING CONSULTANTS
411 N. WEBB ROAD
WICHITA, KS. 67206
316-684-9600

LES
DESIGN BY:
02/03/03
DATE

TDM
DRAWN BY:
LP103
DRAWING NAME

TDM
CHECKED BY:
LP3 7
SHEET / OF