


A LANDSCAPE PLAN NO. 5

LEGEND

- AREAS TO BE SODDED WITH A TURF-TYPE FESCUE BLEND
- NEW TREES
- POWER OUTLET SEE ELECTRICAL PLANS

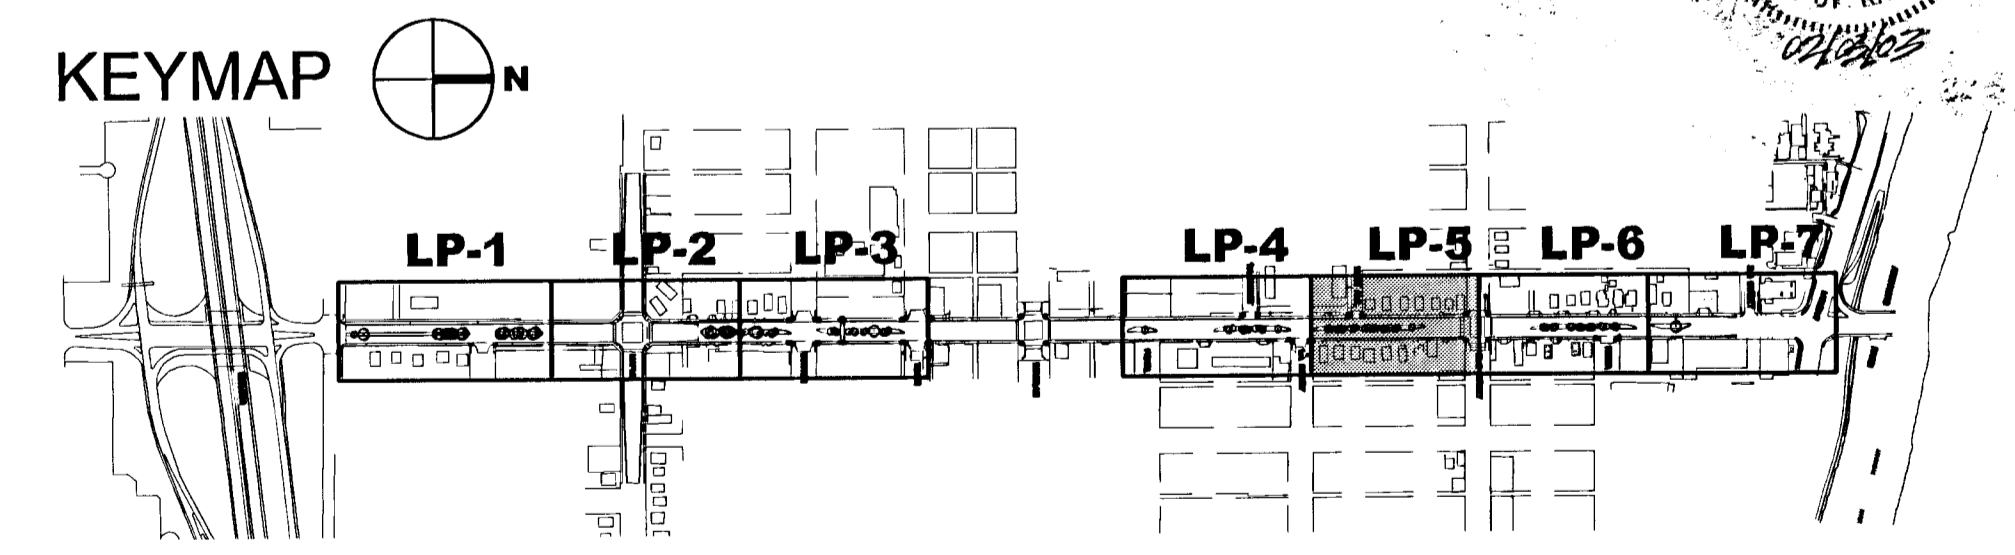

- GENERAL NOTES:**
- SEE SHEET LP101 FOR DECIDUOUS TREE PLANTING DETAIL AND PLANT LIST.
 - REFERENCE THE CITY OF WICHITA STANDARD SPECIFICATIONS FOR LANDSCAPE AND IRRIGATION REQUIREMENTS.
 - REMOVE EXISTING SOIL IN MEDIANS TO A DEPTH OF 18" AND REPLACE WITH TOPSOIL. TOPSOIL SHALL BE APPROVED BY OWNER'S REPRESENTATIVE.

SENECA STREET
PROJECT NAME

LANDSCAPE PLAN NO.5
SHEET TITLE

TDM DESIGN BY: **LES** DRAWN BY: **TDM** CHECKED BY:

411 N. WEBB ROAD
WICHITA, KS. 67208
316-684-9600

02/03/03 DATE: **LP105** DRAWING NAME: **LP5 7** SHEET / OF