


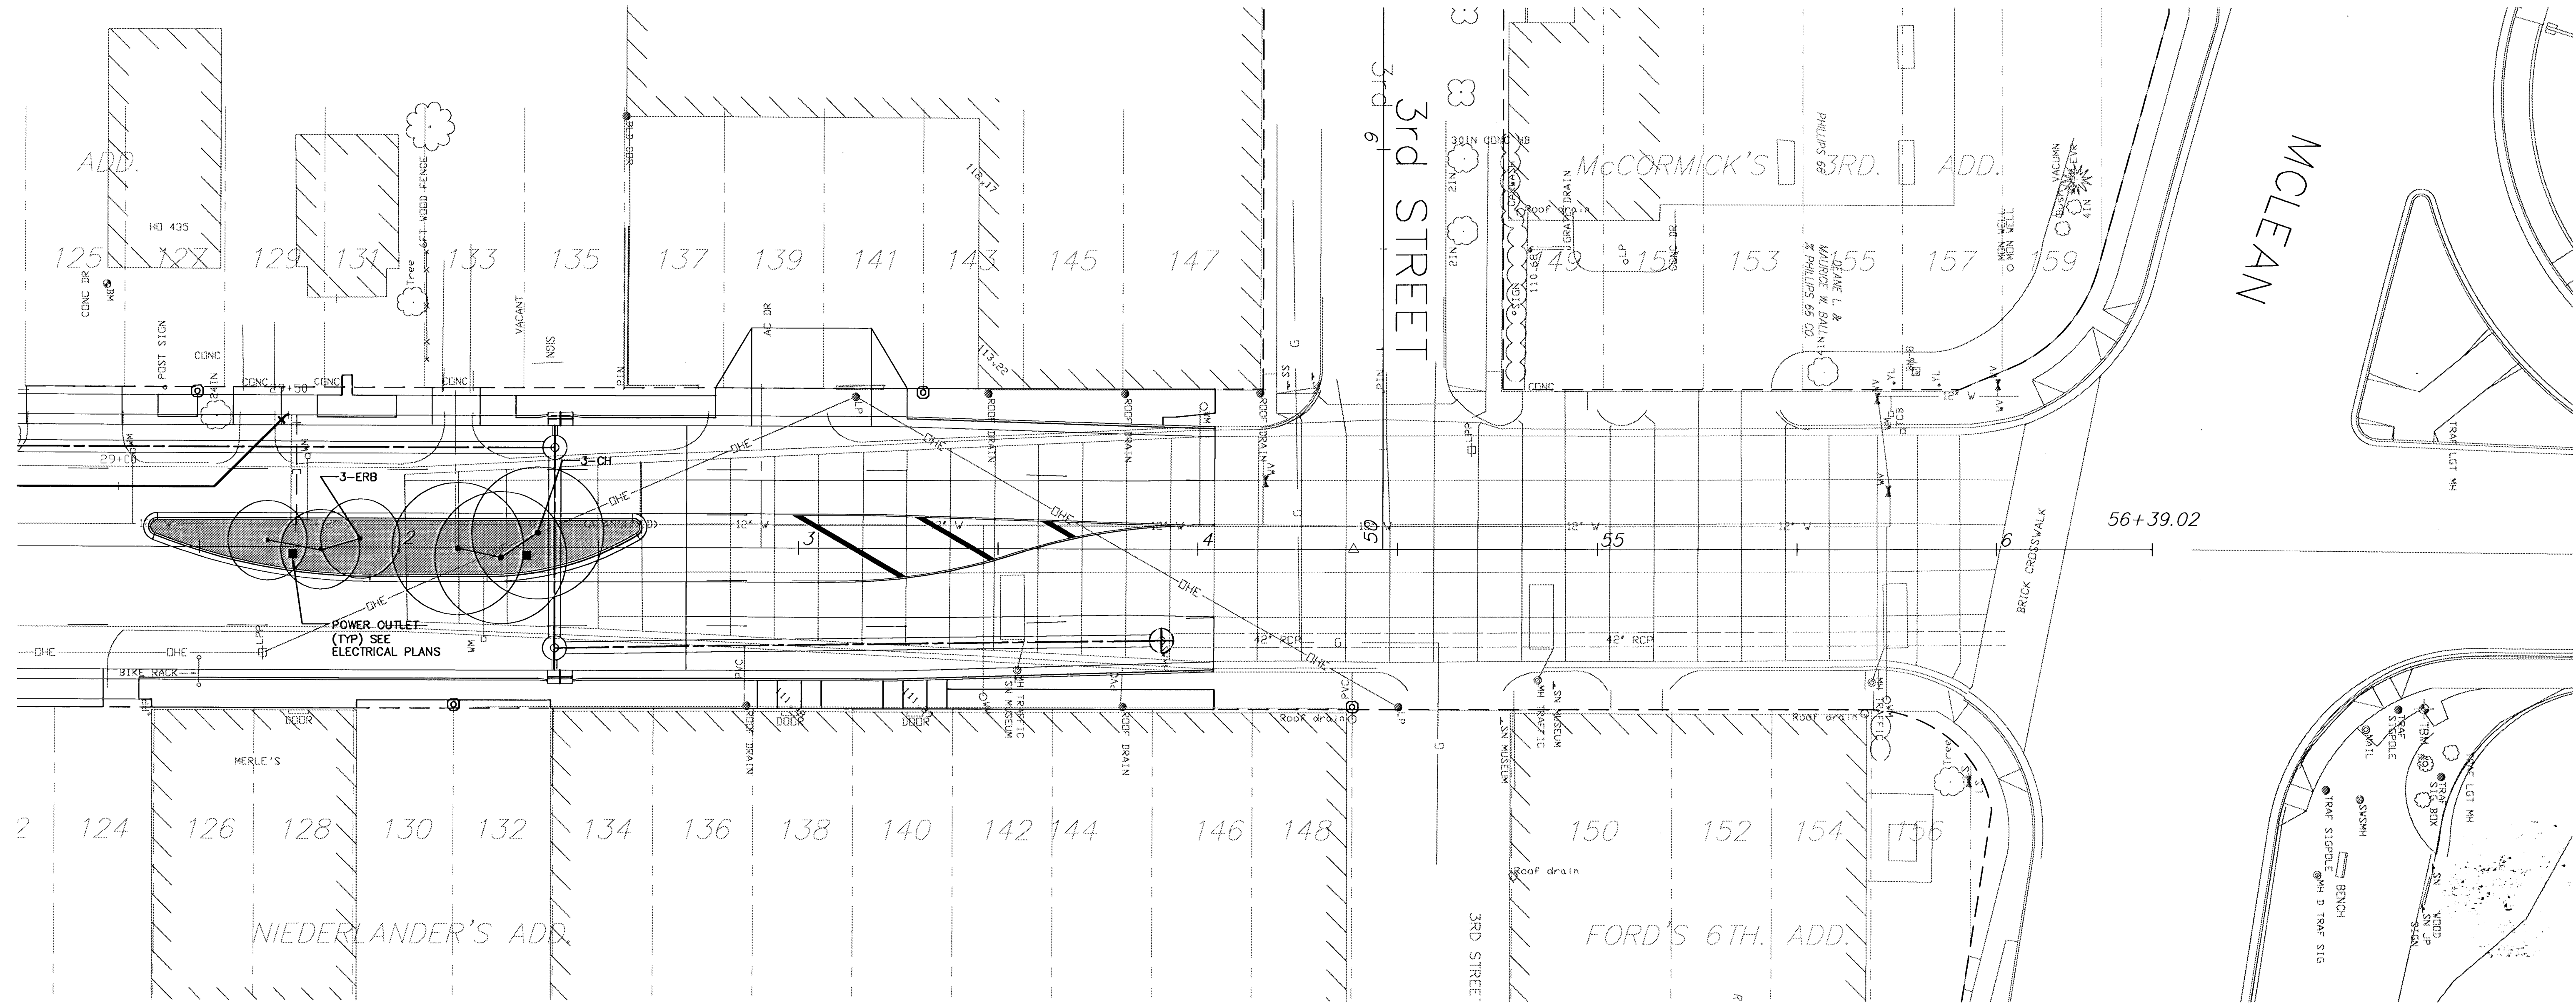

A LANDSCAPE PLAN NO. 7

0' 10' 20' 40' 1"=20.0'

N


LEGEND

- AREAS TO BE SODDED WITH A TURF-TYPE FESCUE BLEND
- NEW TREES
- POWER OUTLET SEE ELECTRICAL PLANS

GENERAL NOTES:

- SEE SHEET LP101 FOR DECIDUOUS TREE PLANTING DETAIL AND PLANT LIST.
- REFERENCE THE CITY OF WICHITA STANDARD SPECIFICATIONS FOR LANDSCAPE AND IRRIGATION REQUIREMENTS.
- REMOVE EXISTING SOIL IN MEDIANS TO A DEPTH OF 18" AND REPLACE WITH TOPSOIL. TOPSOIL SHALL BE APPROVED BY OWNER'S REPRESENTATIVE.

KEYMAP

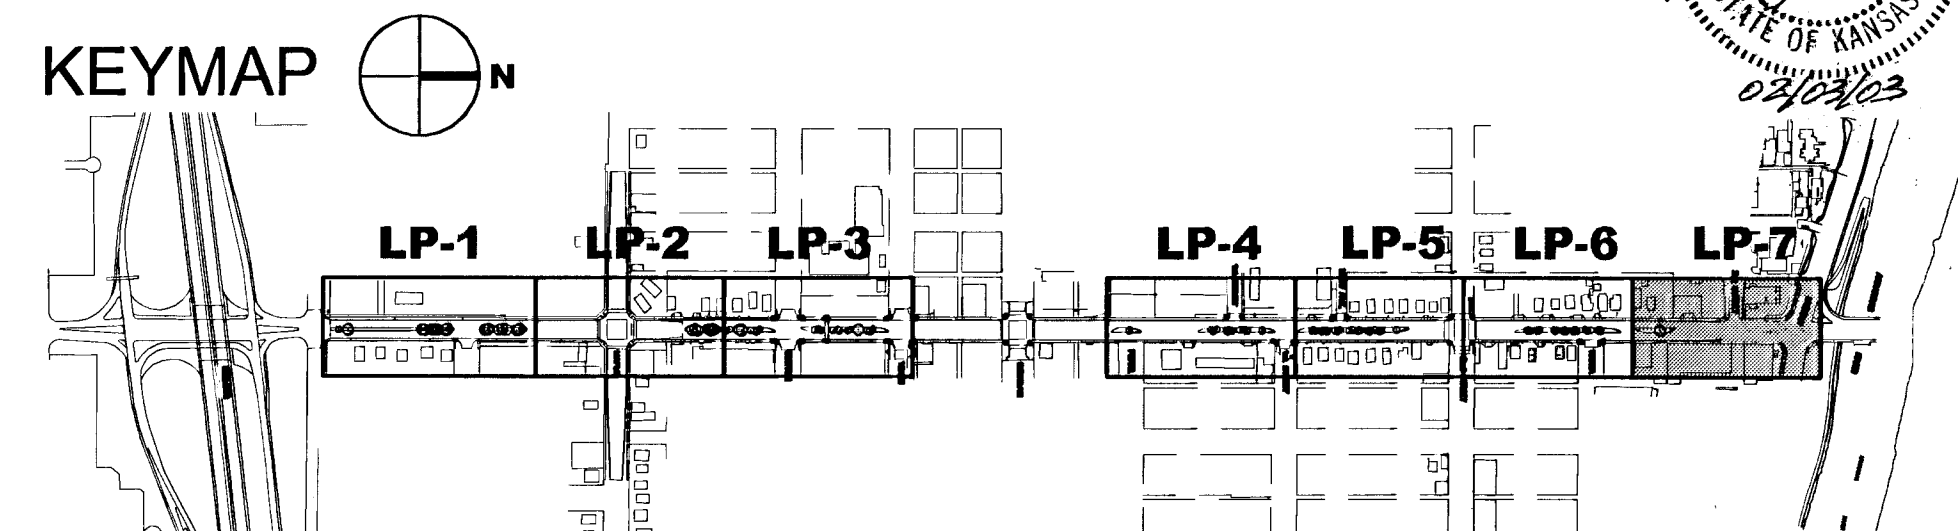

SENECA STREET
PROJECT NAME

LANDSCAPE PLAN NO. 7
SHEET TITLE

TDM DESIGN BY:	LES DRAWN BY:	TDM CHECKED BY:
02/03/03 DATE	LP107 DRAWING NAME	LP7 7 SHEET / OF