


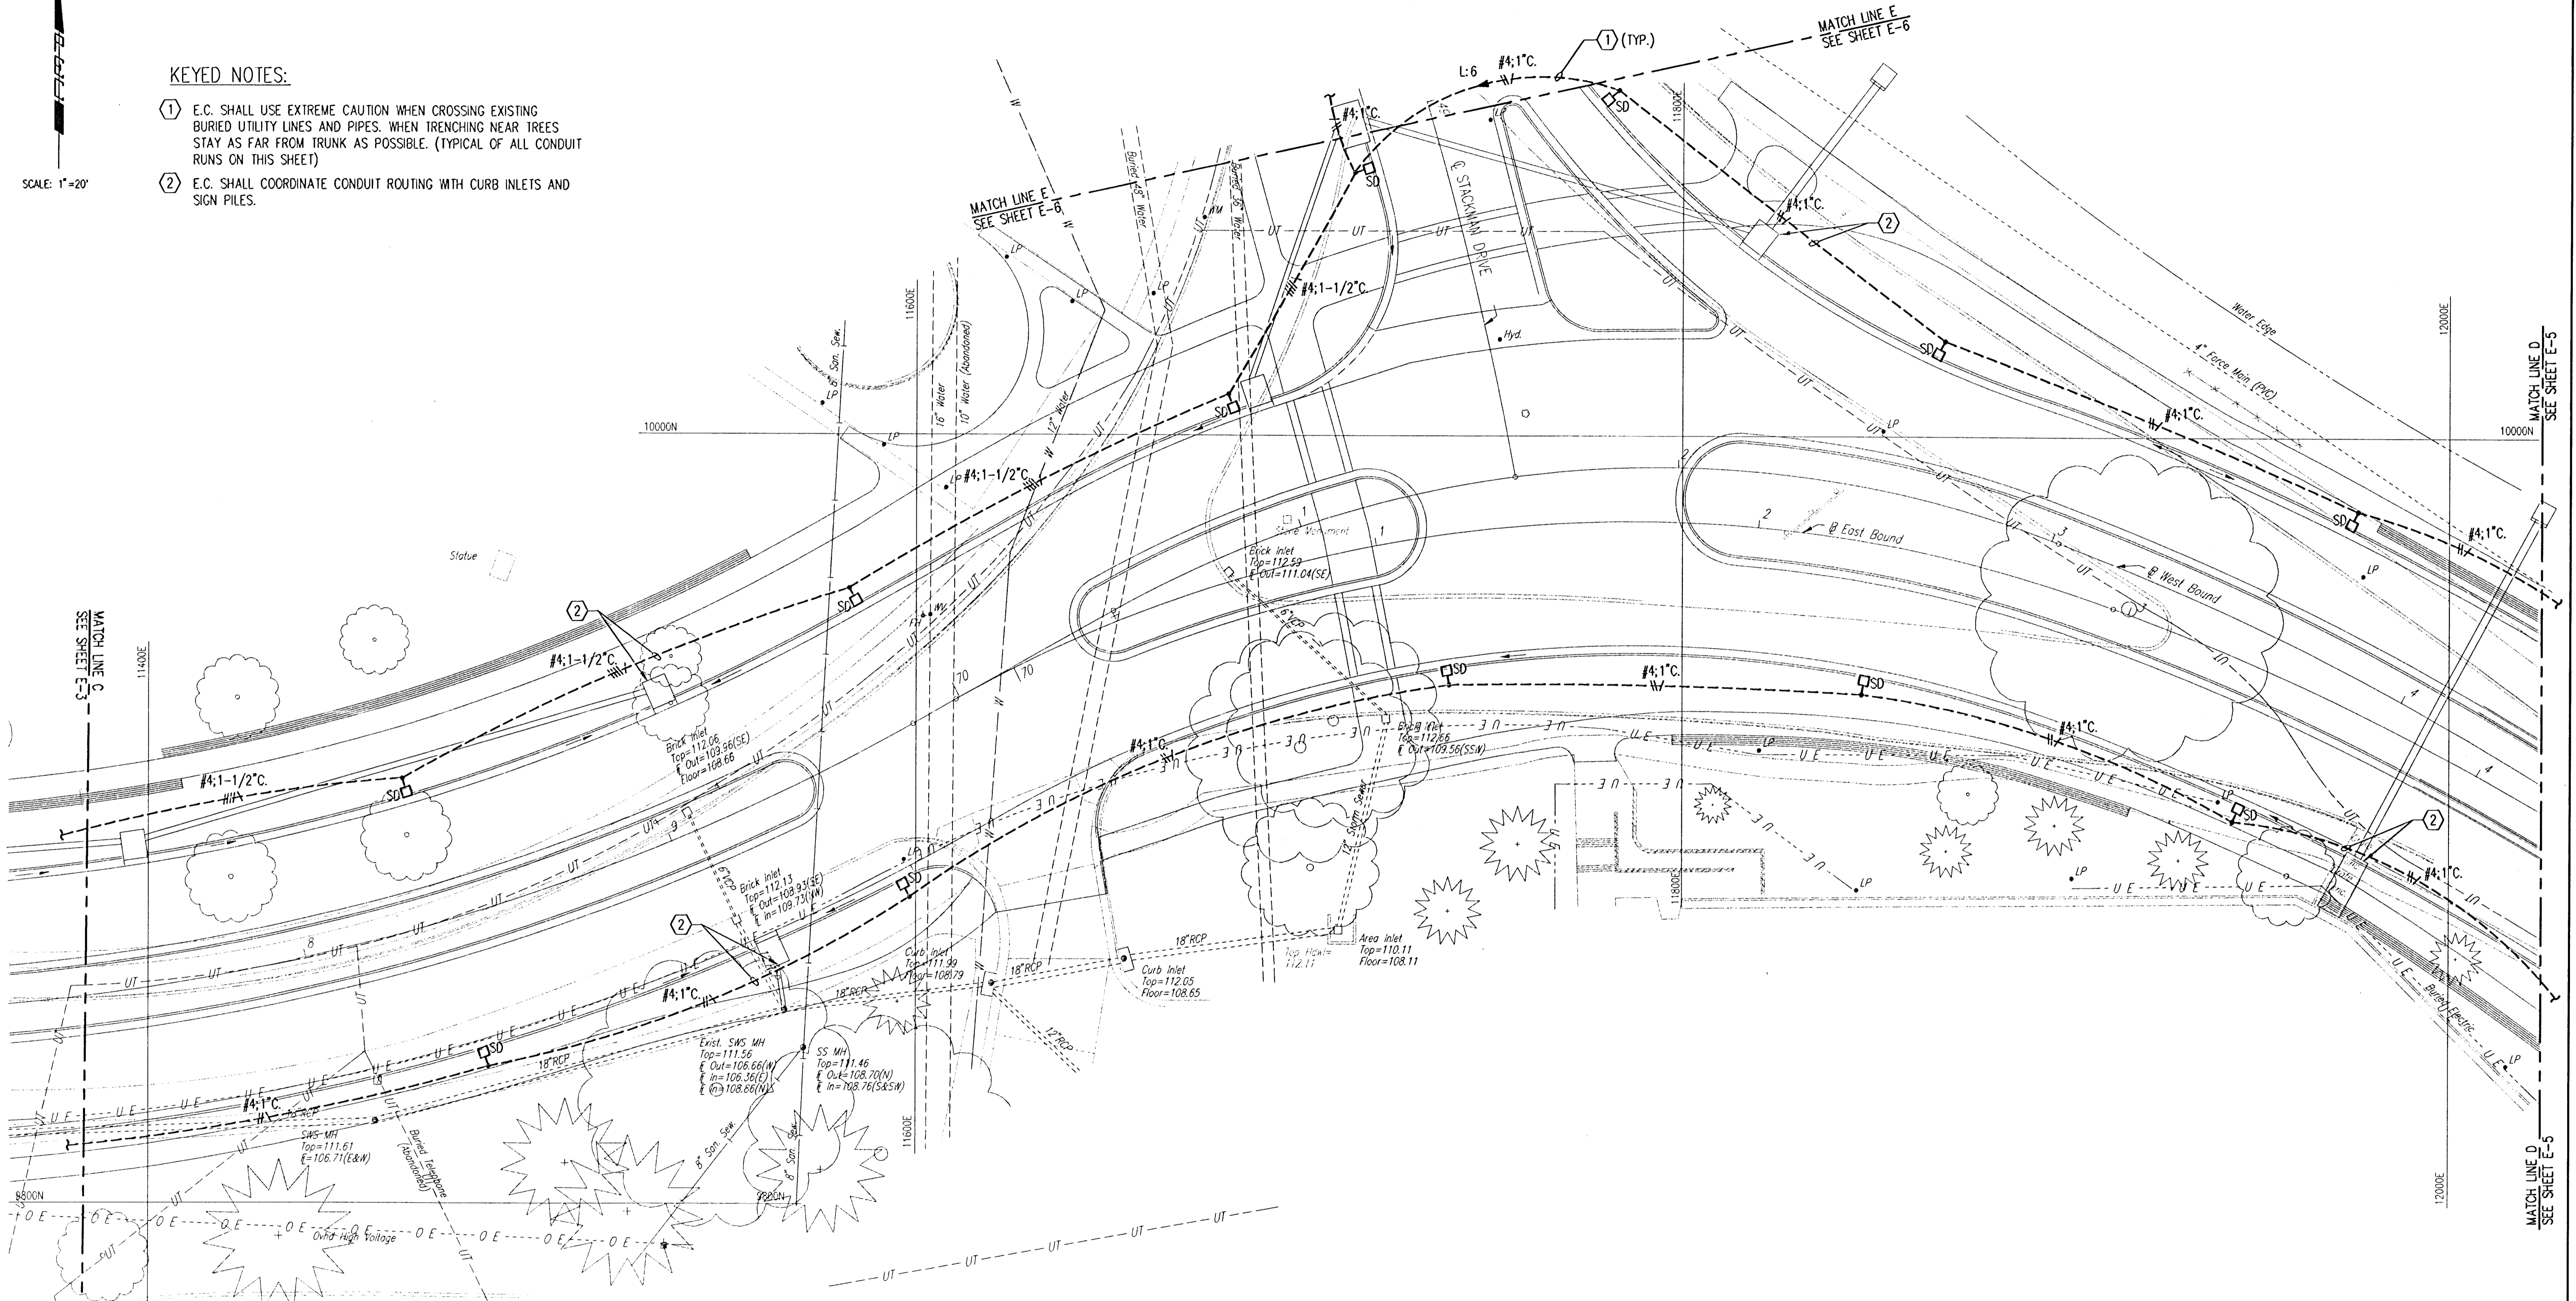

KEYED NOTES:

- ① E.C. SHALL USE EXTREME CAUTION WHEN CROSSING EXISTING BURIED UTILITY LINES AND PIPES. WHEN TRENCHING NEAR TREES STAY AS FAR FROM TRUNK AS POSSIBLE. (TYPICAL OF ALL CONDUIT RUNS ON THIS SHEET)
- ② E.C. SHALL COORDINATE CONDUIT ROUTING WITH CURB INLETS AND SIGN PILES.

SCALE: 1"=20'



DSNR: ZDH OPER: MOB SCALE: 1"=20'-0"
 E:\1995\99773\000\MUSE4.DWG 06-04-2001 01:09:21 pm

REV.	DATE	DESCRIPTION

HELLMUTH, OBATA & KASSEBAUM, INC.
 DALLAS, TEXAS

 PROFESSIONAL ENGINEERING
 CONSULTANTS, P.A.
 WICHITA, KANSAS

 BRAD J. GOLDBERG
 DALLAS, TEXAS

MUSEUM DISTRICT ROADWAY AND PEDESTRIAN IMPROVEMENTS WICHITA, KANSAS			
LIGHTING PLAN			
PROJECT NO. 99773-000		SCALE: 1"=20'	SHEET E-4