


VFD UPGRADE CHENEY PUMP STATION

C.O.W. PROJECT NO. - 448-2022-030650
O.R.G NO. - XXXXXX

CITY OF WICHITA, KANSAS
PAUL GUNZELMAN, P.E. - INTERIM CITY ENGINEER

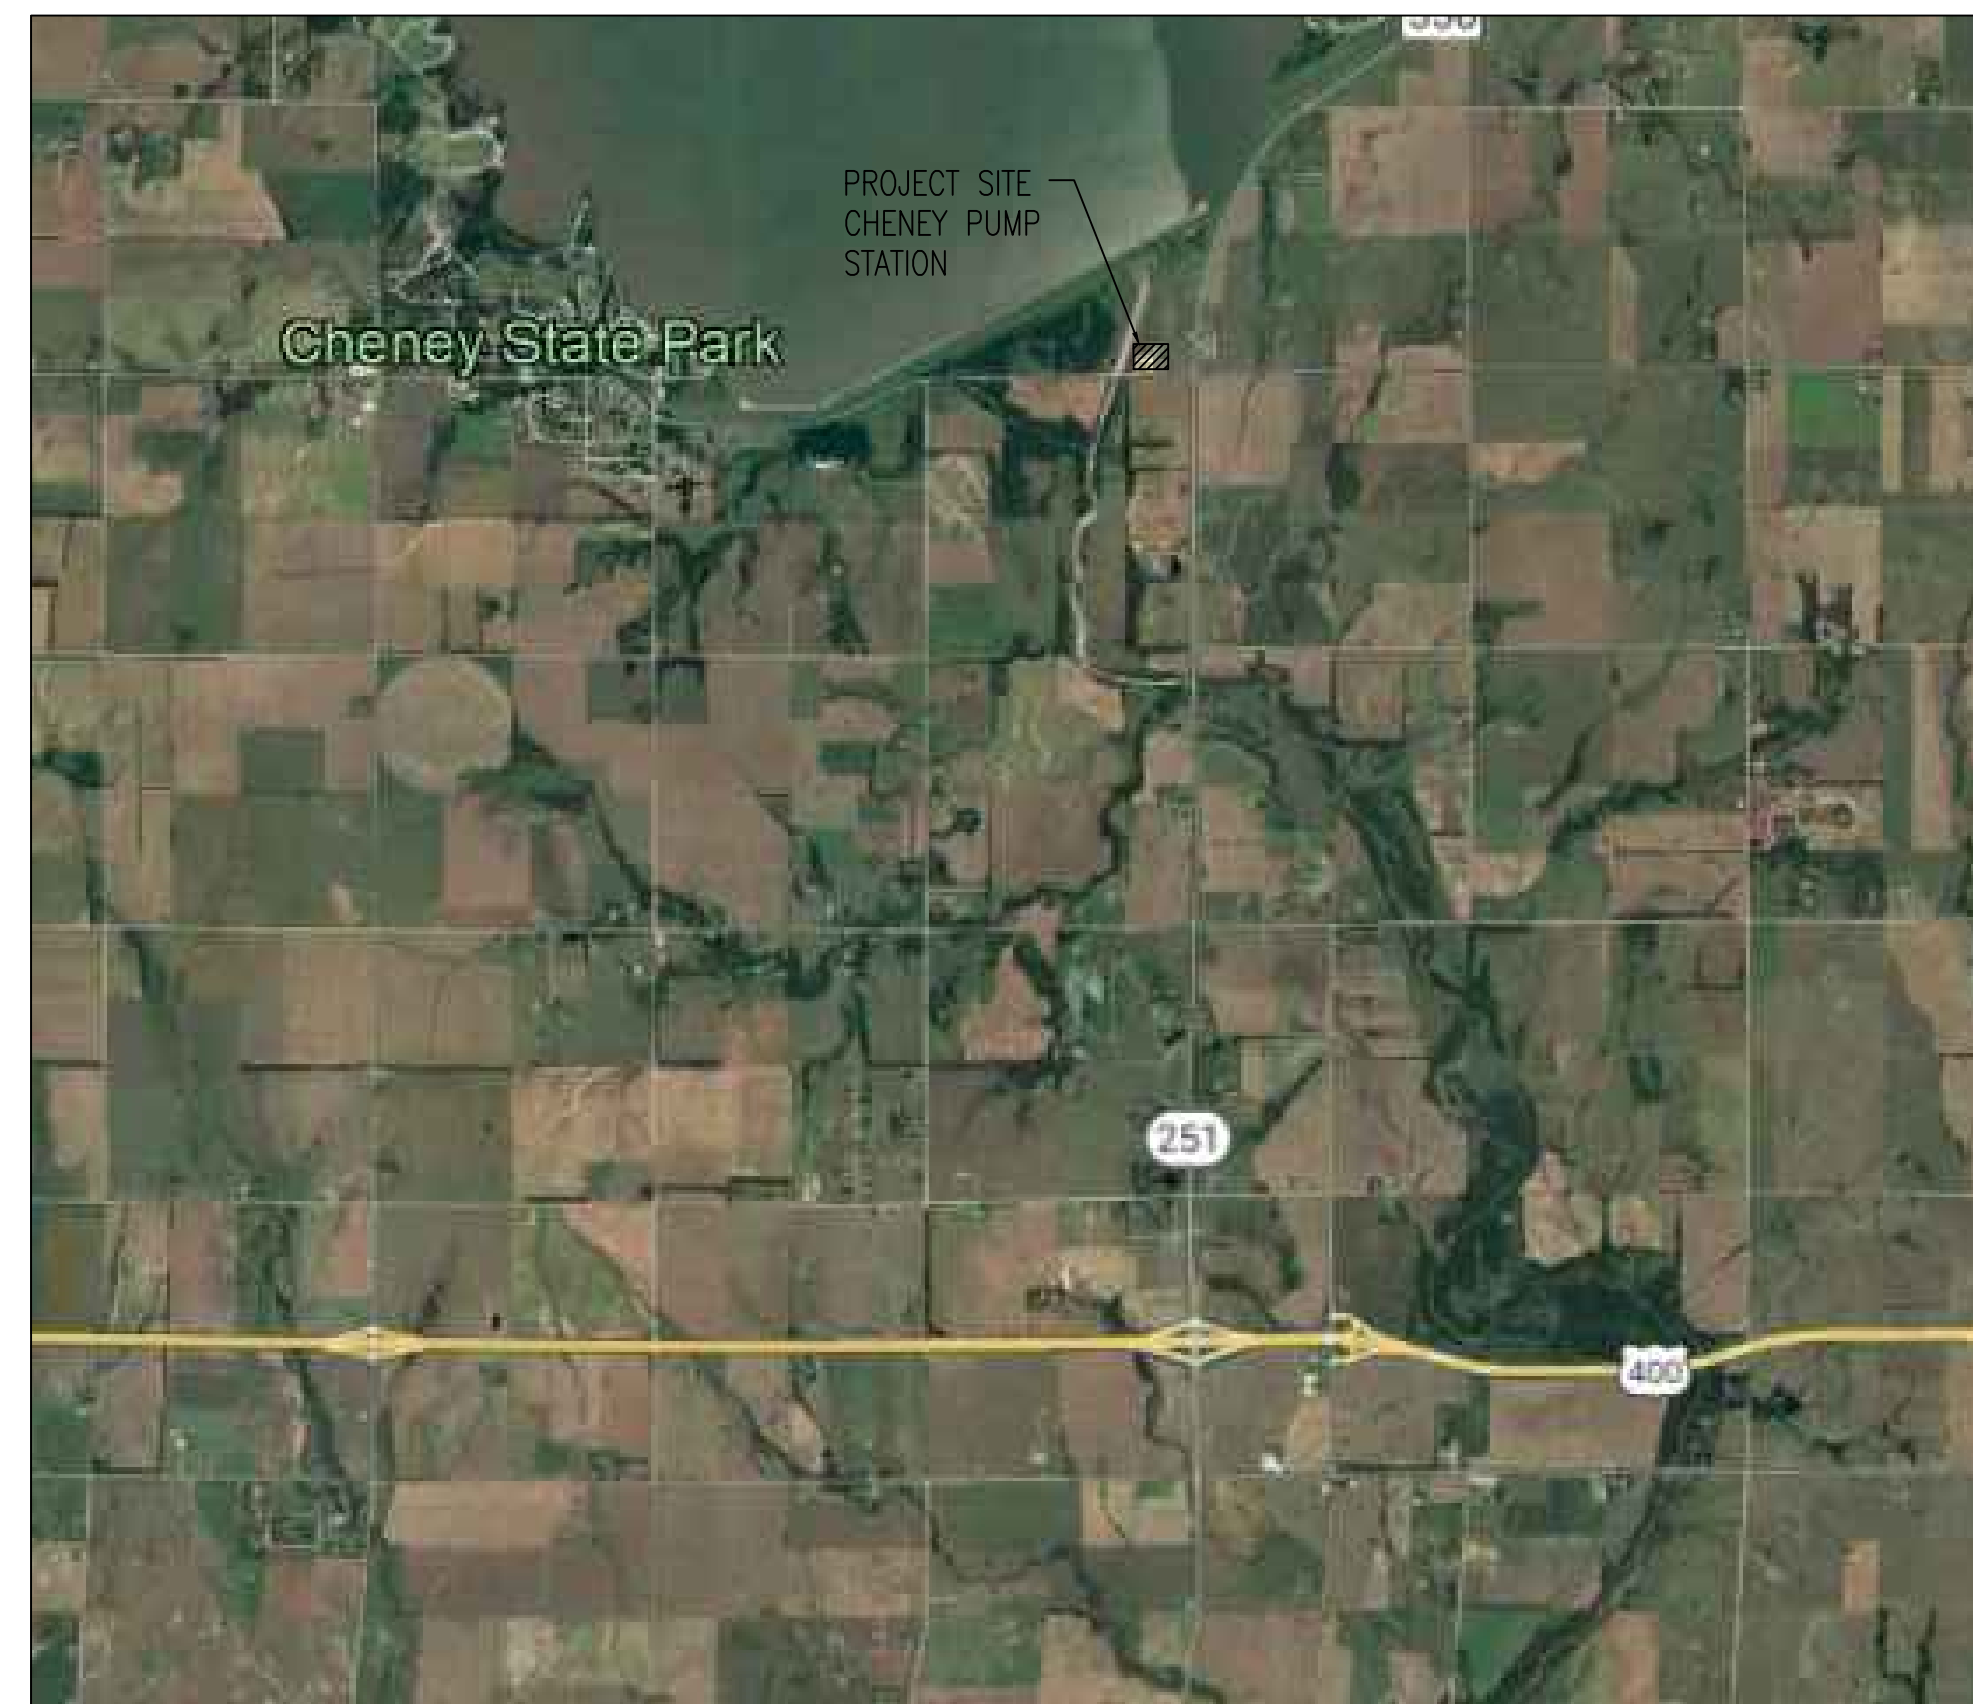

SHEET INDEX	
SHEET NO.	DESCRIPTION
M1.1	MECHANICAL COVER SHEET
M2.1	ENLARGED MECHANICAL PLAN
M3.1	MECHANICAL SPECIFICATIONS
M3.2	MECHANICAL SPECIFICATIONS
E0.1	ELECTRICAL LEAD SHEET
E0.2	ELECTRICAL PARTIAL ONE-LINE DIAGRAMS
E1.1	ELECTRICAL DETAILS
E2.1	ELECTRICAL PUMP ROOM - DEMOLITION
E3.2	ELECTRICAL PUMP ROOM - PLAN
E6.1	ELECTRICAL CONTROLS SCHEMATIC

PROJECT ADDRESS: 39500 W 21ST ST. N, CHENEY, KANSAS 67025

OCTOBER 2023
PLANS PREPARED BY
PROFESSIONAL ENGINEERING CONSULTANTS, P.A.
ENGINEERS
WICHITA, KANSAS



CITY OF WICHITA, KS
CHENEY VARIABLE FREQUENCY DRIVE
UPGRADE
CHENEY, KS

Issue:		

JOB NO.	217043-012
DATE	OCTOBER 2023
PM	RDB
DESIGNED BY	DCG
DRAWN BY	JAB
CHECKED BY	RWW

COVER SHEET
G0.1

Save: 10-06-2023 12:07:00 PM by SHANA MATZEN
Plot Scale 1:7378248 10-06-2023 12:08:07 PM by SHANA MATZEN
U:\Wichita-civil\2023\217043\012\Elec\Drawings\G0.1 COVER SHEET