


HICKORY CREEK ESTATES UTILITY PLAN

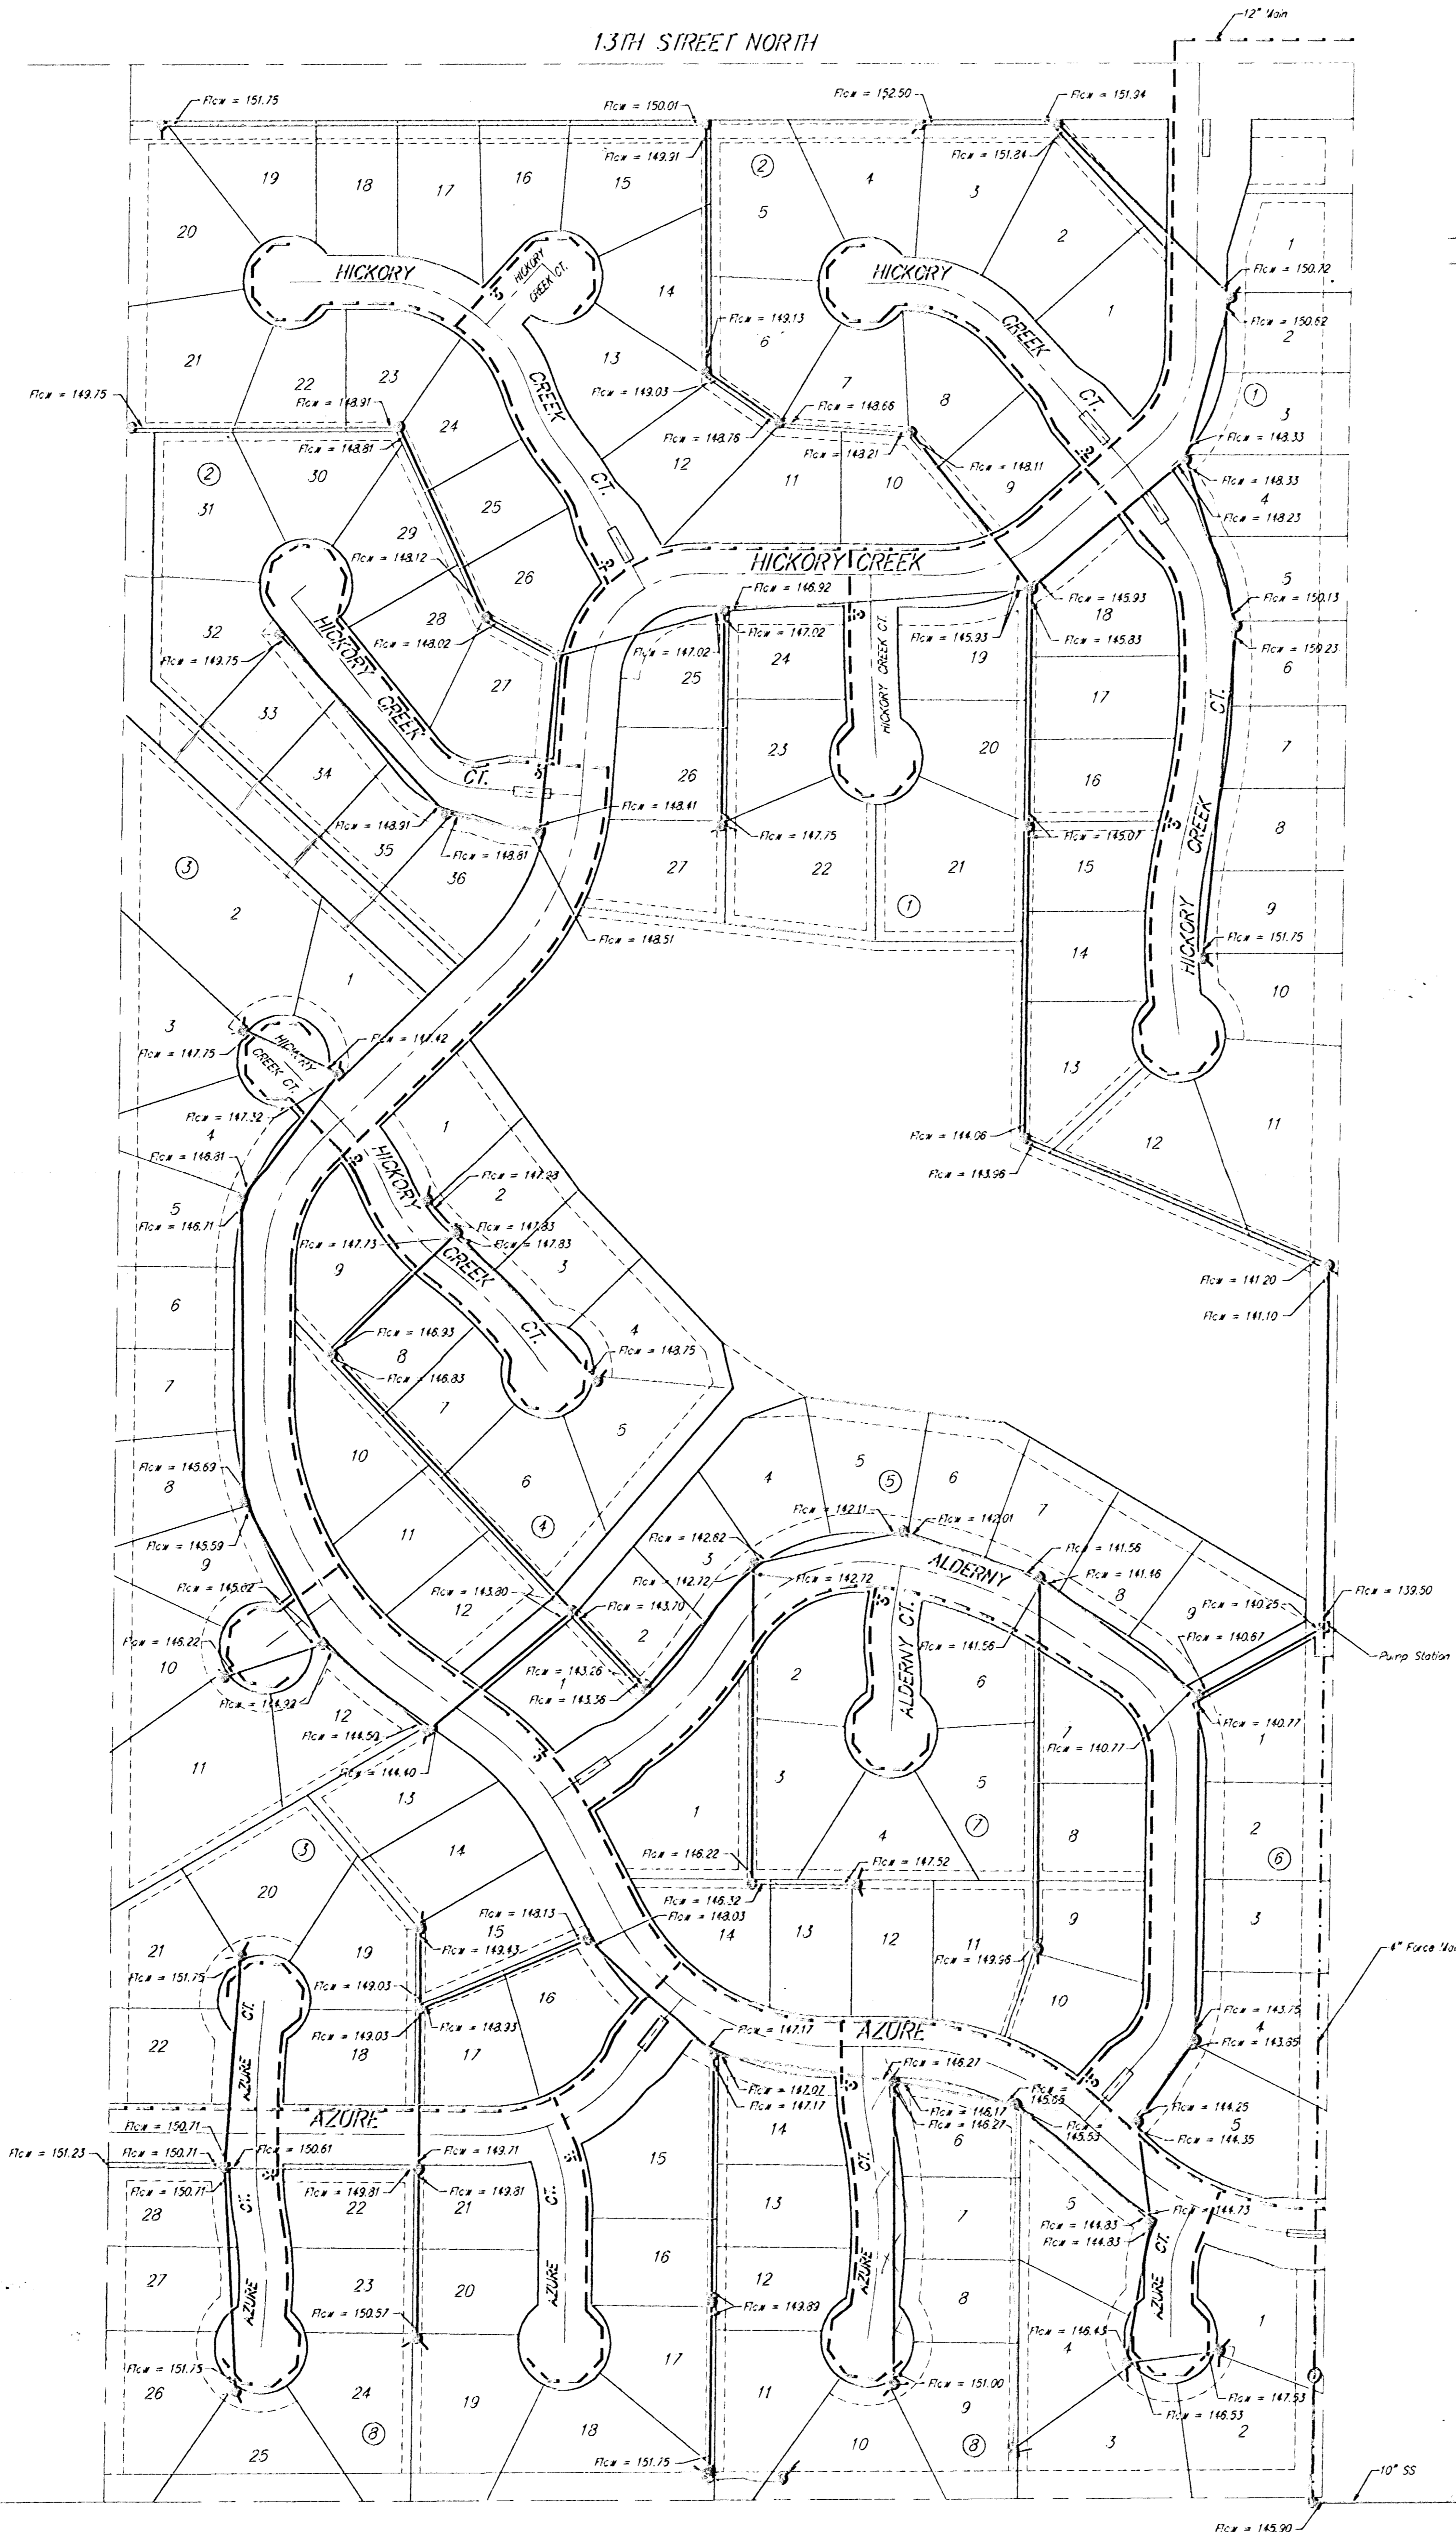

Scale: 1" = 100'

LEGEND

- Proposed 8" Sanitary Sewer
- - - Proposed 8" Water Line

Note:
Impeller shall be improved at Oakton Hills Pump Station if necessary.