


SURV. PLOT. DES. DR. TR. CKD. APP.

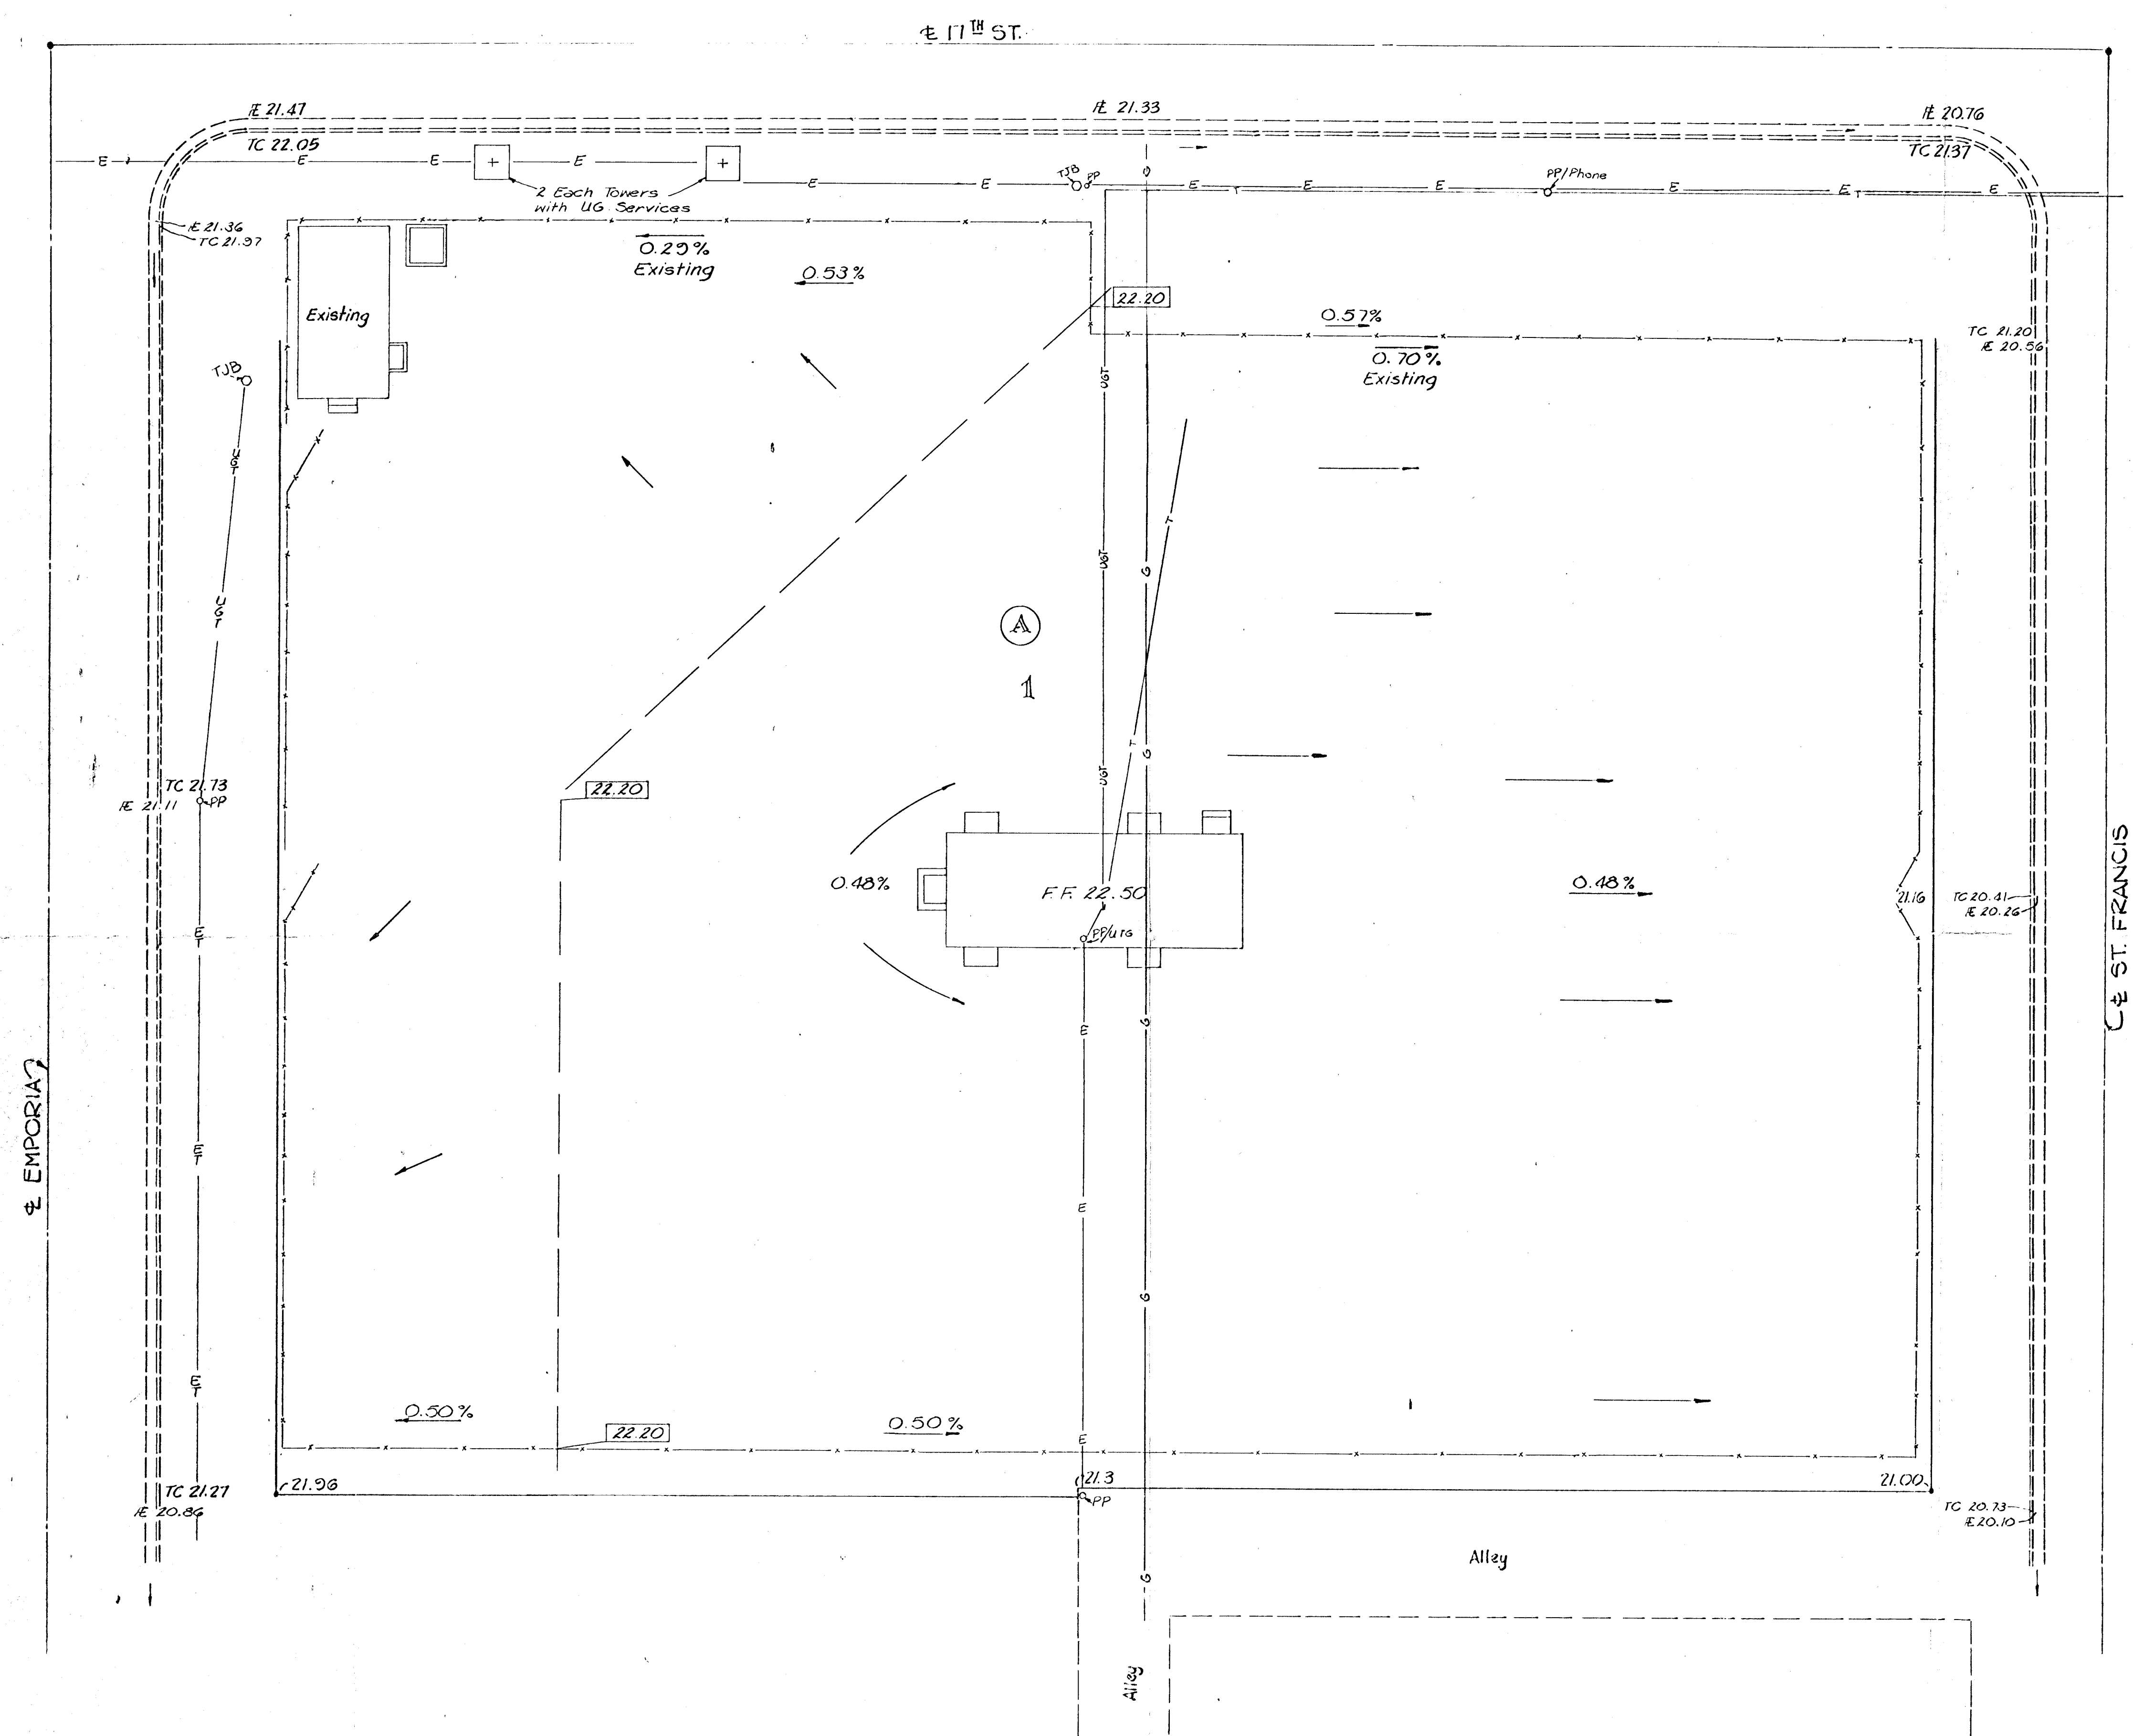

Note:
 Drainage will be to the streets
 via driveways, flumes or other
 approved methods.

- LEGEND**
- 0.00 = Finish Grade Elev.
 - 00.00 = Existing Grade
 - = Flow Arrow
 - = Break Line
 - T— = Telephone Line
 - UGT— = Underground Telephone Cable
 - G— = 3" Gas Line (Gas Service Co.)

B.M. "M" in Meuller on F.H.
 N.E. Int. 17th & Emporia El. 124.33

KANSAS GAS AND ELECTRIC COMPANY WICHITA, KANSAS	
DRAINAGE PLAN 17th St. SUBSTATION	
Booker/Freund Engineers Architects Planners	
SCALE 1/16" = 1'	DATE Dec, 1981
DWG. NO. K-1043-201	