


KANSAS DEPARTMENT OF TRANSPORTATION  
**WEBB ROAD DRAINAGE PLAN**  
 PROJECT NO. 87-U-1362-01 SEDGWICK CO.  
 MD-KANSAS ENGINEERING CONSULTANTS, INC.  
 WICHITA, KANSAS  
 DESIGNED BY: JNU  
 CHECKED BY: JNU  
 DRAWN BY: DVM  
 DATE: MARCH, 1992 SHEET 113 OF 149

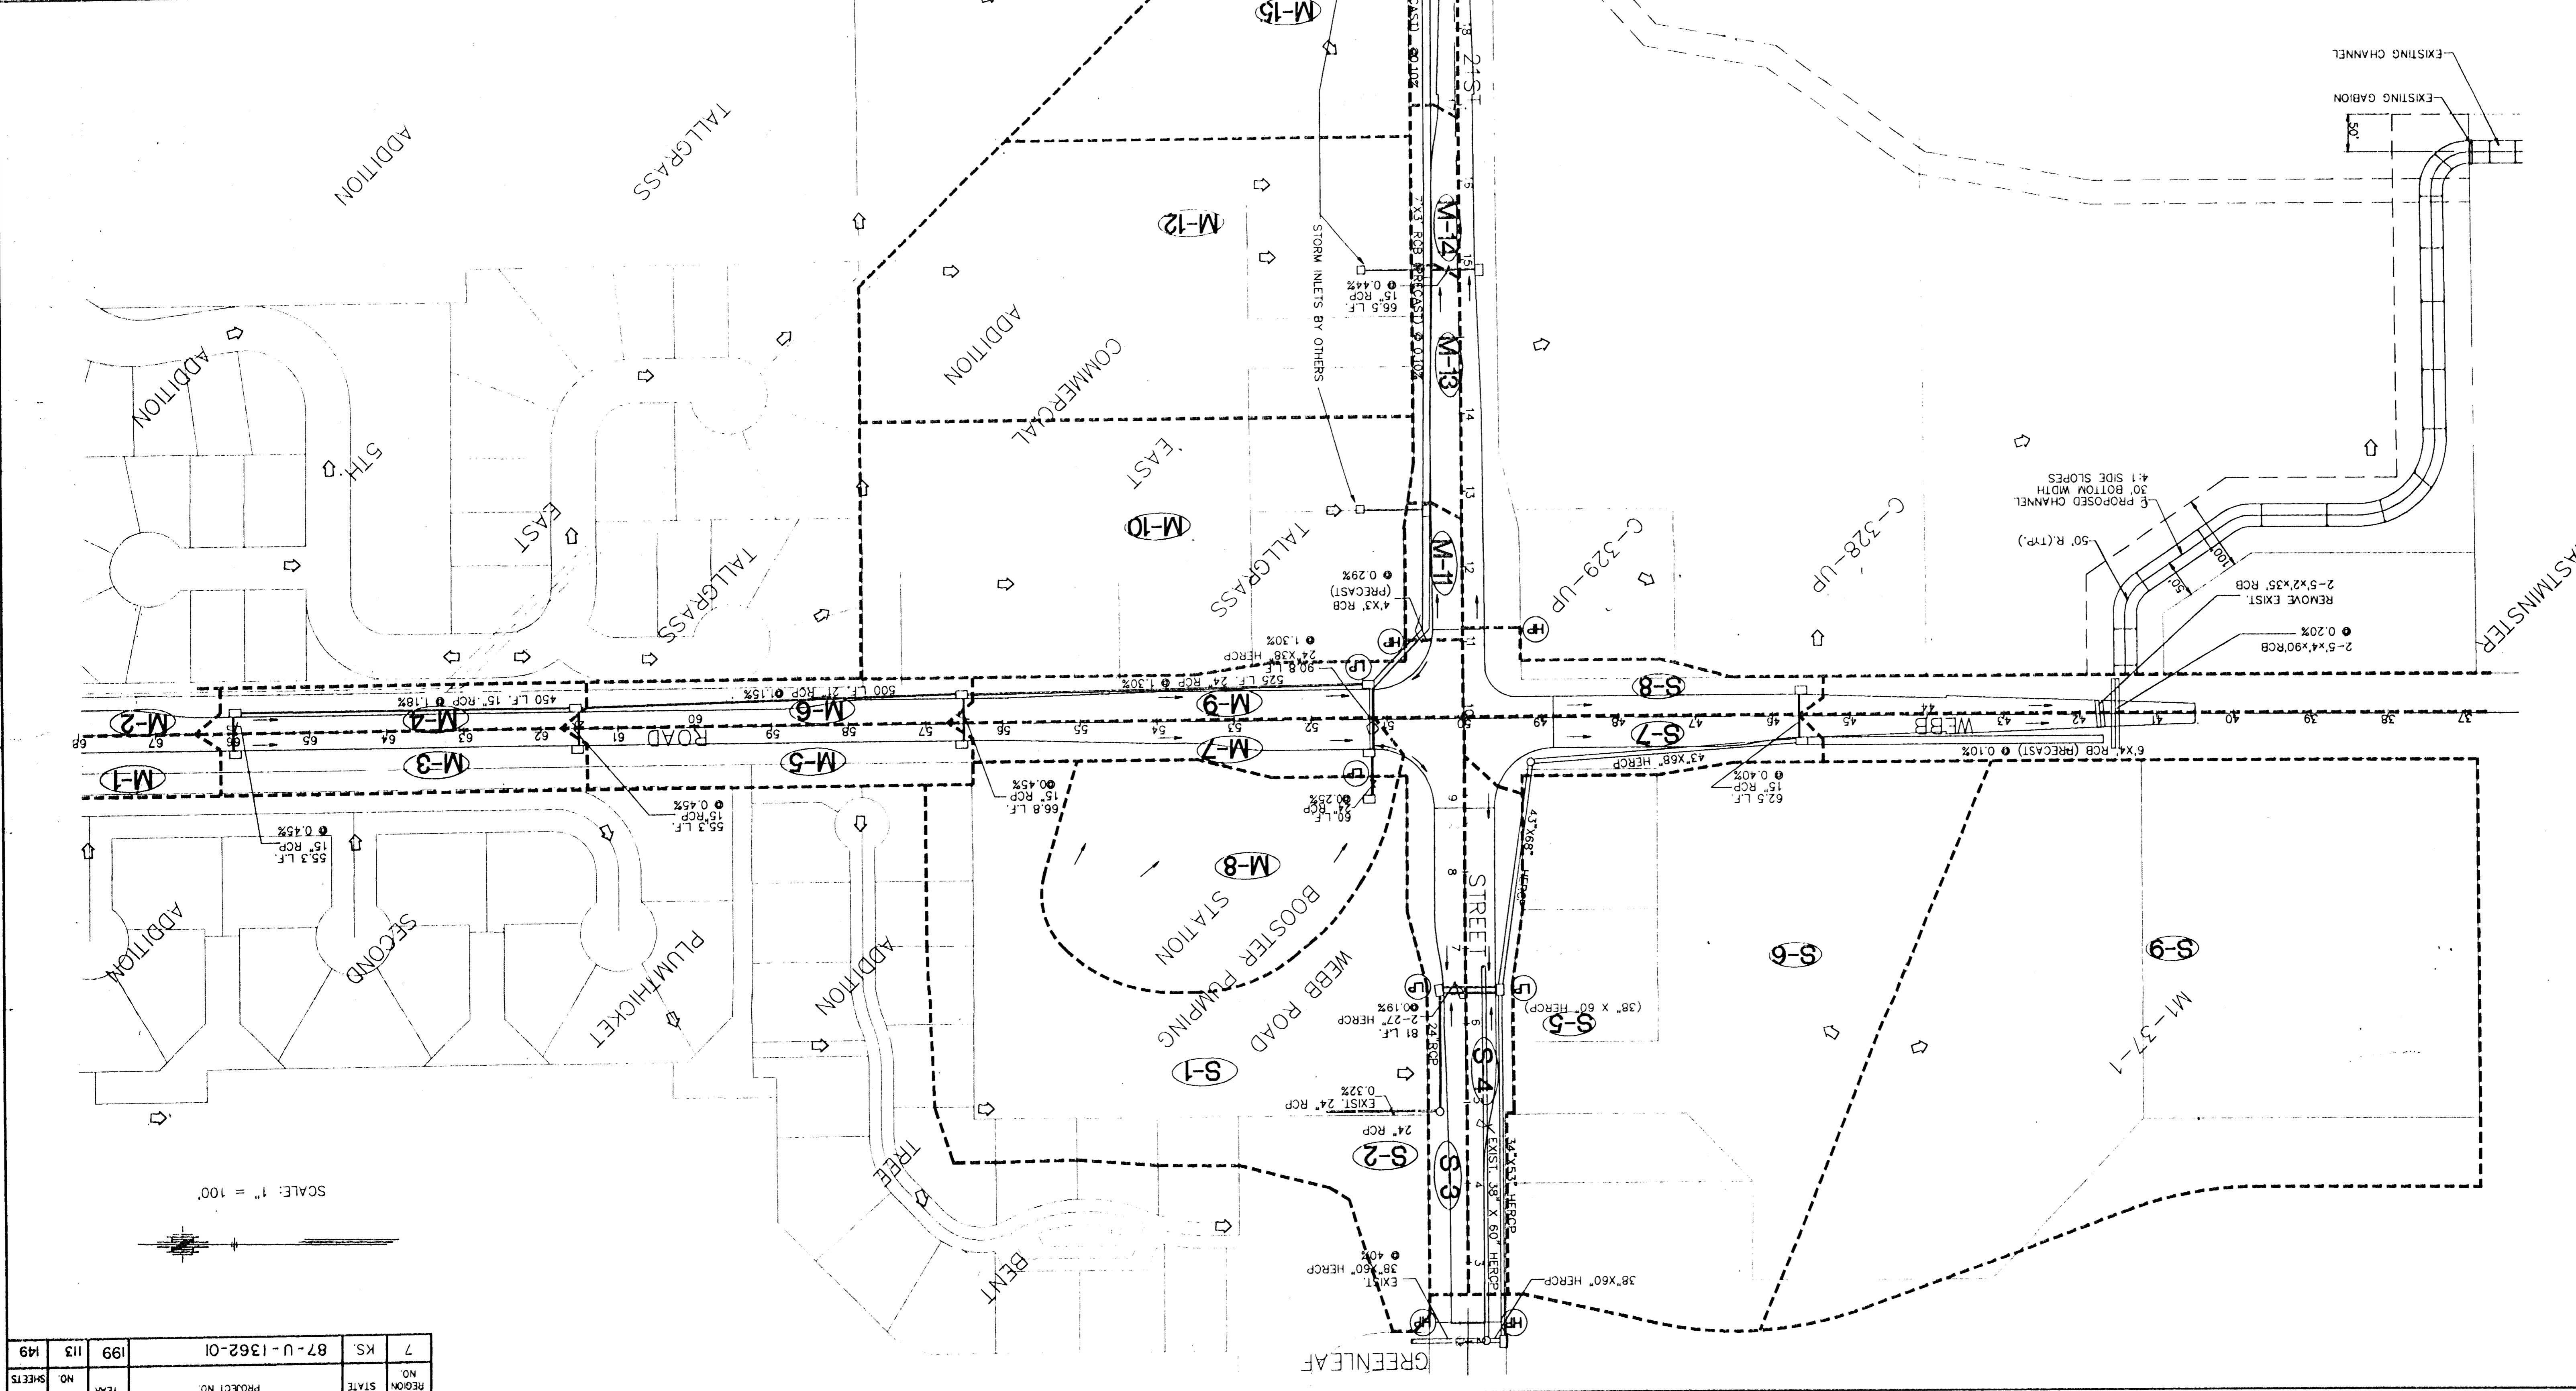

SCALE: 1" = 100'

7	KS.	87-U-1362-01	199	113	149
FHWA	REGION NO.	STATE	PROJECT NO.	YEAR	SHEET TOTAL