



PROFESSIONAL ENGINEERING CONSULTANTS, P.A.  
 ENGINEERS  
 MICHIGAN KANSAS  
 Checked by: CSB  
 Drawn by: DCF  
 Date: (REV) 10/88  
 Job No. 43393

DETONATION AREA  
GRADING PLAN

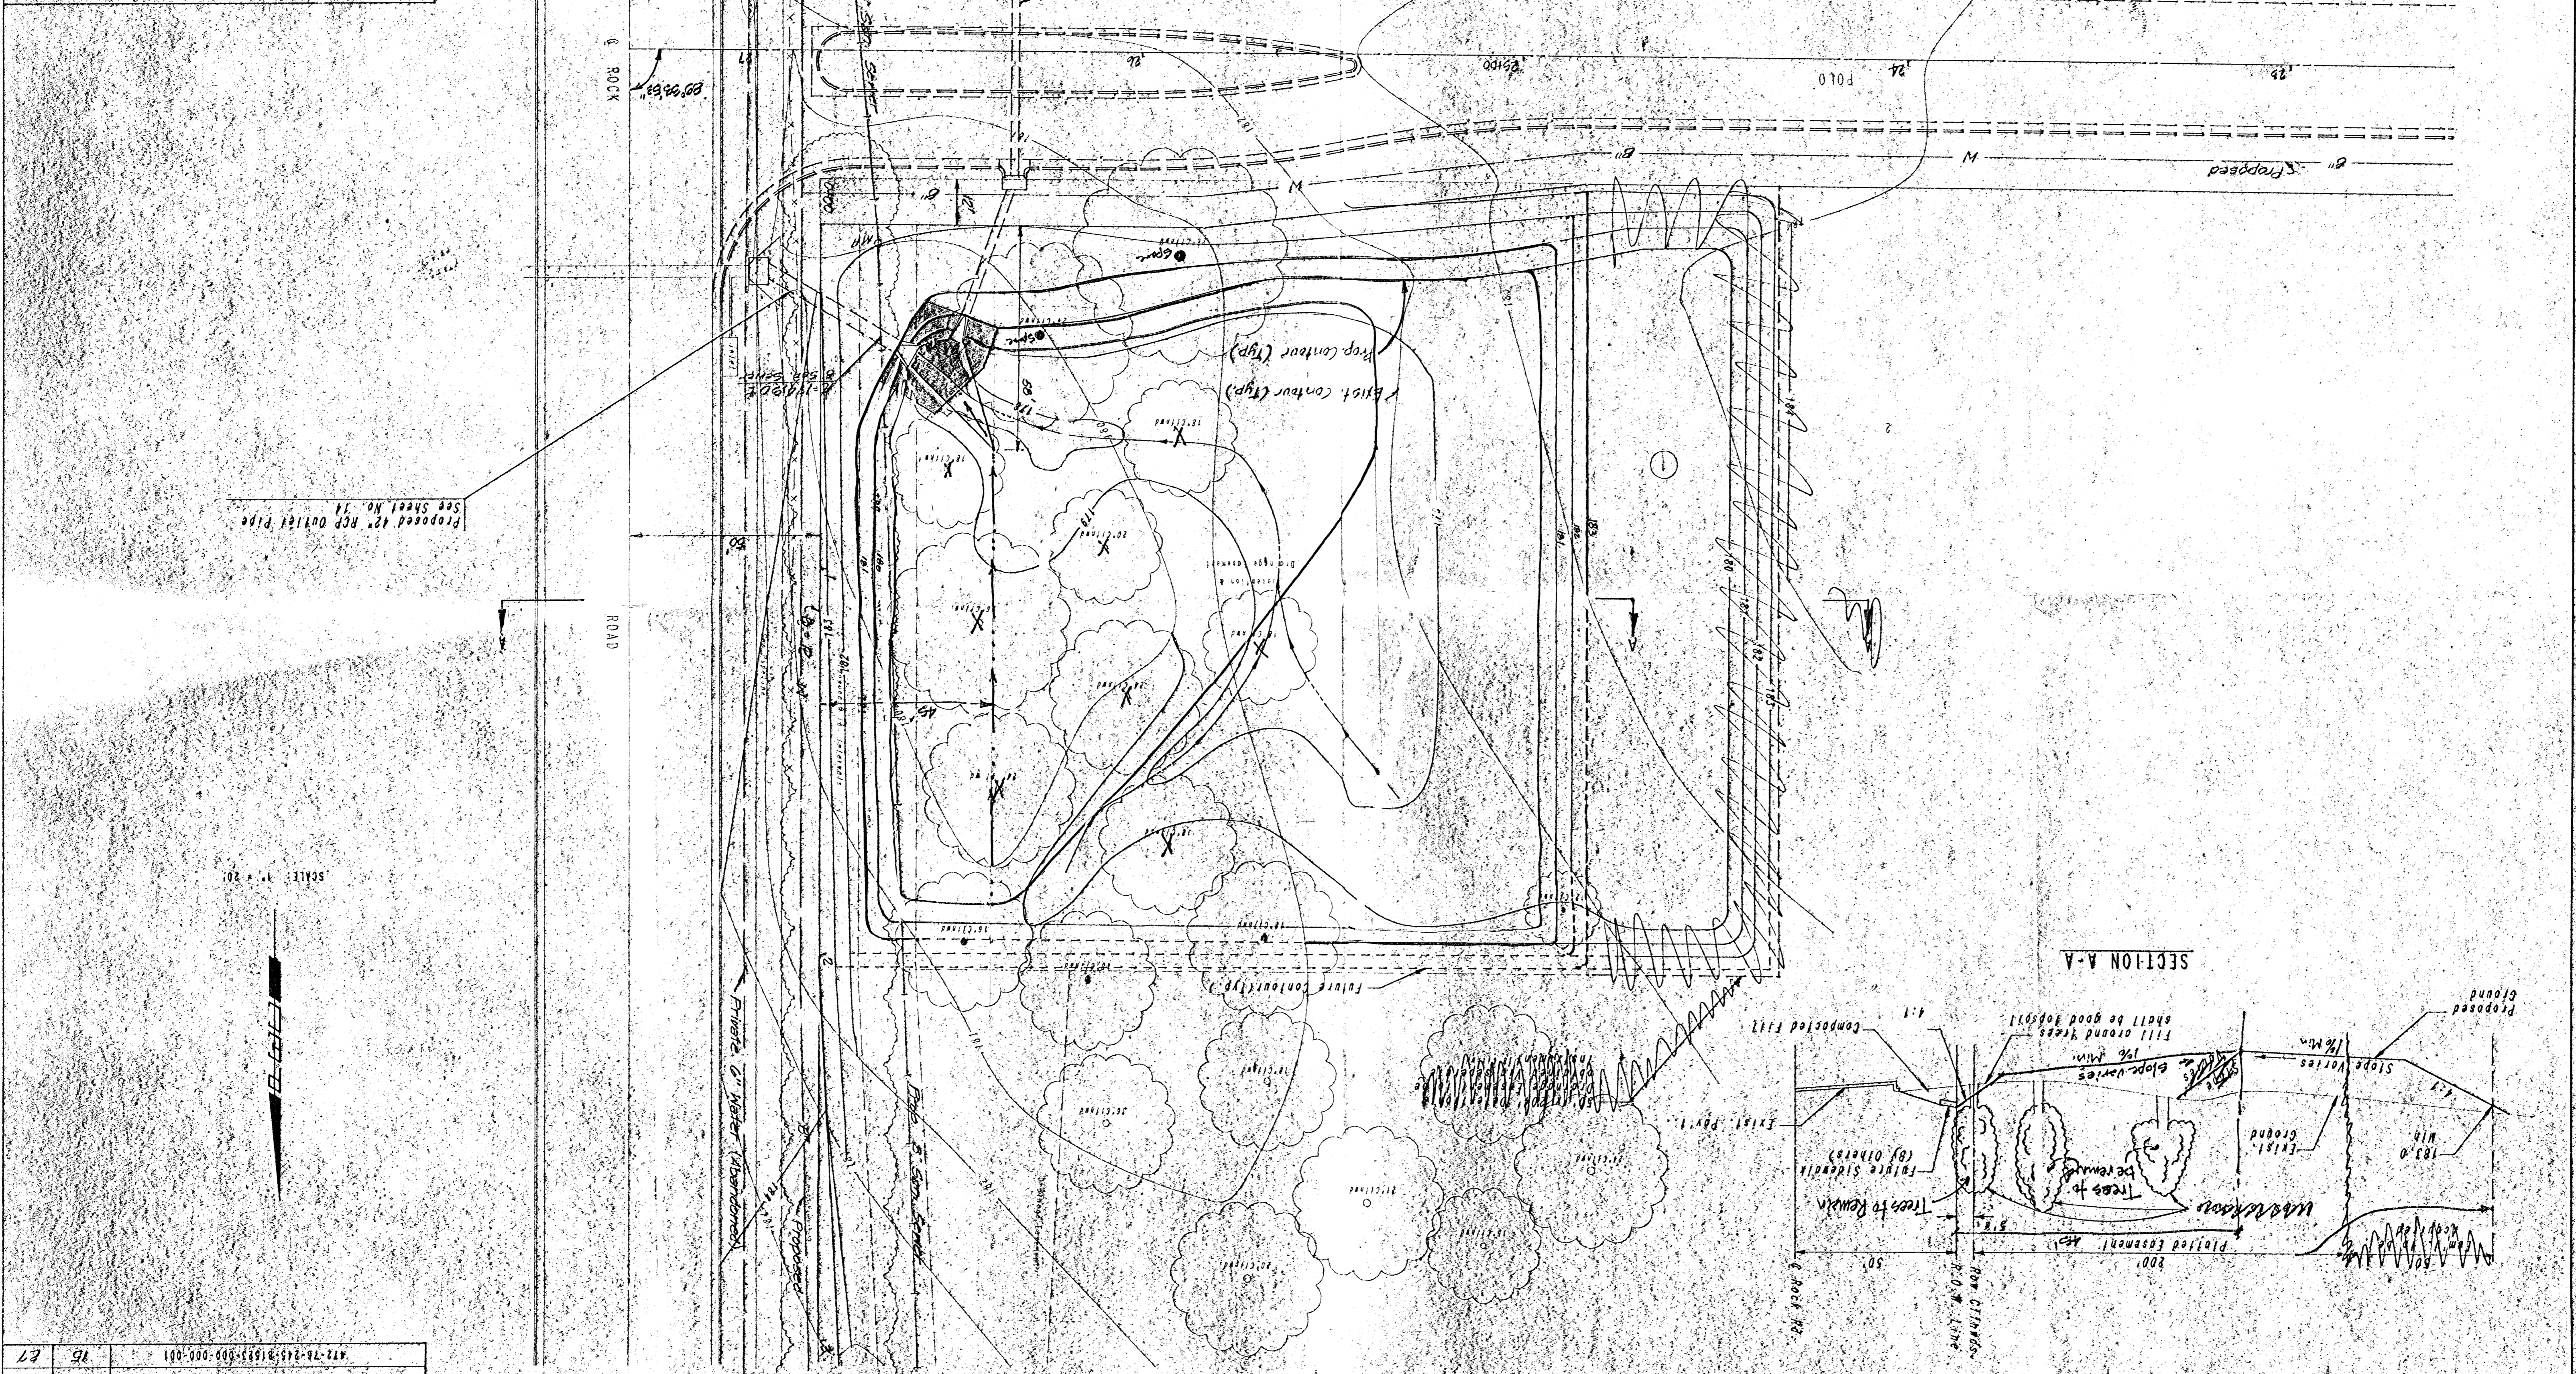

SECTION A-A

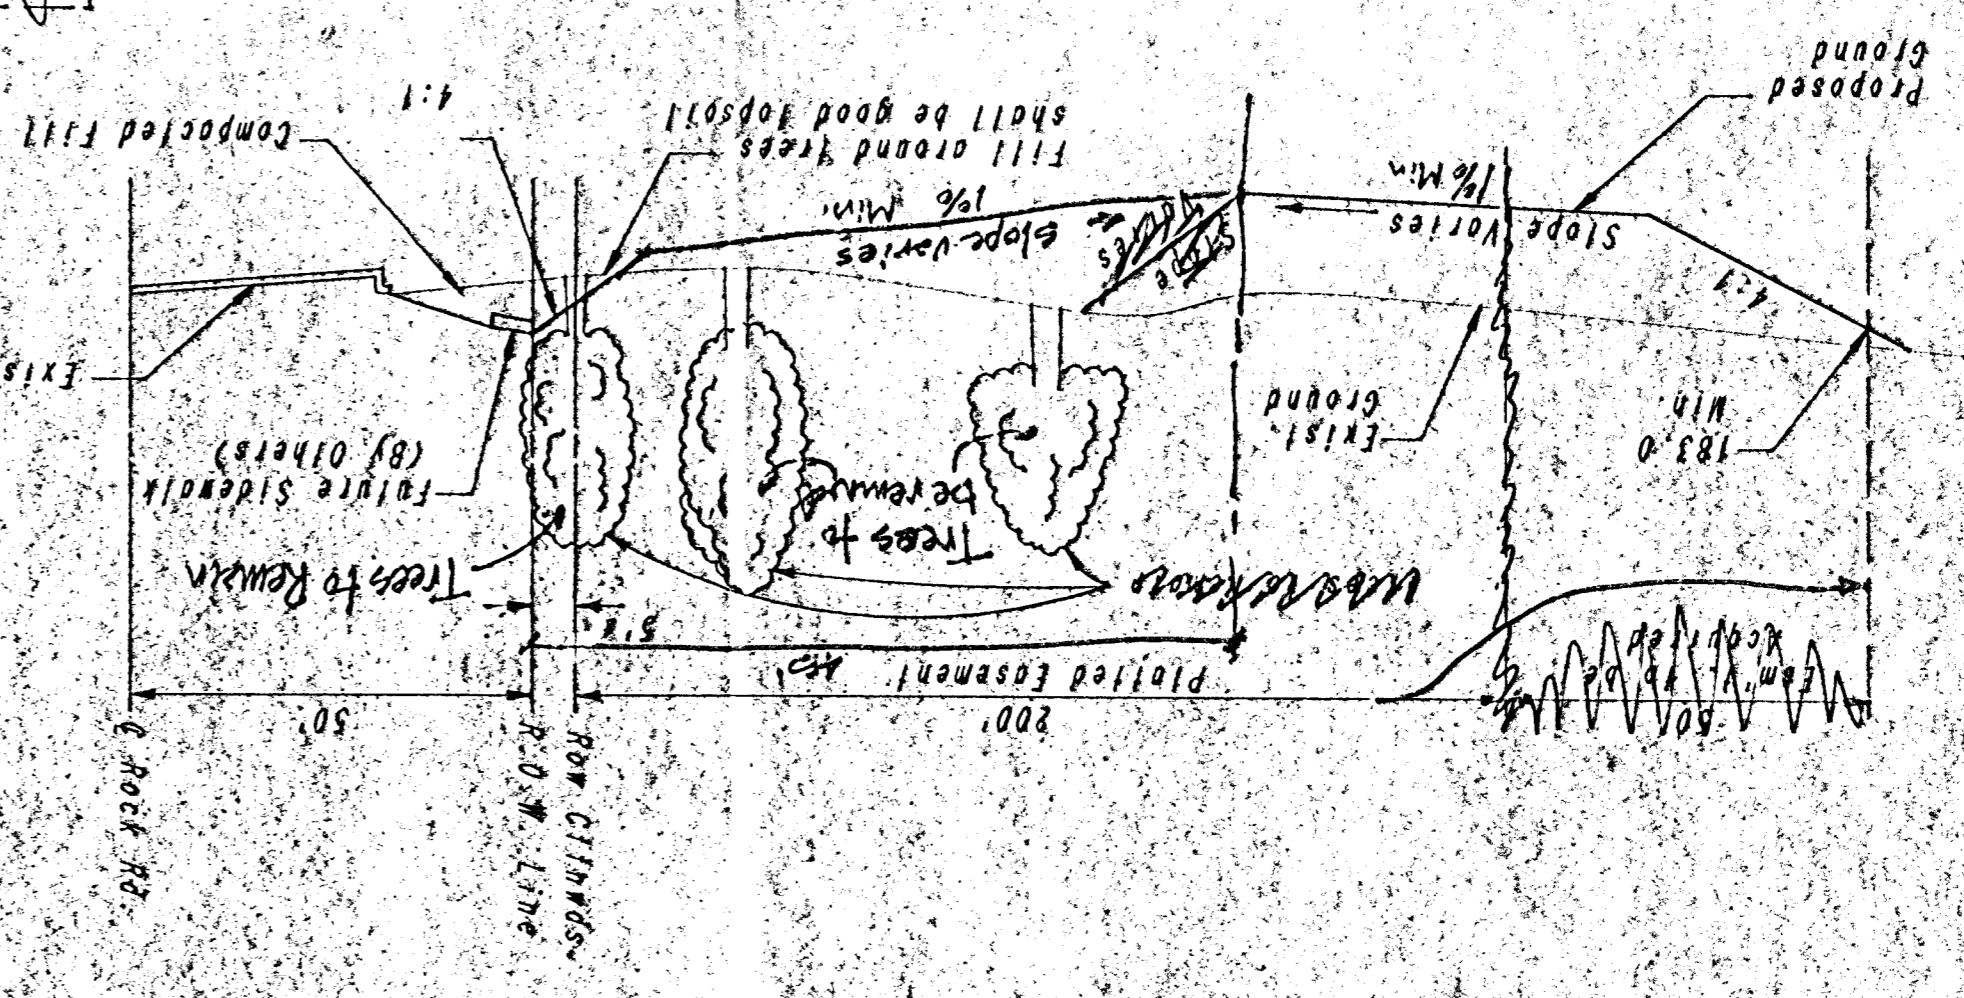

SCALE: 1" = 20'



PROJECT NO.	472-72-245-153-000-000-001
SHEET NO.	15
TOTAL SHEETS	17